


ARCHITECTURE DRAWING
DAMIEN VILLA

FOR CONSTRUCTION

OWNER :
PHILIPPE

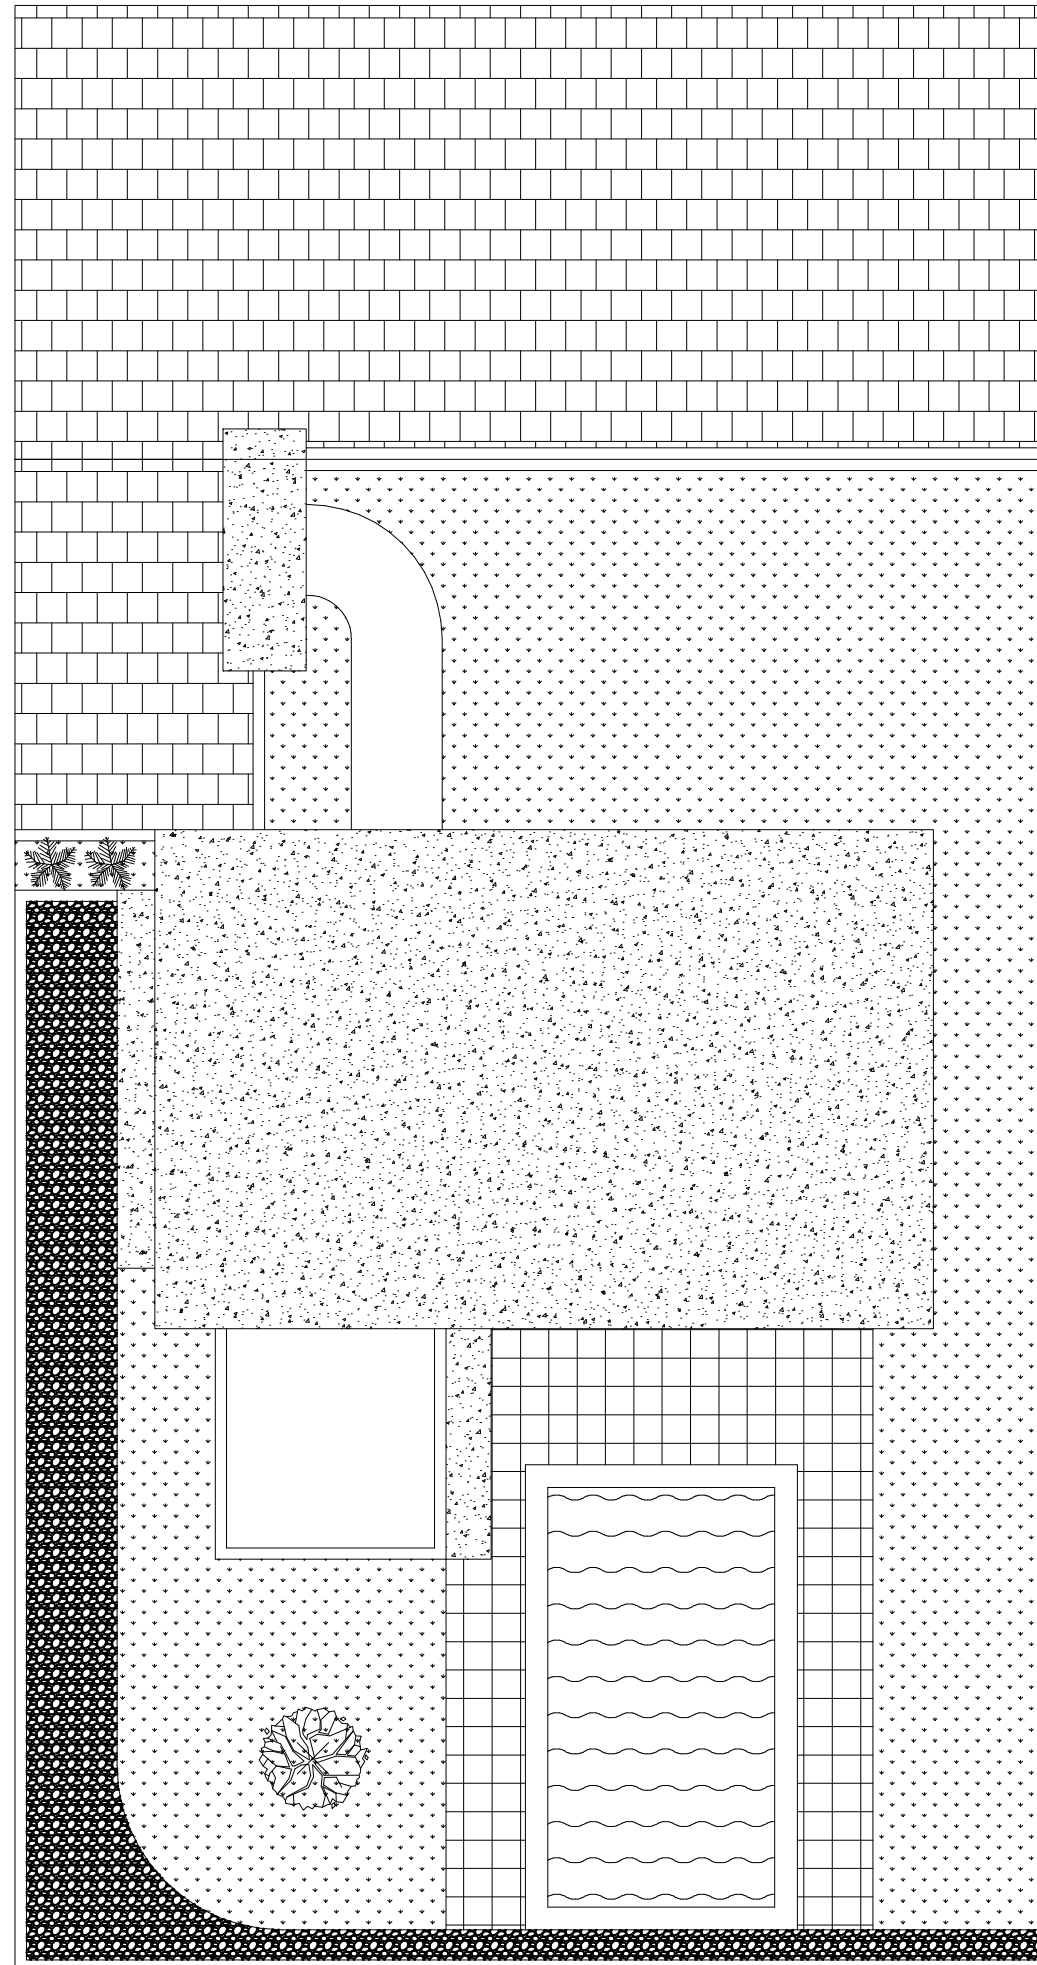



SHOP DRAWING

Project :
Damien Villa

Owner :
Mr. Philippe

Approve by :

.....
.....

Costruction Management :
PT/CV.

Check by :

.....
.....

Costruction Contractor :
PT/CV

Approve by :

.....
.....

No	Revision	Date	Signed

Architect Consultant :

.....

Structure Consultant :

.....

Mechanical Consultant :


.....

Drawing Tittle :

Siteplan

Scale	Drawn	Guntur Kusuma
1 : 100	Check	Abdi
	Approved	Mr. Philippe
Issued for :	Code	Draw no
Design Development	139	001
Date	10.11.2022	



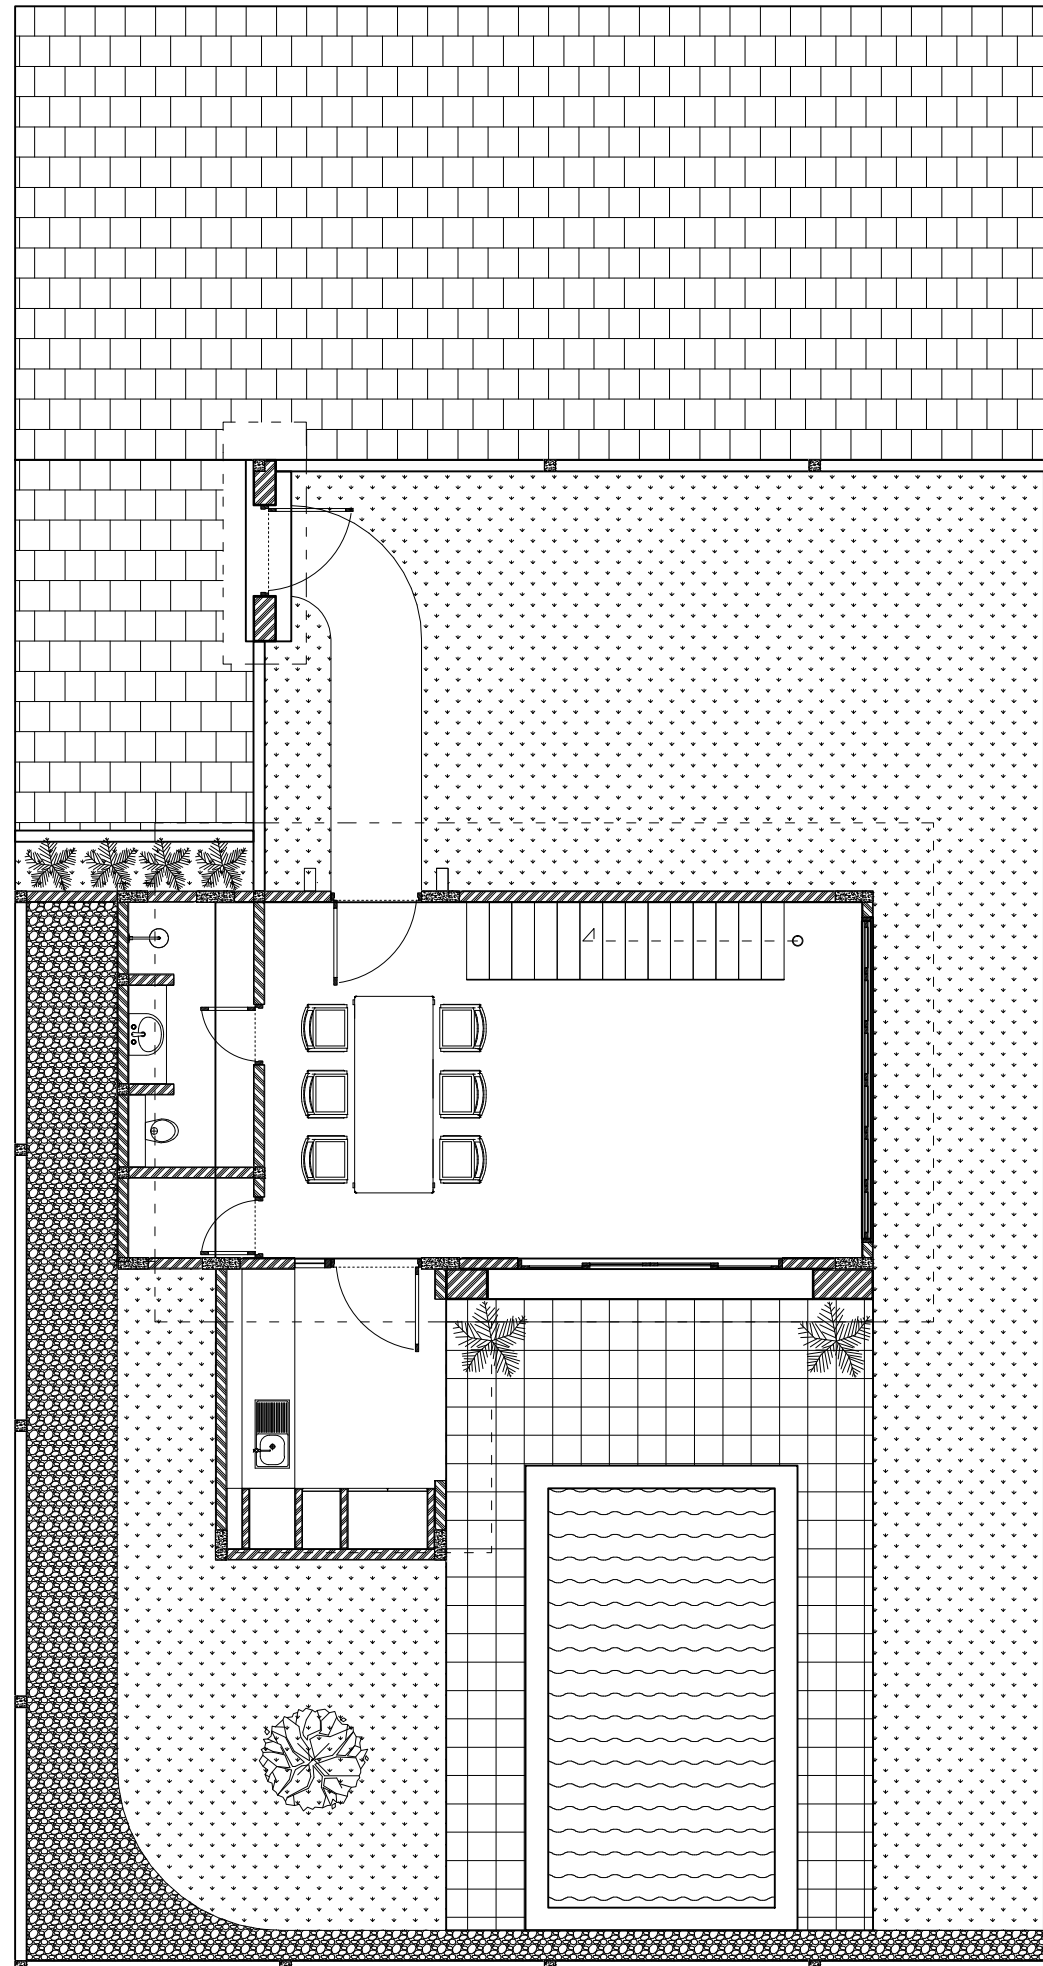

SHOP DRAWING

Project :
Damien Villa

Owner :
Mr. Philippe

Approve by :
.....
.....

Costruction Management :
PT/CV.

Check by :
.....
.....

Costruction Contractor :
PT/CV

Approve by :
.....
.....

No	Revision	Date	Signed

Architect Consultant :
.....

Structure Consultant :
.....

Mechanical Consultant :
.....

Drawing Tittle :

Layout Plan

Scale	Drawn	Guntur Kusuma
1 : 100	Check	Abdi
	Approved	Mr. Philippe
Issued for :	Code	Draw no
Design Development	139	002
Date	10.11.2022	



SHOP DRAWING

Project :
Damien Villa

Owner :
Mr. Philippe

Approve by :
.....
.....

Costruction Management :
PT/CV.

Check by :
.....
.....

Costruction Contractor :
PT/CV

Approve by :
.....
.....

No	Revision	Date	Signed


Architect Consultant :
.....

Structure Consultant :
.....

Mechanical Consultant :
.....

Drawing Tittle :
Ground Floor

Scale	Drawn	Guntur Kusuma
1 : 100	Check	Abdi
	Approved	Mr. Philippe
Issued for :	Code	Draw no
Design Development	139	003
Date	10.11.2022	

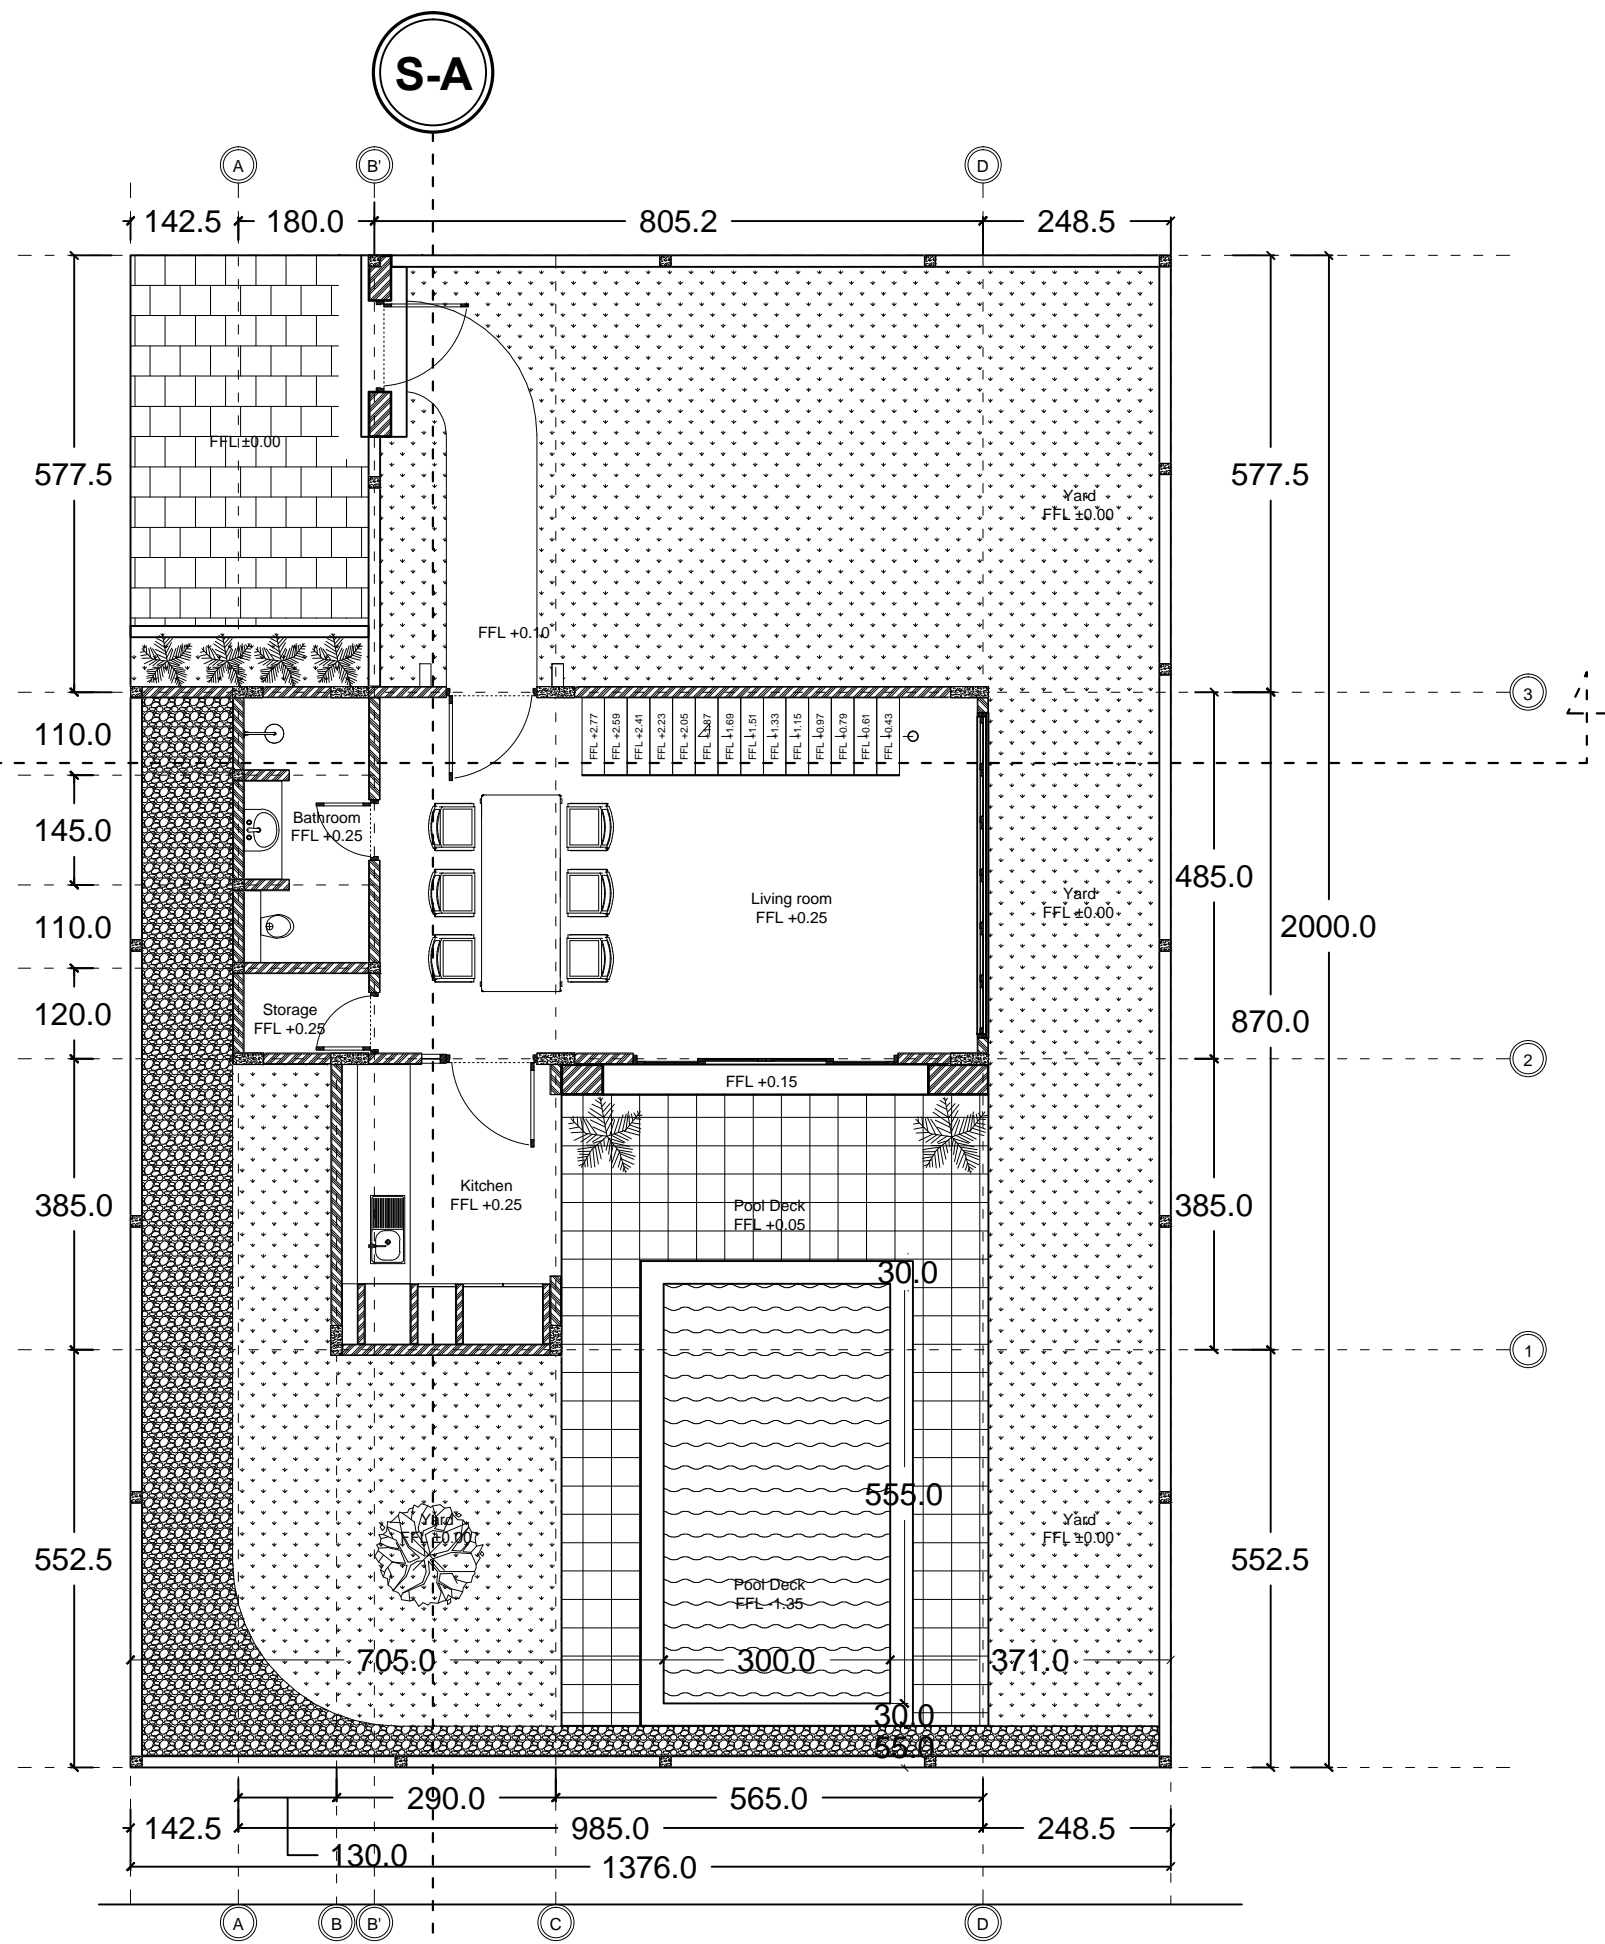

Ground Floor Mezzanine Villa
Scale 1:100



SHOP DRAWING

Project :
Damien Villa

Owner :
Mr. Philippe

Approve by :
.....
.....

Costruction Management :
PT/CV.

Check by :
.....
.....

Costruction Contractor :
PT/CV

Approve by :
.....
.....

No	Revision	Date	Signed


Architect Consultant :
.....

Structure Consultant :
.....

Mechanical Consultant :
.....

Drawing Tittle :
First Floor

Scale	Drawn	Guntur Kusuma
1 : 100	Check	Abdi
	Approved	Mr. Philippe
Issued for :		Code Draw no
Design Development		139 004
Date	10.11.2022	

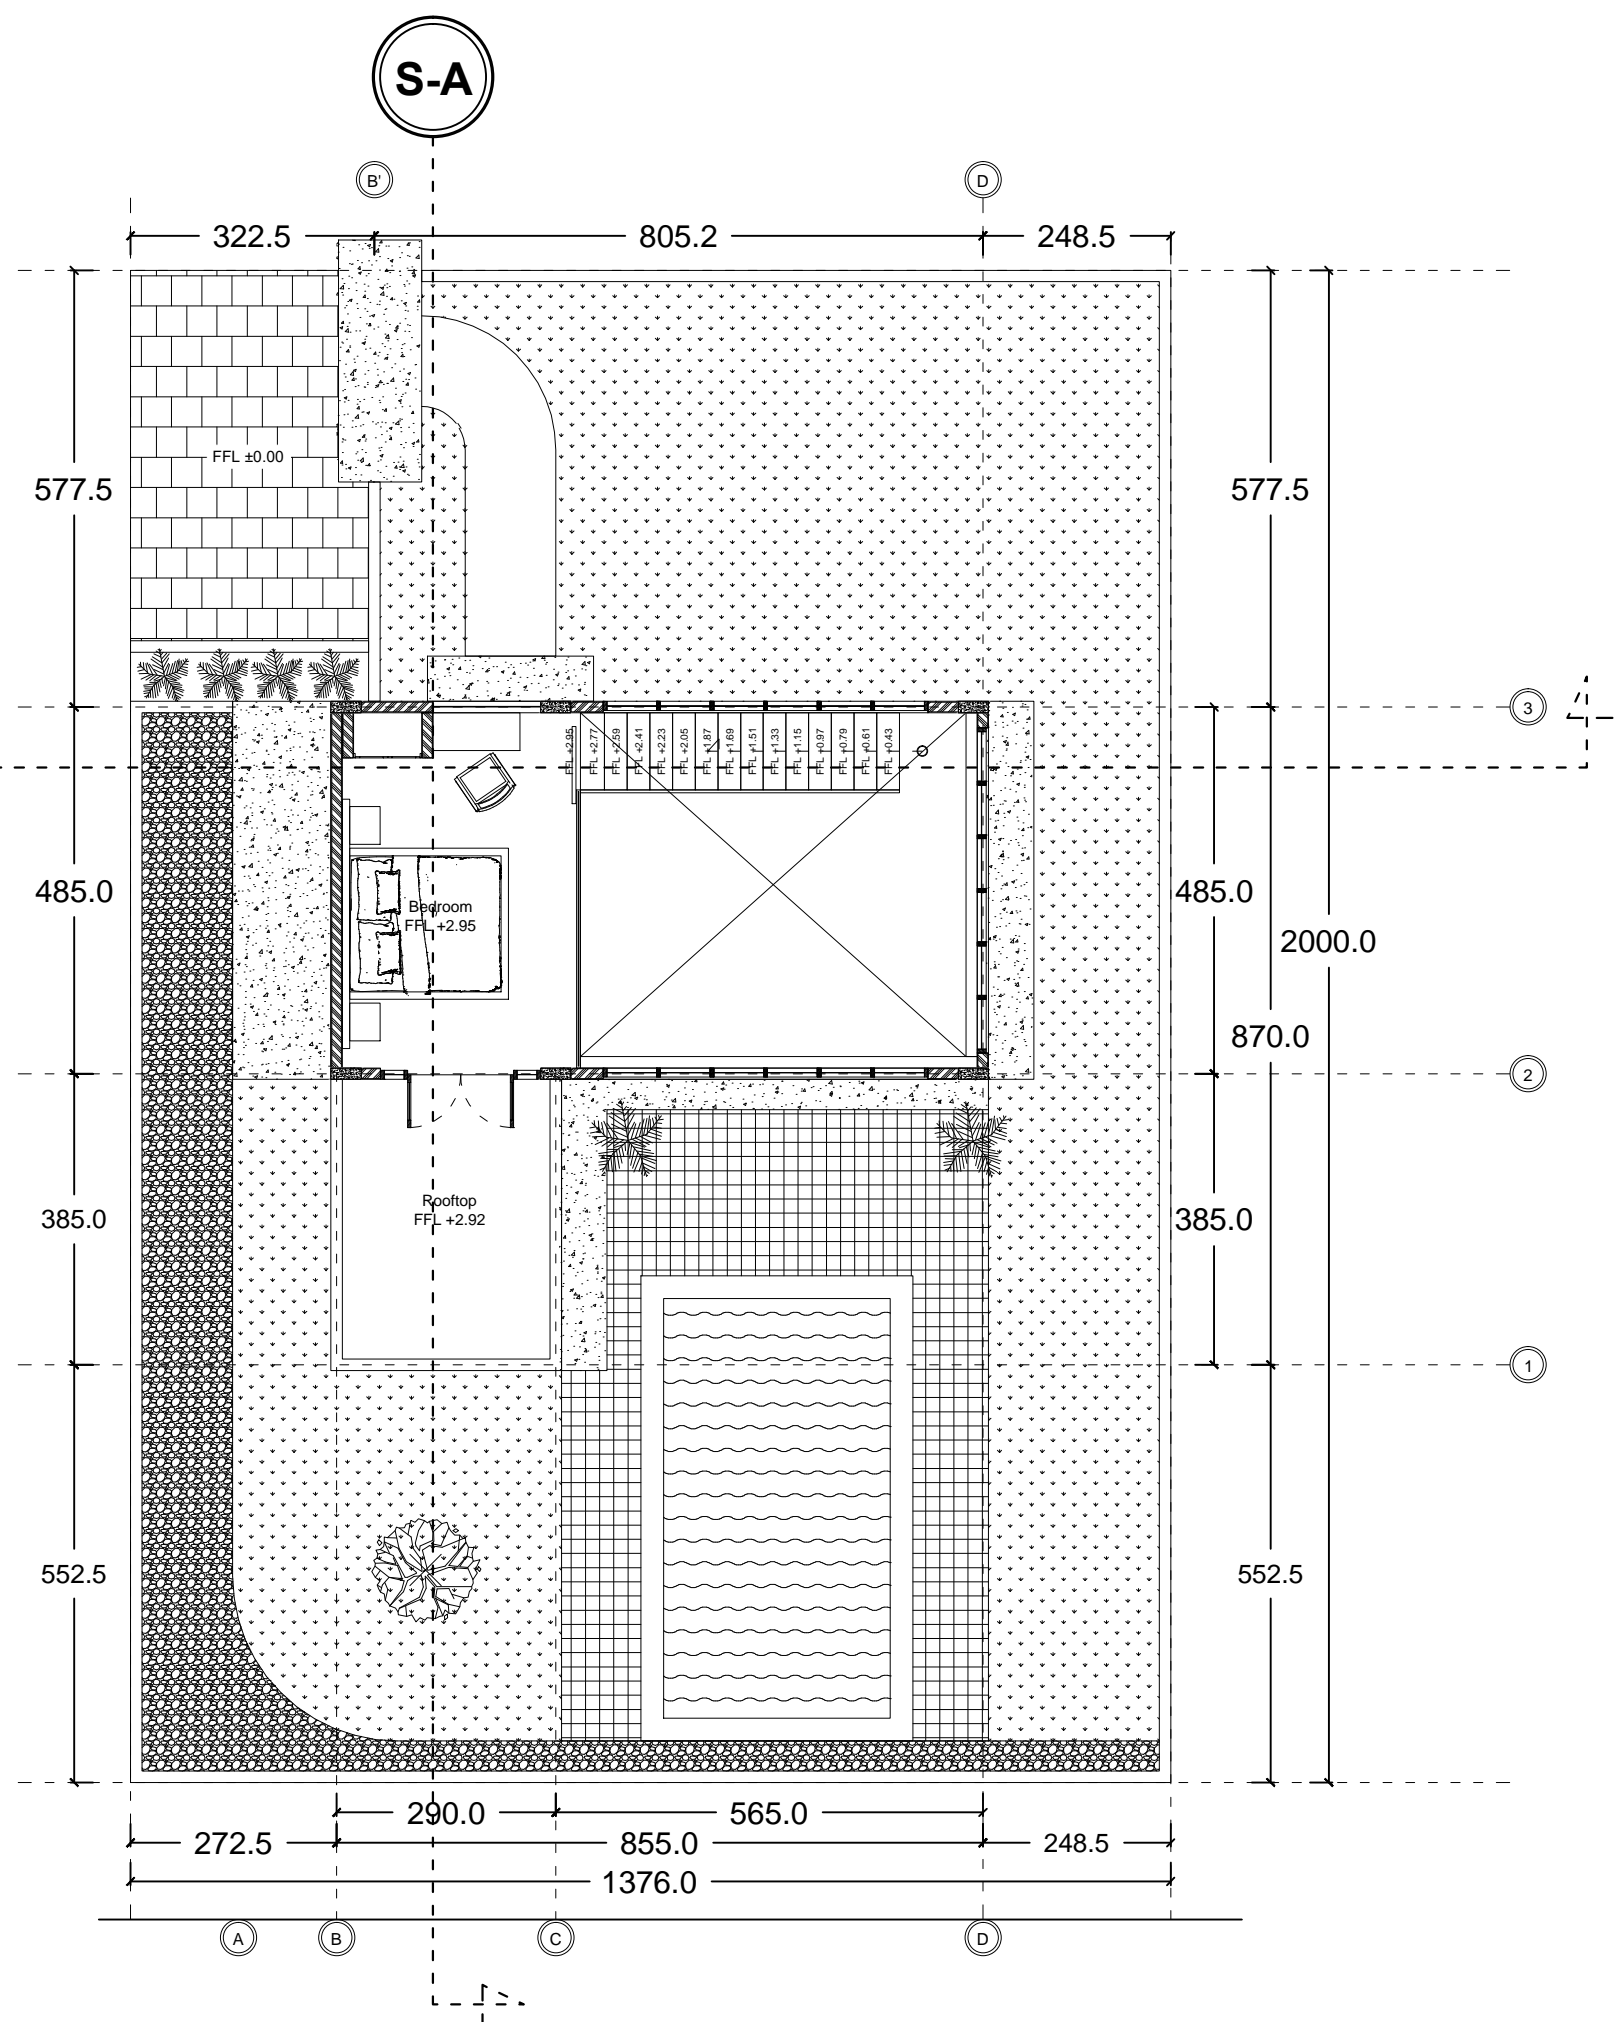


First Floor Mezzanine Villa
Scale 1:100





Front Side Elevation

Scale 1:100

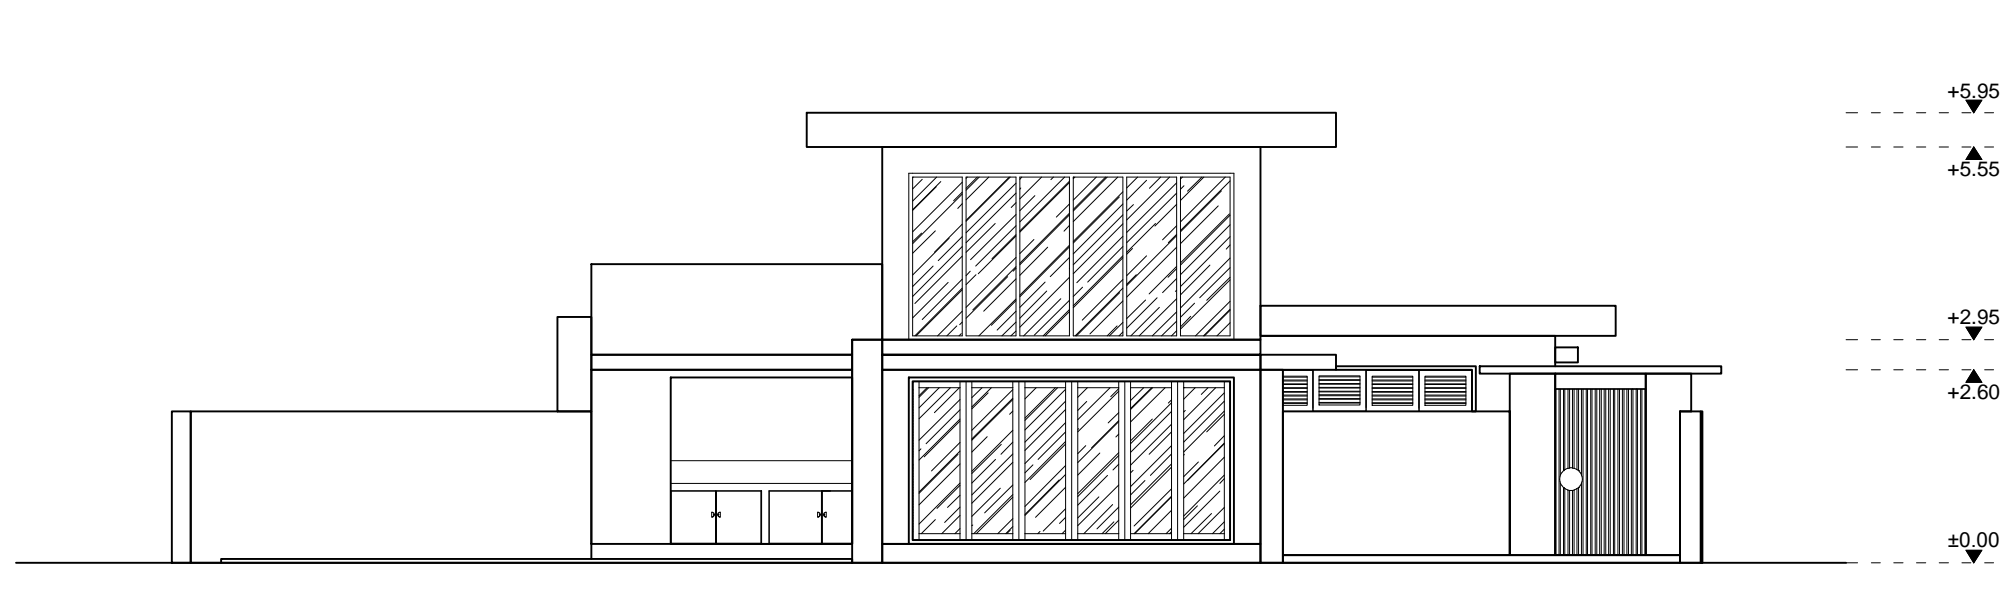

Left Side Elevation

Scale 1:100

SHOP DRAWING

Project :
Damien Villa

Owner :
Mr. Philippe

Approve by :

.....
.....

Costruction Management :
PT/CV.

Check by :

.....
.....

Costruction Contractor :
PT/CV

Approve by :

.....
.....

No	Revision	Date	Signed

Architect Consultant :

.....

Structure Consultant :

.....

Mechanical Consultant :

.....

Drawing Tittle :

Front Side Elevation & Right Side Elevation

Scale	Drawn	Guntur Kusuma
1 : 100	Check	Abdi
	Approved	Mr. Philippe

Issued for :	Code	Draw no
Design Development	139	005
Date	10.11.2022	

SHOP DRAWING

Project :
Damien Villa

Owner : 004
Mr. Philippe

Approve by :

Costruction Management :
PT/CV.

Check by :

Costruction Contractor :
PT/CV

Approve by :

No	Revision	Date	Signed

Architect Consultant :



Structure Consultant :

Mechanical Consultant :

Drawing Tittle :

Section A-A & B-B

Scale	Drawn	Guntur Kusuma
1 : 100	Check	Abdi
	Approved	Mr. Philippe
Issued for :	Code	Draw no
Design Development	139	006
Date	10.11.2022	

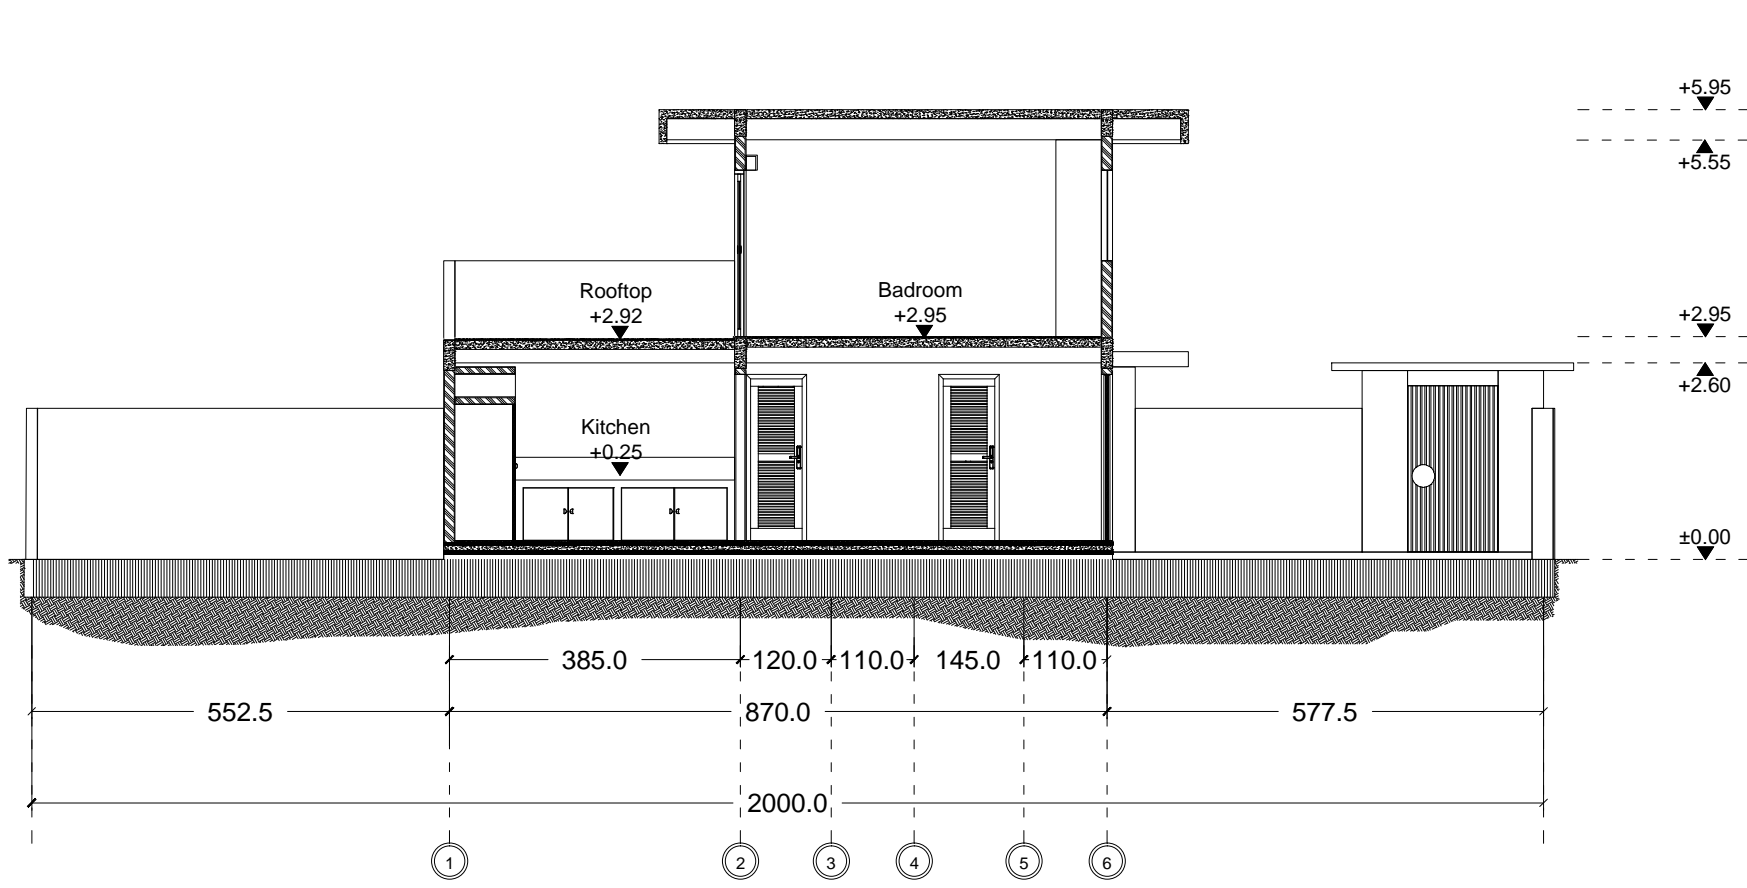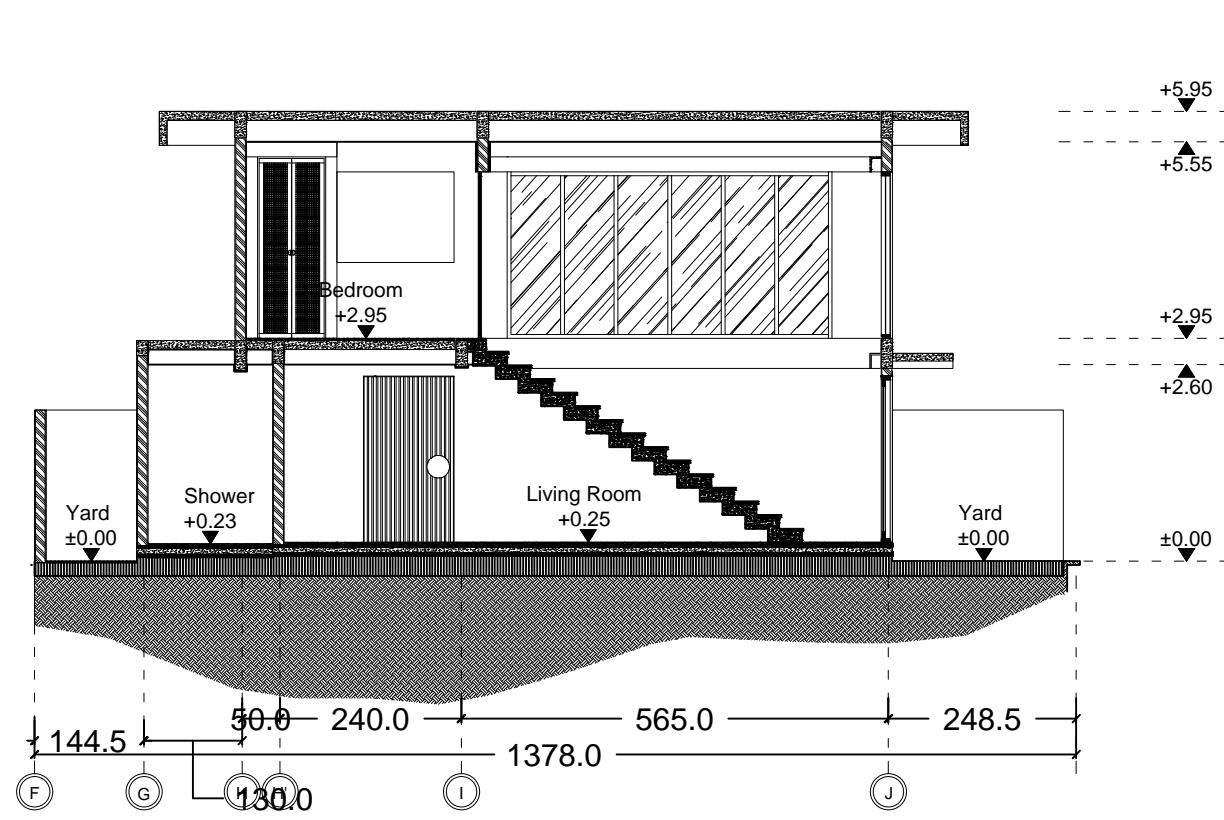

SHOP DRAWING

Project :
Damien Villa

Owner :
Mr. Philippe

Approve by :

.....
.....

Costruction Management :
PT/CV.

Check by :

.....
.....

Costruction Contractor :
PT/CV

Approve by :

.....
.....

No	Revision	Date	Signed

Architect Consultant :

.....

Structure Consultant :

.....


Mechanical Consultant :

.....

Drawing Tittle :

Door & Window Plan

Scale	Drawn	Guntur Kusuma
1 : 100	Check	Abdi
	Approved	Mr. Philippe
Issued for :	Code	Draw no
Design Development	139	007
Date	10.11.2022	

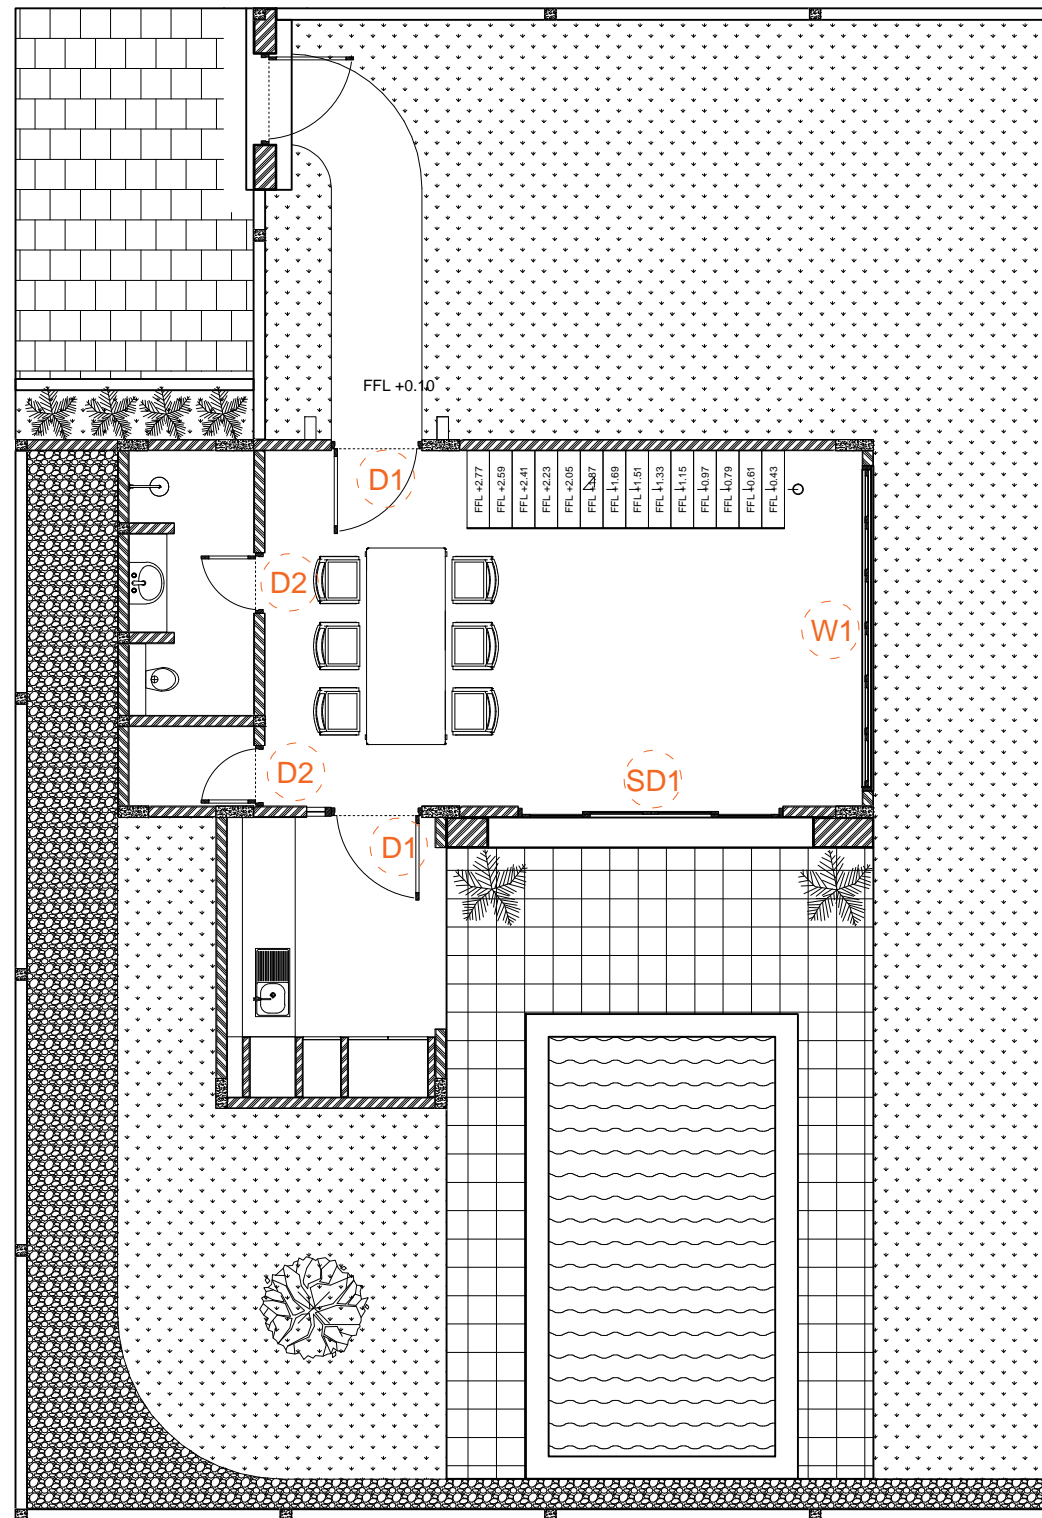

SHOP DRAWING

Project :
Damien Villa

Owner : 004
Mr. Philippe

Approve by :
.....
.....

Costruction Management :
PT/CV.

Check by :
.....
.....

Costruction Contractor :
PT/CV

Approve by :
.....
.....

No	Revision	Date	Signed

Architect Consultant :
.....


Structure Consultant :
.....

Mechanical Consultant :
.....




Drawing Tittle :

Door & Window Plan

Scale	Drawn	Guntur Kusuma
1 : 100	Check	Abdi
	Approved	Mr. Philippe
Issued for :	Code	Draw no
Design Development	139	008
Date	10.11.2022	

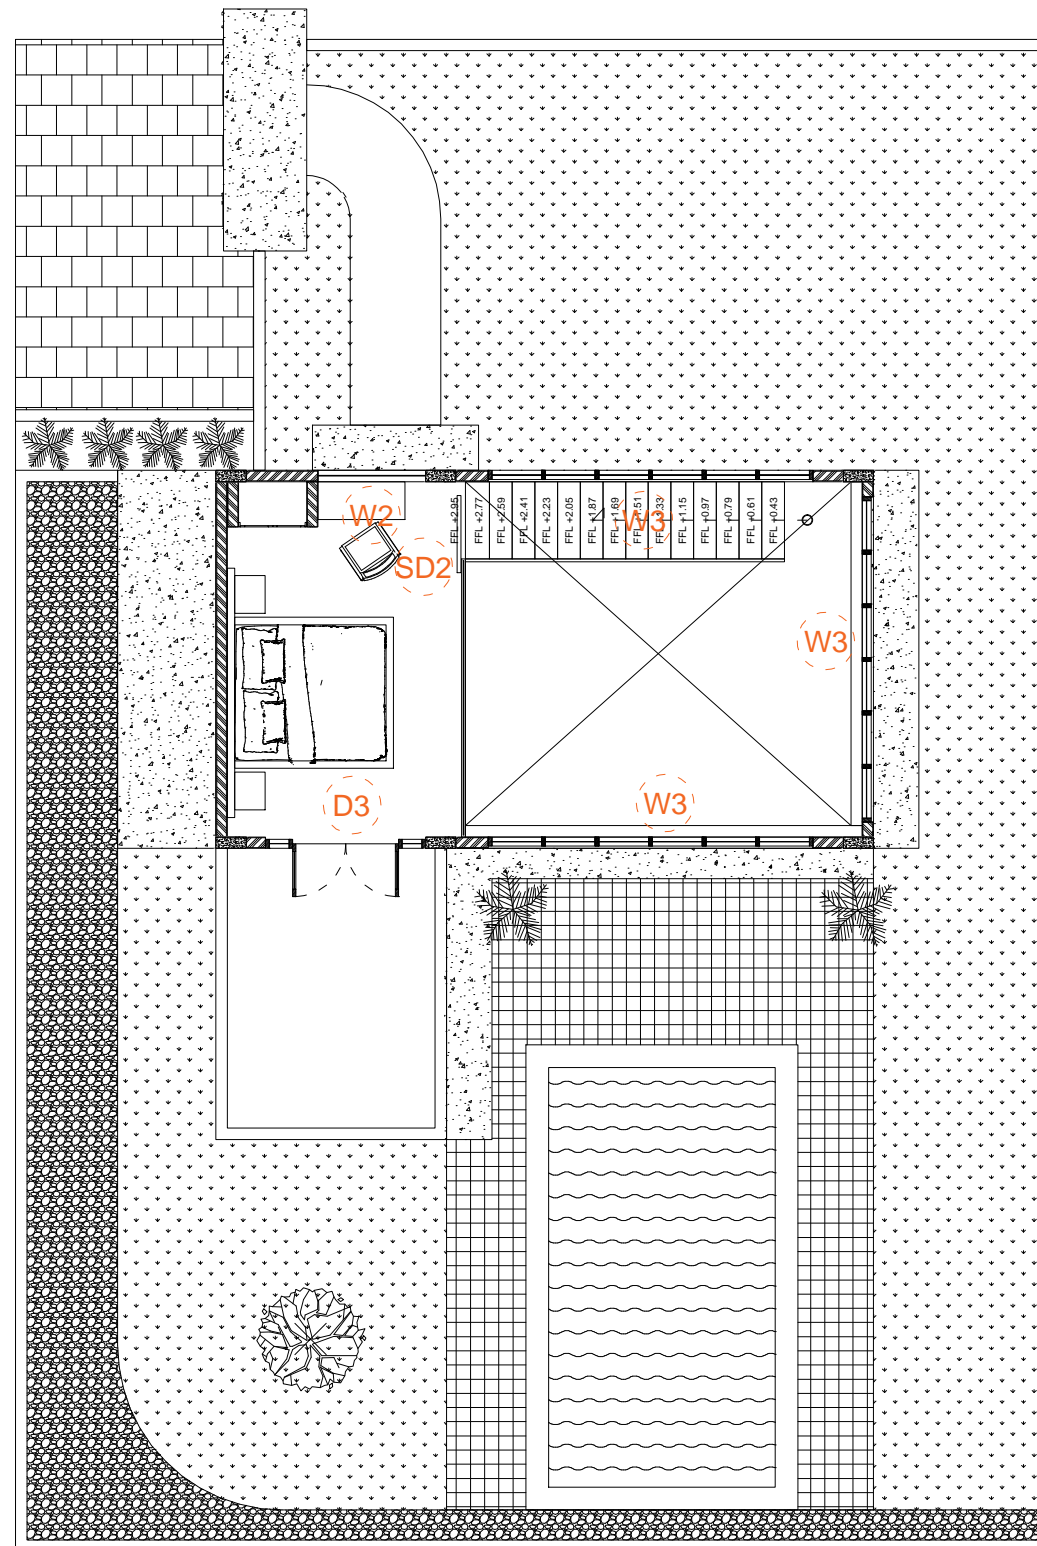

Type	D1
Quantity	2

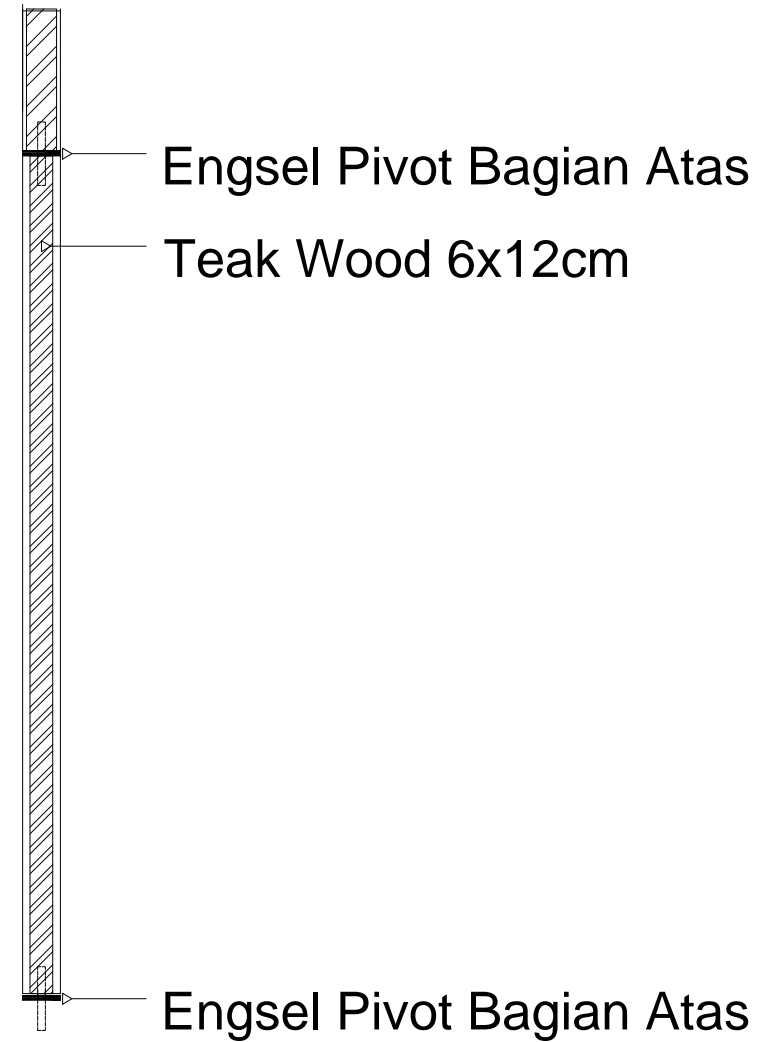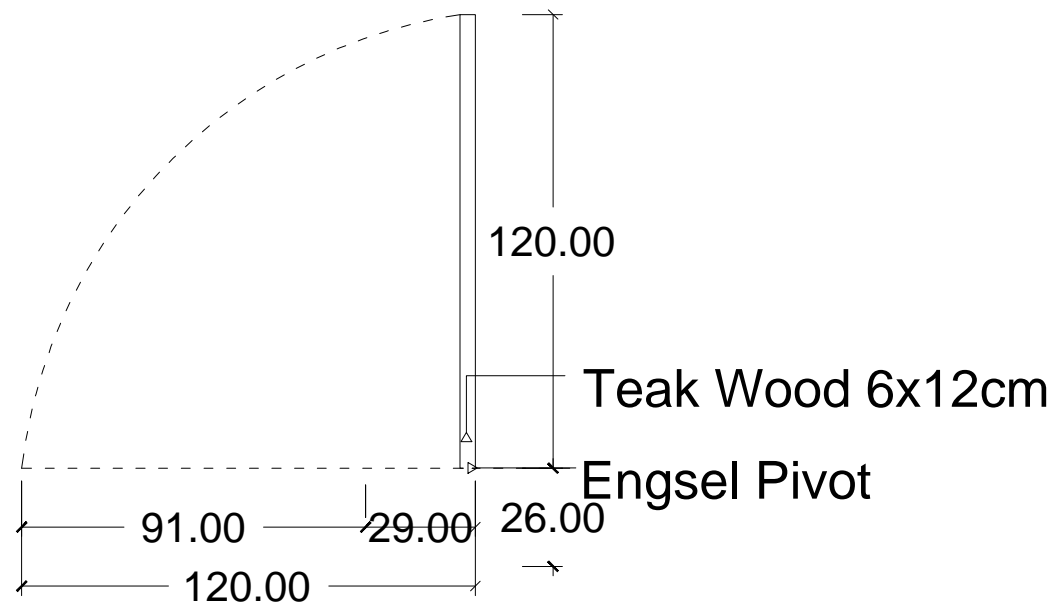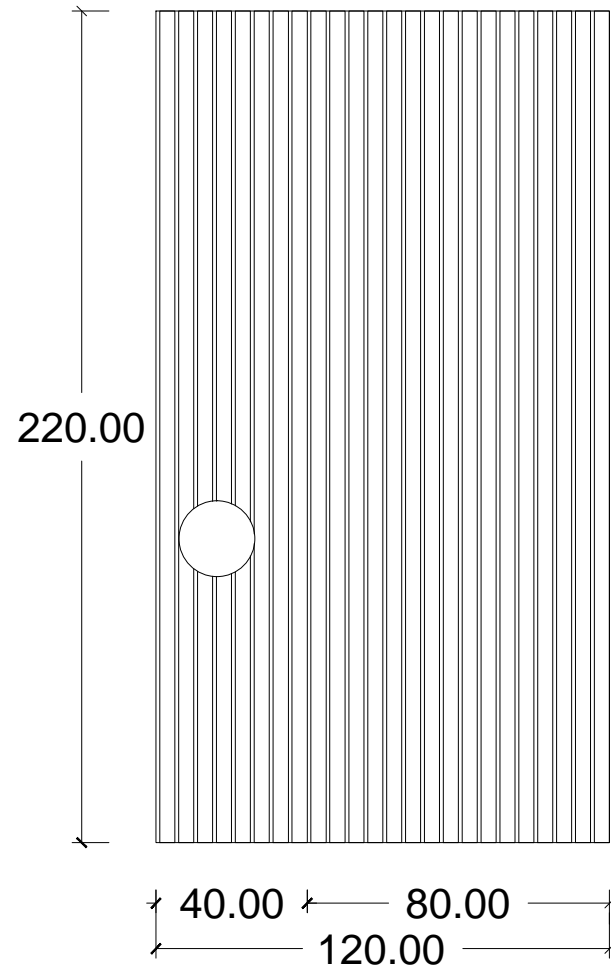

SHOP DRAWING

Project :
Damien Villa

Owner :
Mr. Philippe

Approve by :
.....
.....

Costruction Management :
PT/CV.

Check by :
.....
.....

Costruction Contractor :
PT/CV

Approve by :
.....
.....

No	Revision	Date	Signed

Architect Consultant :
.....

Structure Consultant :
.....

Mechanical Consultant :
.....

Drawing Tittle :




Door Detail

Scale	Drawn	Guntur Kusuma
1 : 20	Check	Abdi
	Approved	Mr. Philippe

Issued for : Code Draw no

Design Development	139	009
Date 10.11.2022		

Type	D2
Quantity	2

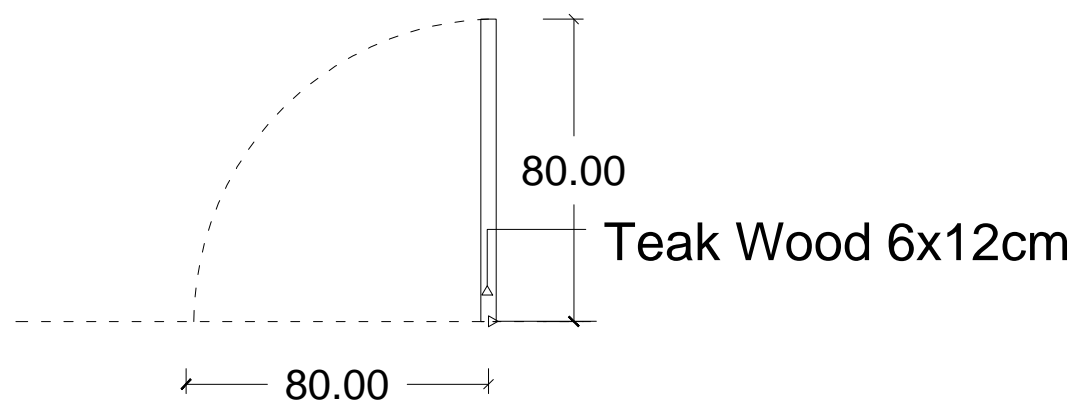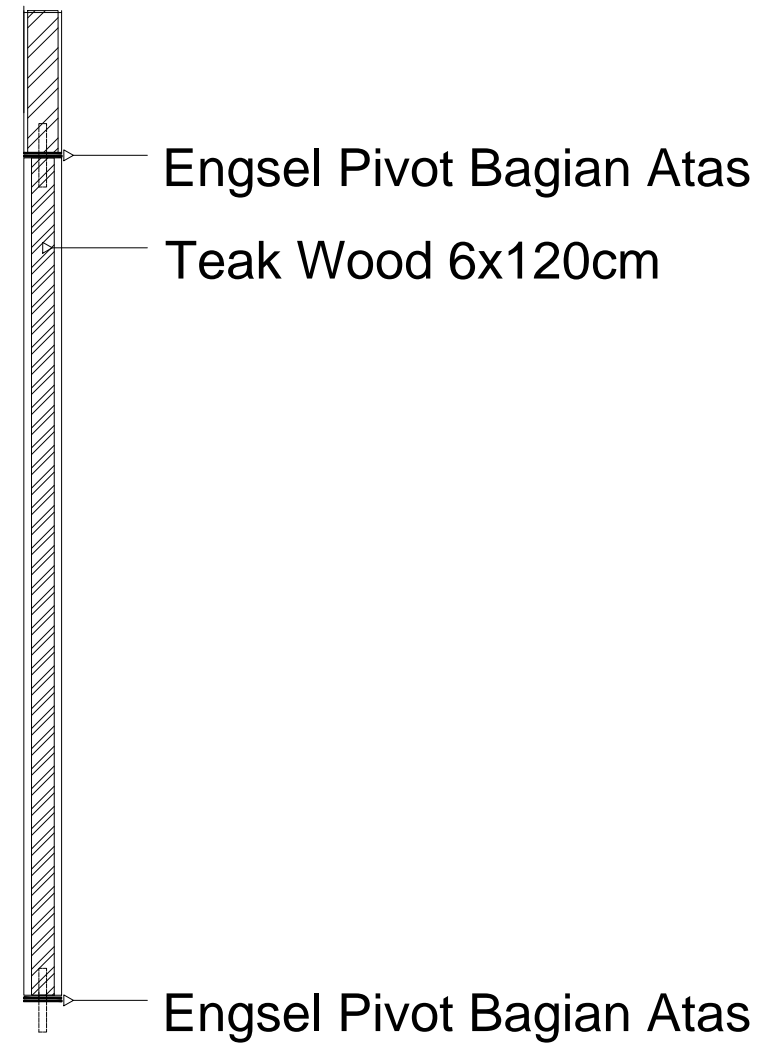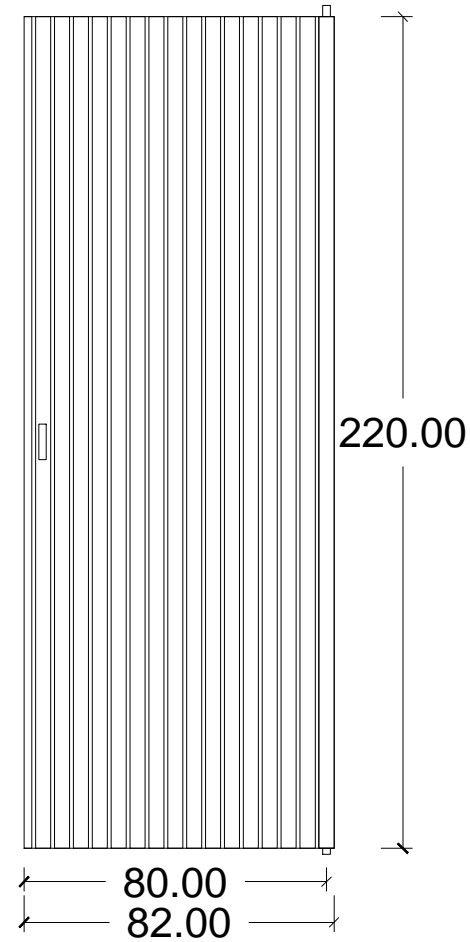

SHOP DRAWING

Project :
Damien Villa

Owner :
Mr. Philippe

Approve by :

.....
.....

Costruction Management :
PT/CV.

Check by :

.....
.....

Costruction Contractor :
PT/CV

Approve by :

.....
.....

No	Revision	Date	Signed

Architect Consultant :

.....

Structure Consultant :

.....

Mechanical Consultant :

.....

Drawing Tittle :


Door Detail

Scale	Drawn	Guntur Kusuma
1 : 20	Check	Abdi
	Approved	Mr. Philippe


Issued for : Code Draw no

Design Development	139	010
Date	10.11.2022	


Type	D3
Quantity	1

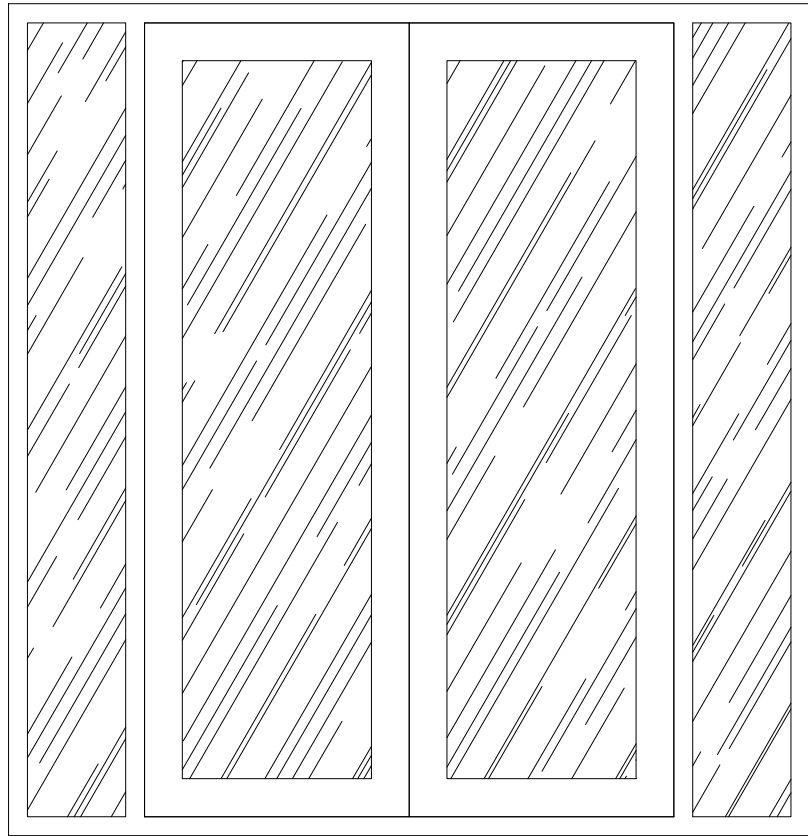

26.00 132.00 26.00
36.00 140.00 36.00

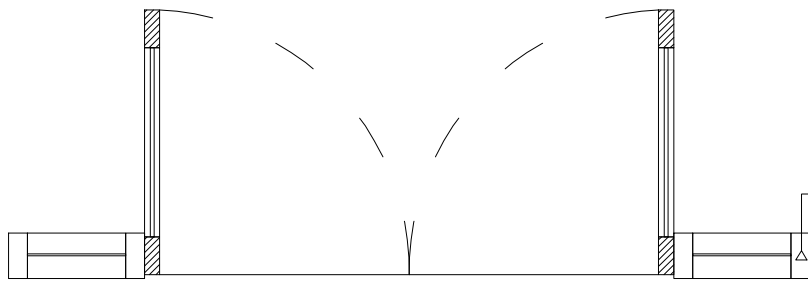

26.00 132.00 26.00
36.00 140.00 36.00

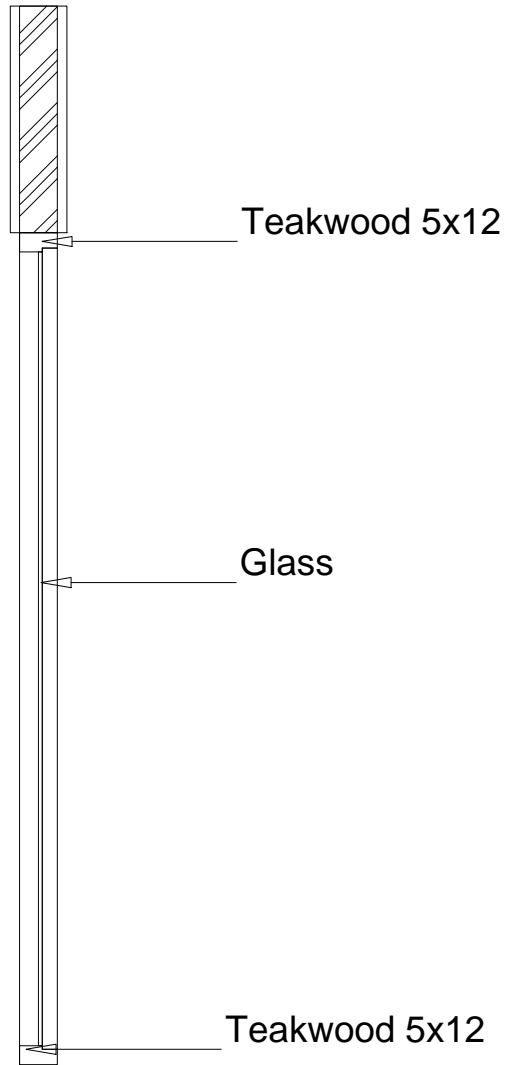

Teakwood 5x12

Glass

Teakwood 5x12

SHOP DRAWING

Project :
Damien Villa

Owner :
Mr. Philippe

Approve by :

.....
.....

Costruction Management :
PT/CV.

Check by :

.....
.....

Costruction Contractor :
PT/CV

Approve by :

.....
.....

No	Revision	Date	Signed

Architect Consultant :

.....

Structure Consultant :

.....

Mechanical Consultant :




.....

Drawing Tittle :

Door Detail

Scale	Drawn	Guntur Kusuma
1 : 20	Check	Abdi
	Approved	Mr. Philippe
Issued for :	Code	Draw no
Design Development	139	011
Date	10.11.2022	

Type	SD1
Quantity	1

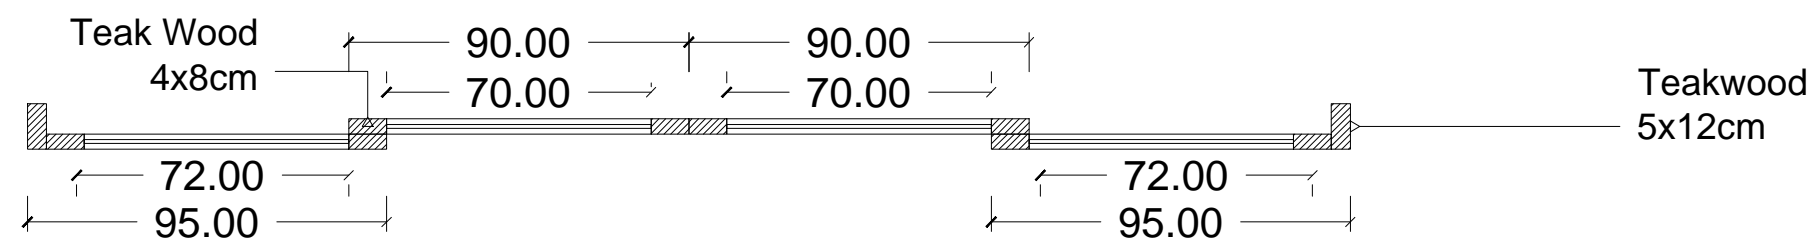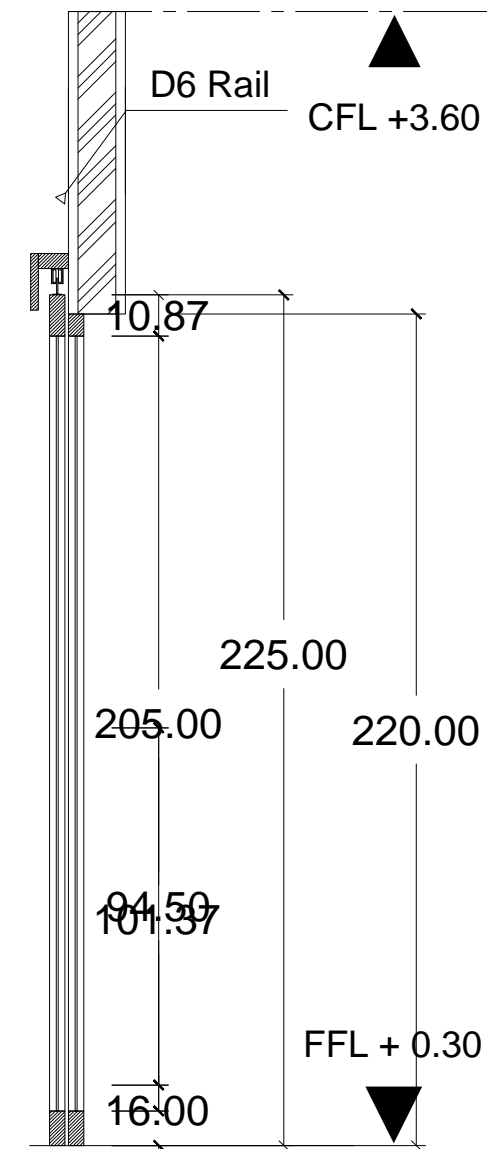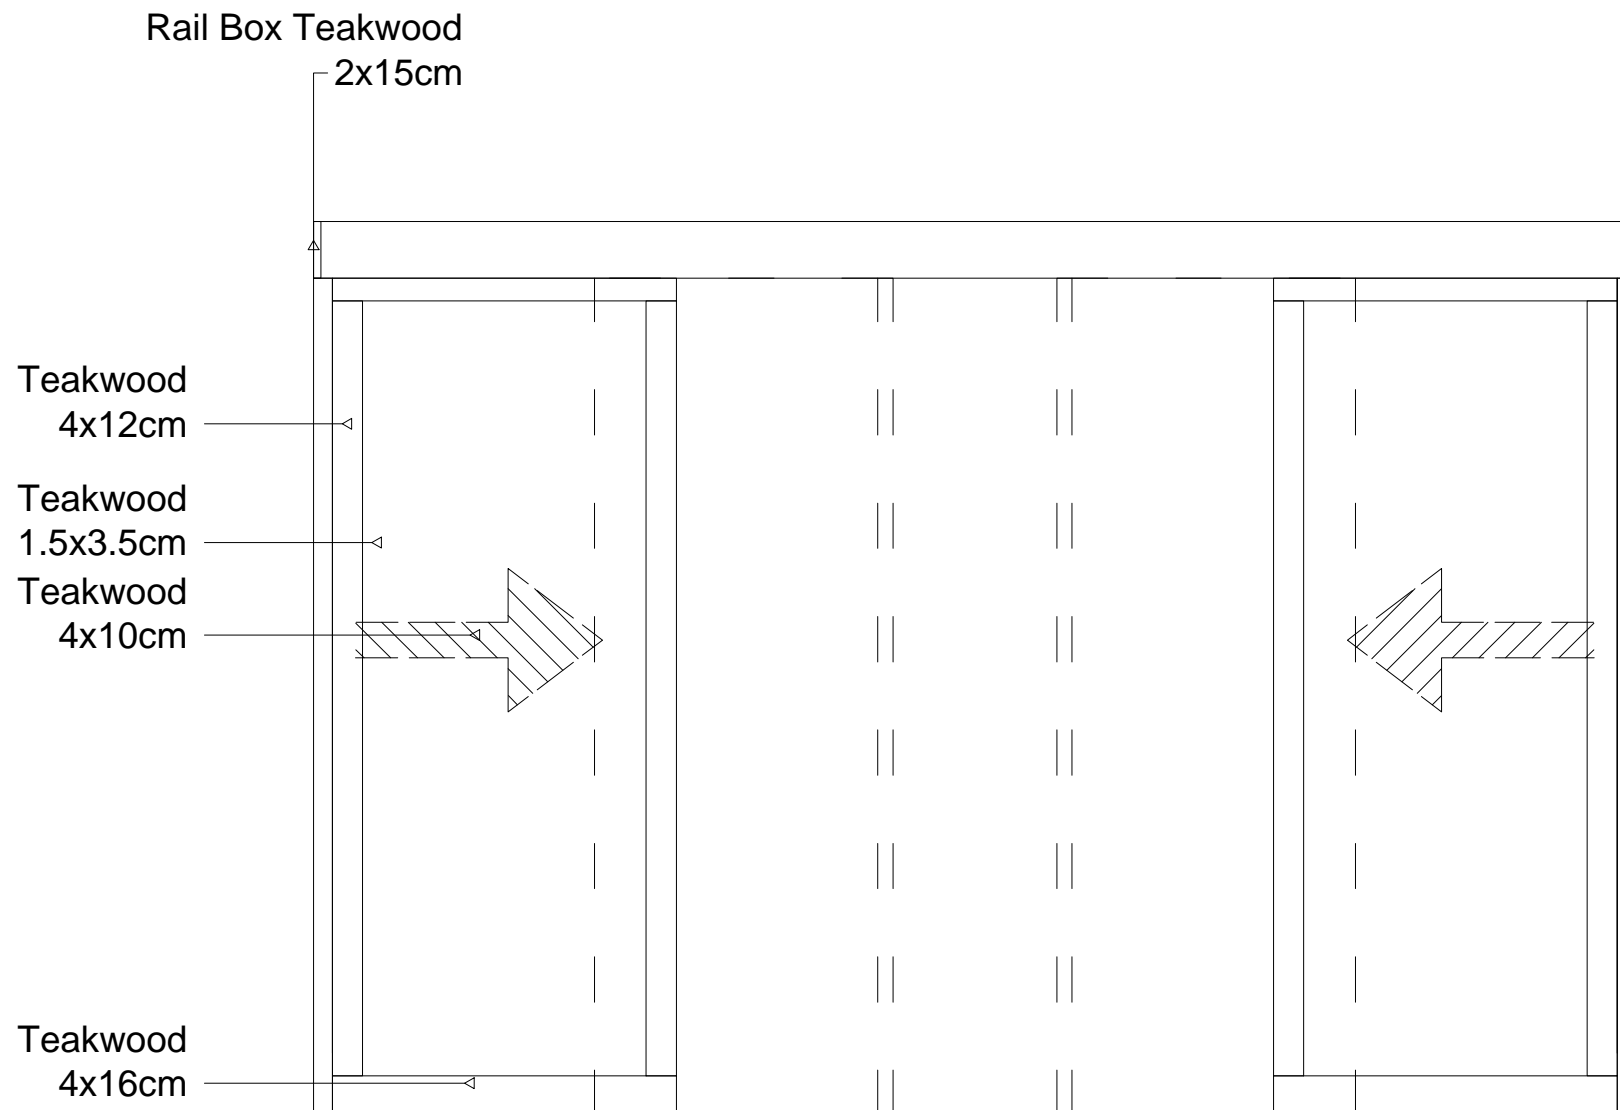

SHOP DRAWING

Project :
Damien Villa

Owner :
Mr. Philippe

Approve by :

.....
.....

Costruction Management :
PT/CV.

Check by :

.....
.....

Costruction Contractor :
PT/CV

Approve by :

.....
.....

No	Revision	Date	Signed

Architect Consultant :

.....

Structure Consultant :

.....

Mechanical Consultant :

.....




Drawing Tittle :

Door Detail

Scale	Drawn	Guntur Kusuma
1 : 20	Check	Abdi
	Approved	Mr. Philippe
Issued for :		Code Draw no
Design Development		139 012
Date	10.11.2022	



Type	SD2
Quantity	1

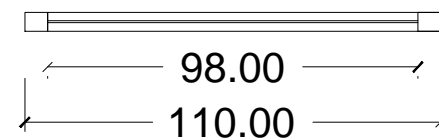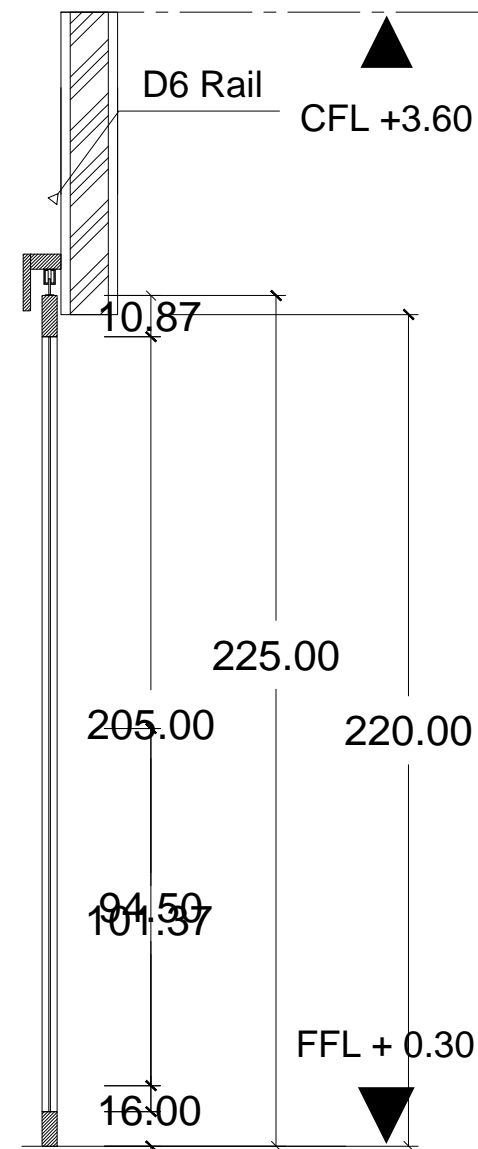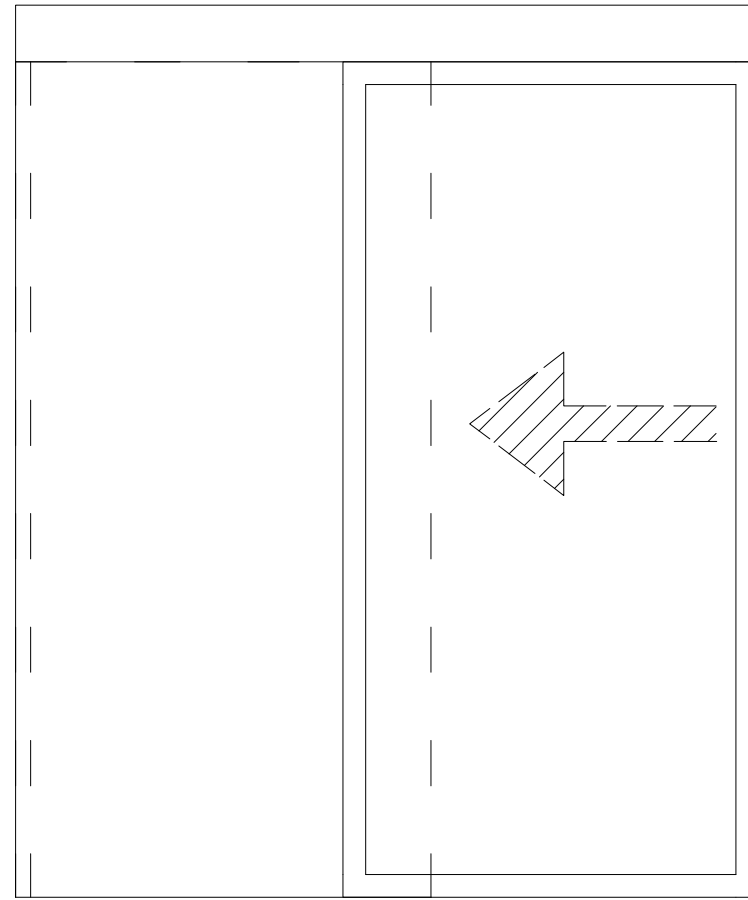

SHOP DRAWING

Project :
Damien Villa

Owner :
Mr. Philippe

Approve by :
.....
.....

Costruction Management :
PT/CV.

Check by :
.....
.....

Costruction Contractor :
PT/CV

Approve by :
.....
.....

No	Revision	Date	Signed

Architect Consultant :
.....




Structure Consultant :
.....

Mechanical Consultant :
.....

Drawing Tittle :
Door Detail

Scale	Drawn	Guntur Kusuma
1 : 20	Check	Abdi
	Approved	Mr. Philippe
Issued for :		Code Draw no
Design Development		139 013
Date	10.11.2022	

Type	W1
Quantity	1

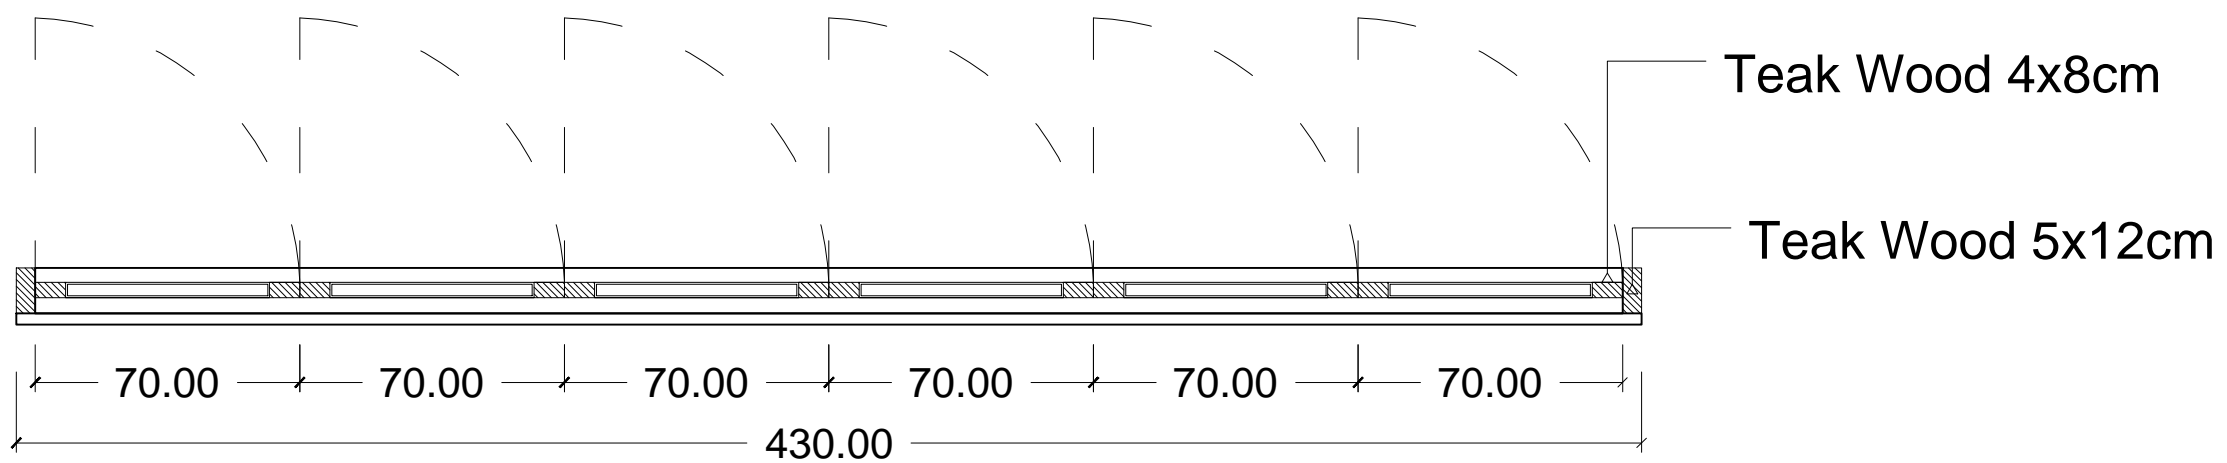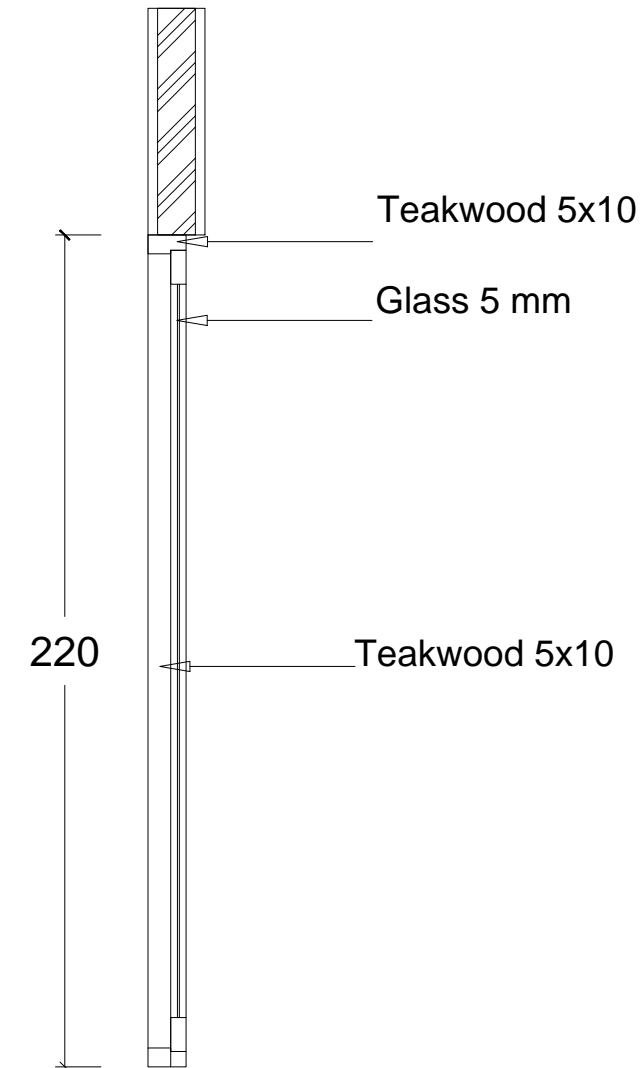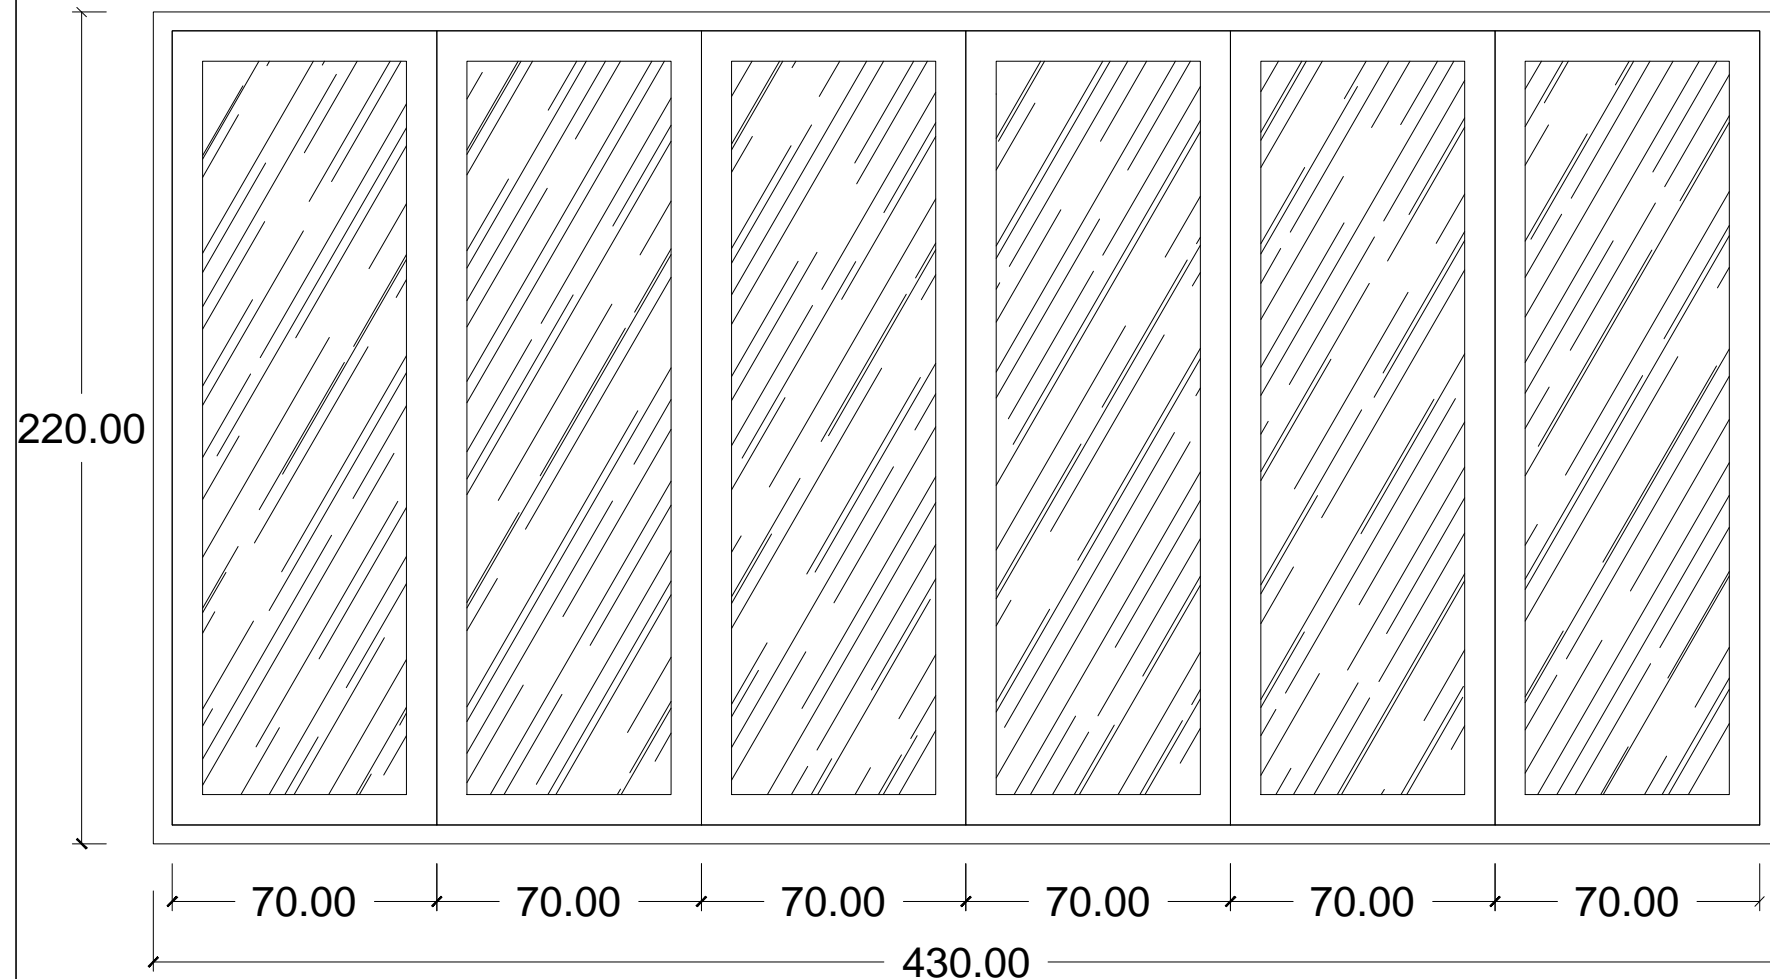

SHOP DRAWING

Project :
Damien Villa

Owner :
Mr. Philippe

Approve by :

.....
.....

Costruction Management :
PT/CV.

Check by :

.....
.....

Costruction Contractor :
PT/CV

Approve by :

.....
.....

No	Revision	Date	Signed

Architect Consultant :

.....

Structure Consultant :

.....

Mechanical Consultant :

.....

Drawing Tittle :

Window Detail

Scale	Drawn	Guntur Kusuma
1 : 20	Check	Abdi
	Approved	Mr. Philippe

Issued for : Code Draw no

Design Development	139	014
Date	10.11.2022	



SHOP DRAWING

Project :
Damien Villa

Owner :
Mr. Philippe

Approve by :

.....
.....

Costruction Management :
PT/CV.

Check by :

.....
.....

Costruction Contractor :
PT/CV

Approve by :

.....
.....

No	Revision	Date	Signed

Architect Consultant :

.....

Structure Consultant :

.....


Mechanical Consultant :

.....

Drawing Tittle :

Window Detail

Scale	Drawn	Guntur Kusuma	
1 : 20	Check	Abdi	
	Approved	Mr. Philippe	
Issued for :		Code	Draw no
Design Development		139	015
Date	10.11.2022		

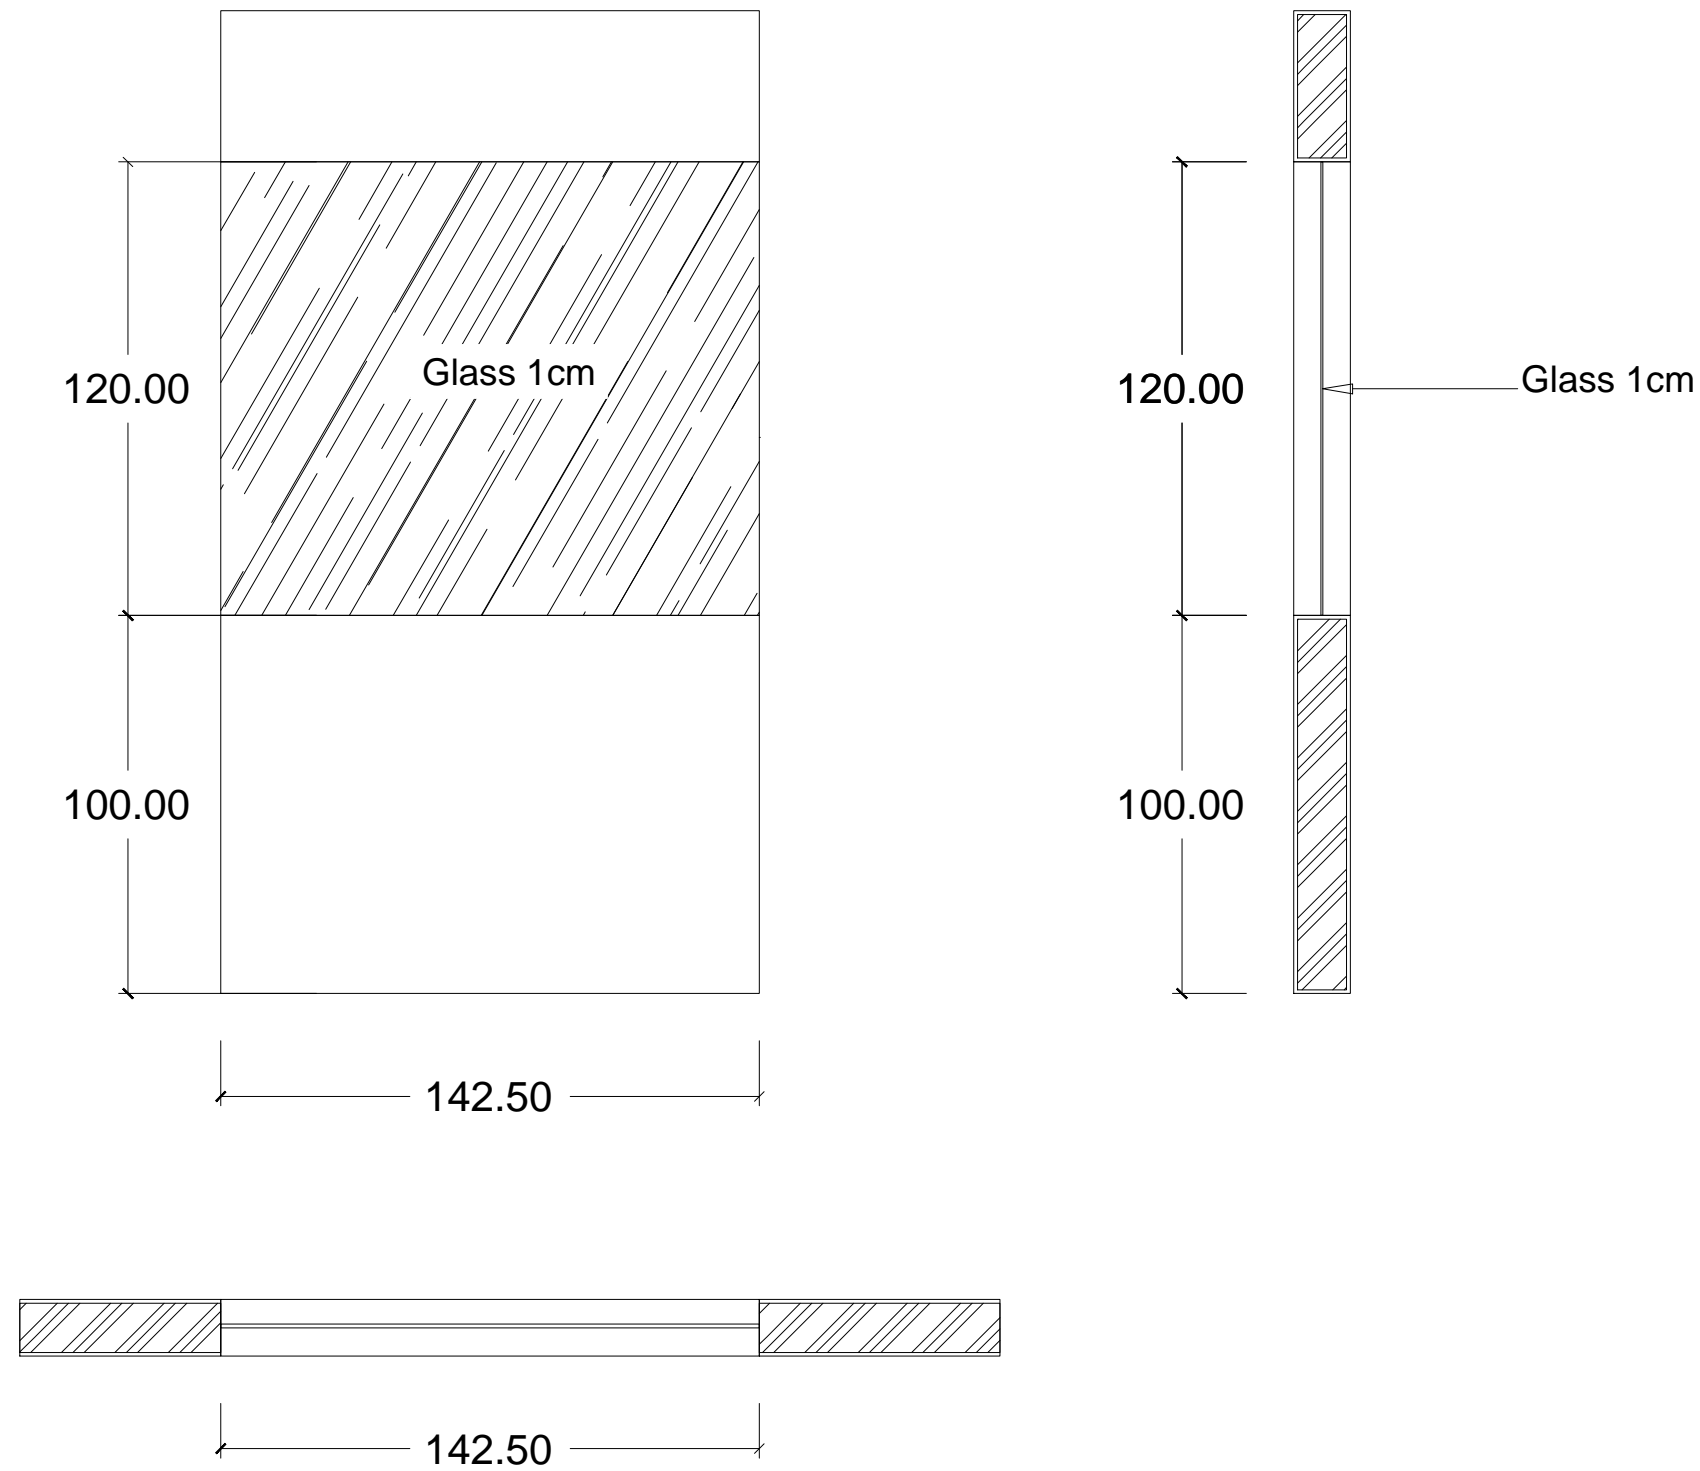

SHOP DRAWING

Project :
Damien Villa

Owner :
Mr. Philippe

Approve by :

.....
.....

Costruction Management :
PT/CV.

Check by :

.....
.....

Costruction Contractor :
PT/CV

Approve by :

.....
.....

No	Revision	Date	Signed

Architect Consultant :

.....

Structure Consultant :

.....


Mechanical Consultant :

.....

Drawing Tittle :

Window Detail

Scale	Drawn	Guntur Kusuma
1 : 20	Check	Abdi
	Approved	Mr. Philippe
Issued for :		Code
Design Development		139
		016
Date	10.11.2022	

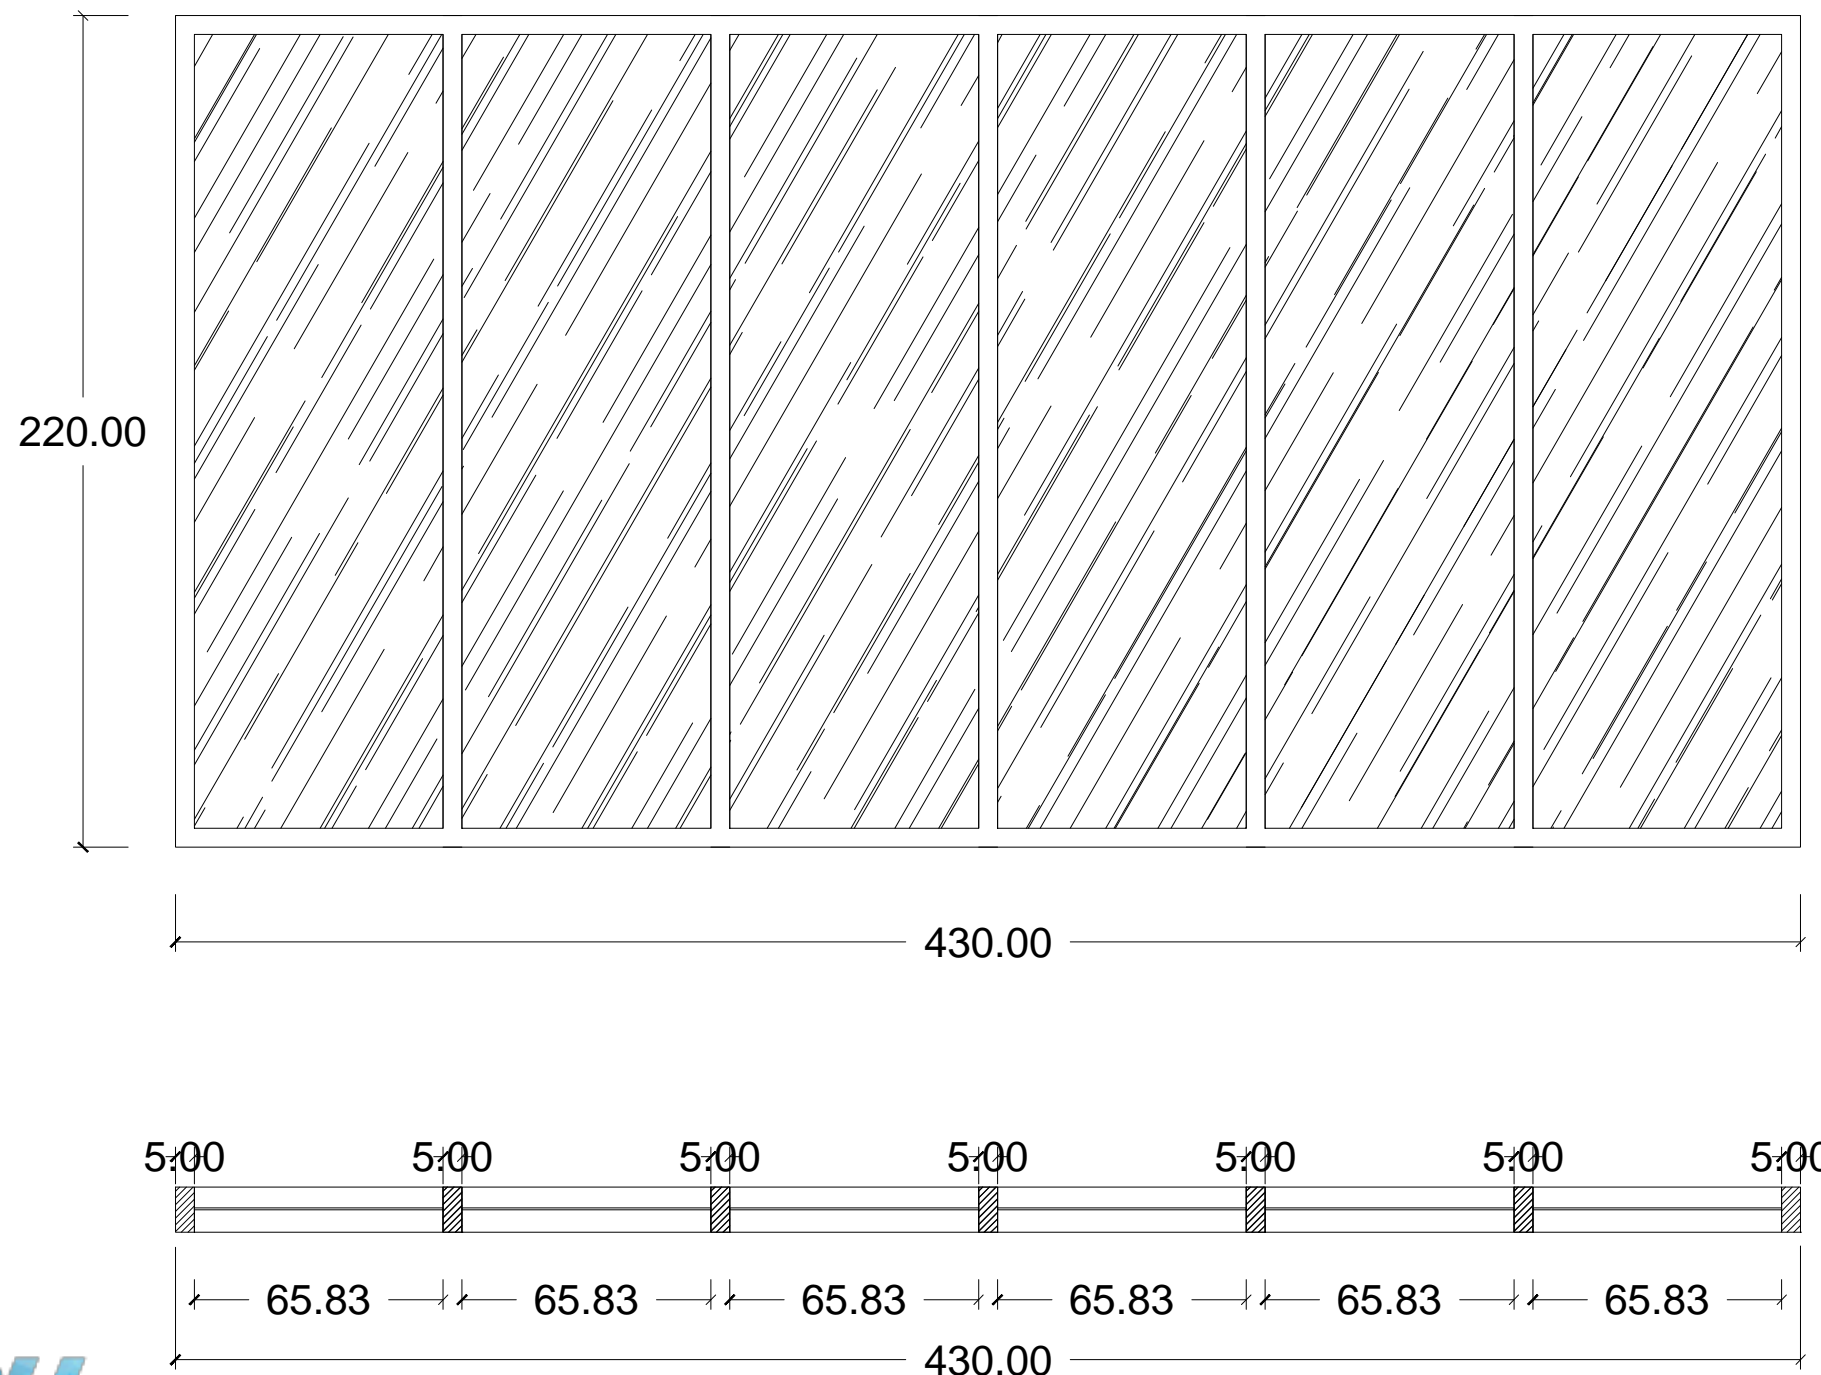

SHOP DRAWING

Project :
Damien Villa

Owner :
Mr. Philippe

Approve by :
.....
.....

Costruction Management :
PT/CV.

Check by :
.....
.....

Costruction Contractor :
PT/CV

Approve by :
.....
.....

No	Revision	Date	Signed

Architect Consultant :
.....

Structure Consultant :
.....

Mechanical Consultant :
.....

Drawing Tittle :


Floor Finished

Scale	Drawn	Guntur Kusuma
1 : 100	Check	Abdi
	Approved	Mr. Philippe

Issued for : Code Draw no

Design Development 139 017

Date 10.11.2022

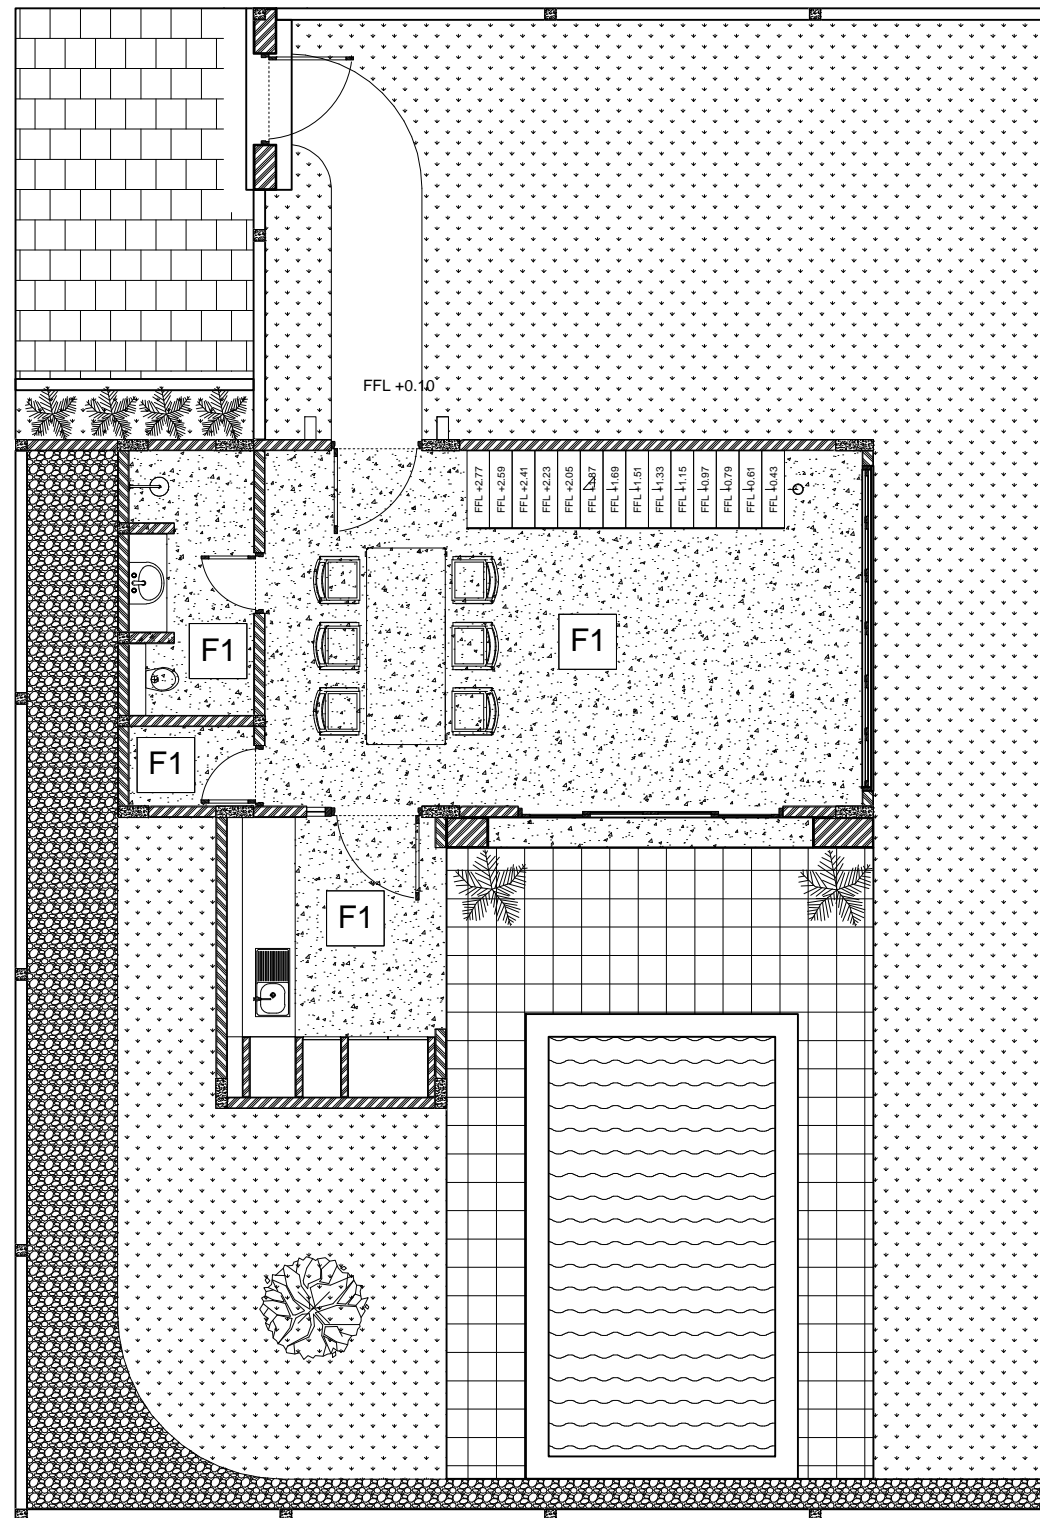

Floor Finished

F1 Terraso



SHOP DRAWING

Project :
Damien Villa

Owner : 004
Mr. Philippe

Approve by :
.....
.....

Costruction Management :
PT/CV.

Check by :
.....
.....

Costruction Contractor :
PT/CV

Approve by :
.....
.....

No	Revision	Date	Signed

Architect Consultant :
.....

Structure Consultant :
.....

Mechanical Consultant :
.....

Drawing Tittle :


Floor Finished

Scale	Drawn	Guntur Kusuma
1 : 100	Check	Abdi
	Approved	Mr. Philippe

Issued for : Code Draw no

Design Development 139 018

Date 10.11.2022

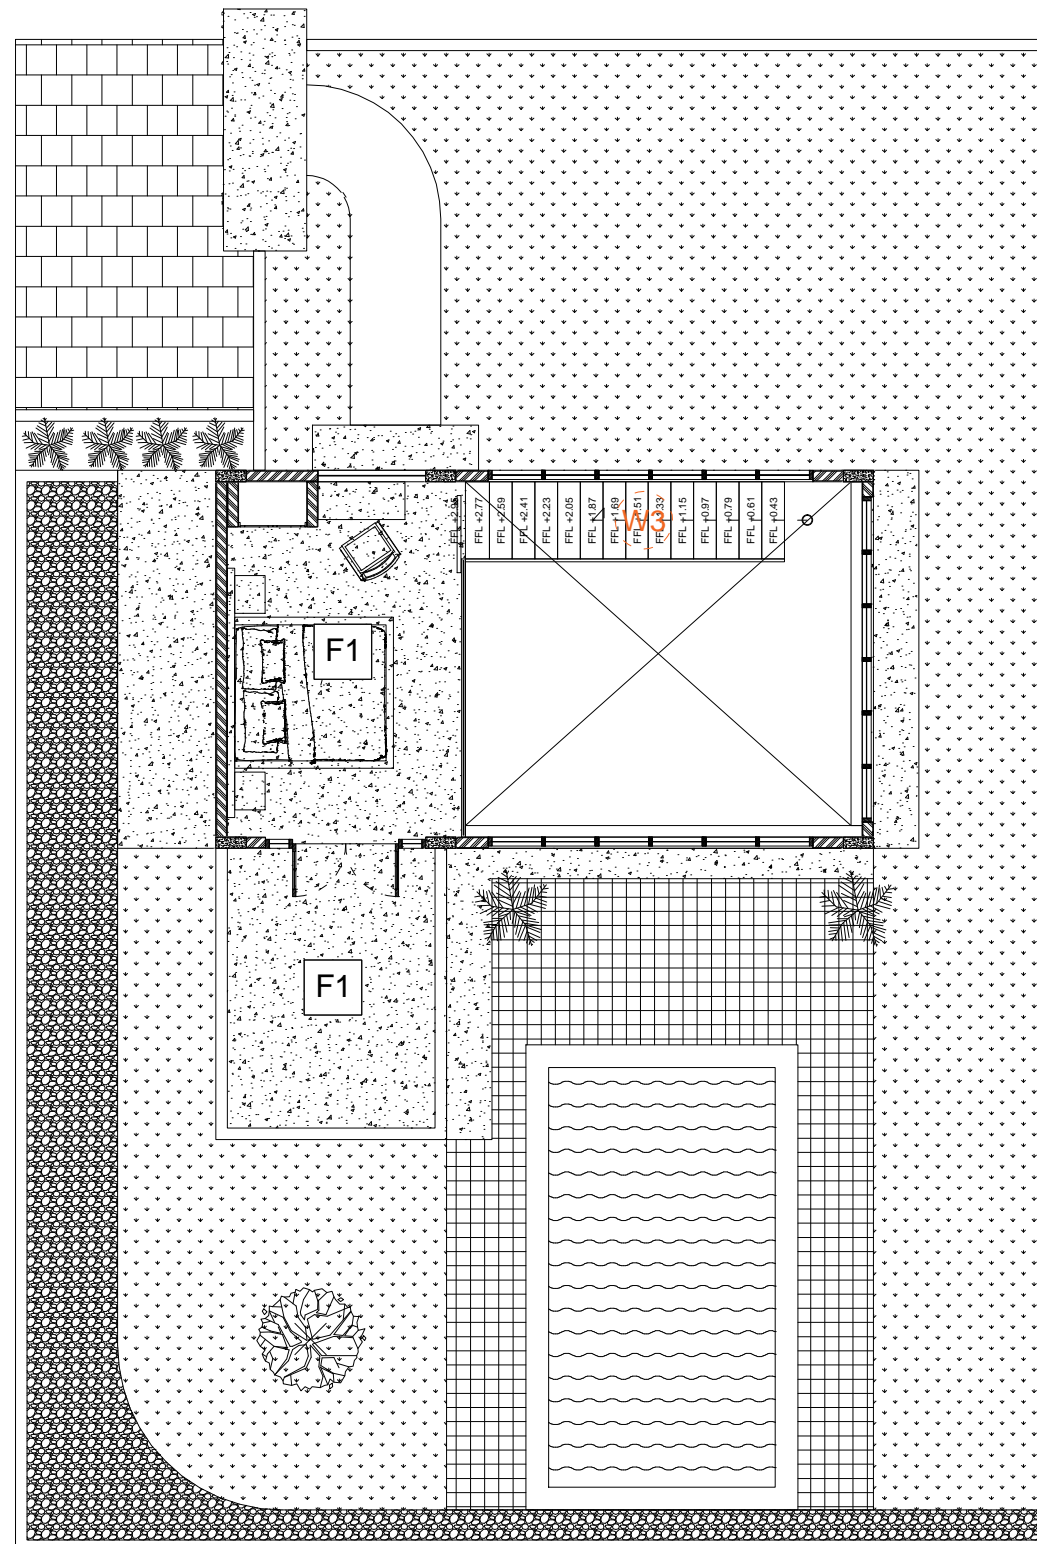

Floor Finished

F1 Terraso



SHOP DRAWING

Project :
Damien Villa

Owner :
Mr. Philippe

Approve by :
.....
.....

Costruction Management :
PT/CV.

Check by :
.....
.....

Costruction Contractor :
PT/CV

Approve by :
.....
.....

No	Revision	Date	Signed

Architect Consultant :
.....


Structure Consultant :
.....

Mechanical Consultant :
.....

Drawing Tittle :

Ceiling Plan

Scale	Drawn	Guntur Kusuma
1 : 100	Check	Abdi
	Approved	Mr. Philippe
Issued for :	Code	Draw no
Design Development	139	019
Date	10.11.2022	

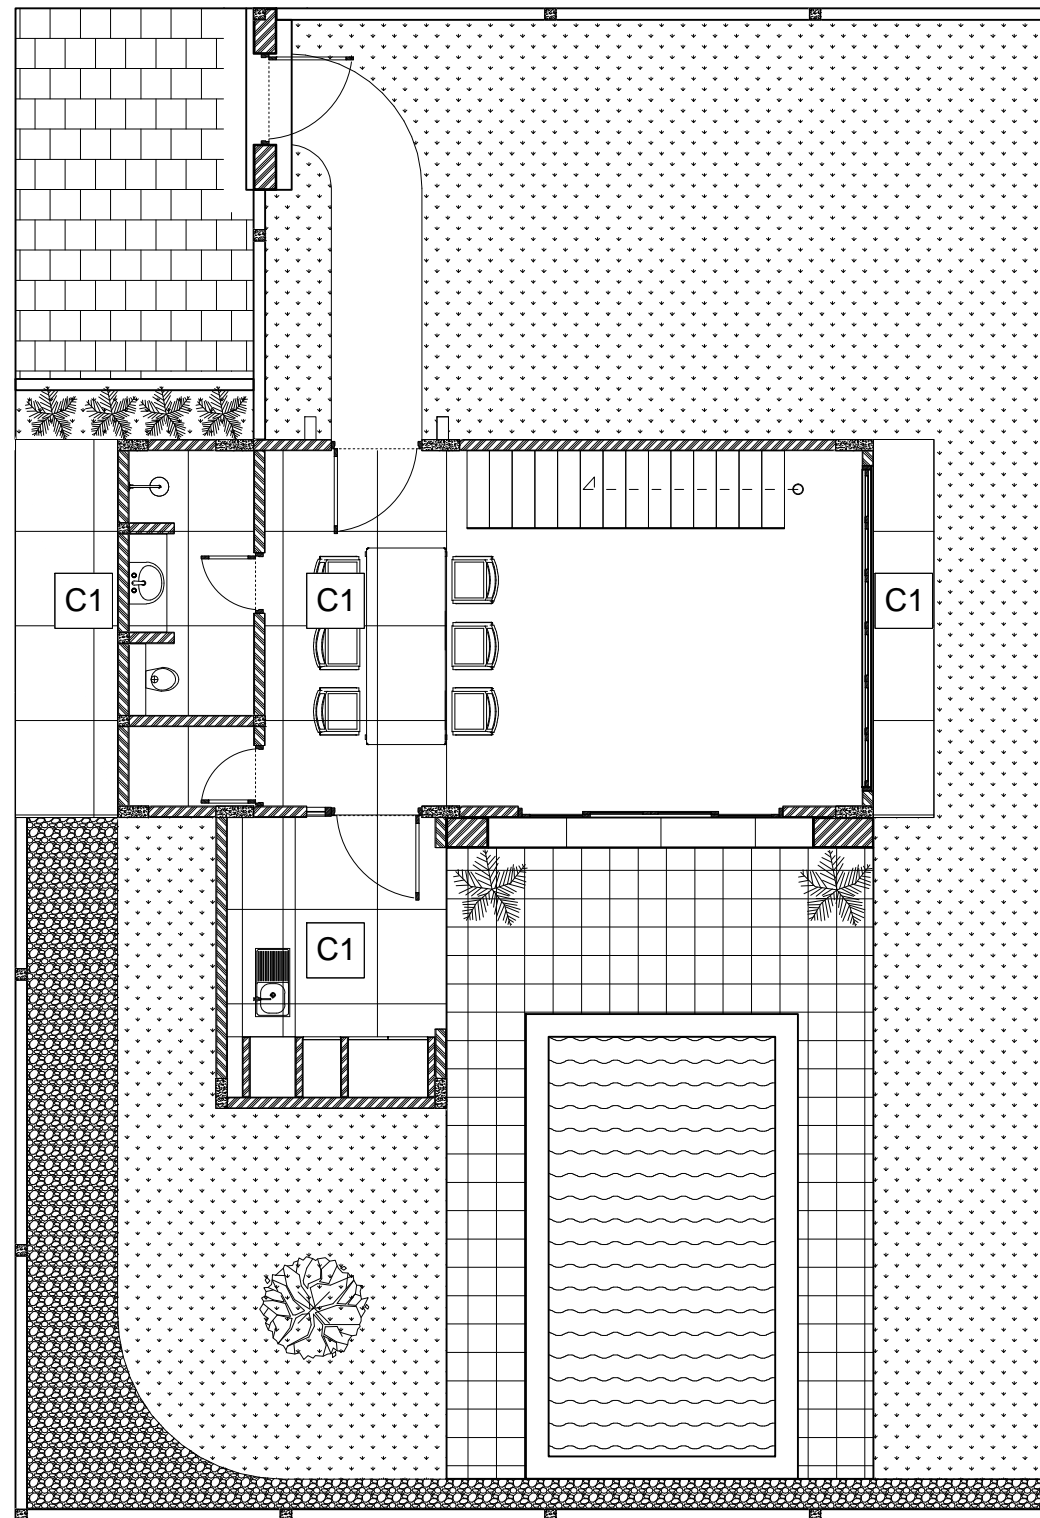

Floor Finished

F1 Terraso



SHOP DRAWING

Project :
Damien Villa

Owner : 004
Mr. Philippe

Approve by :
.....
.....

Costruction Management :
PT/CV.

Check by :
.....
.....

Costruction Contractor :
PT/CV

Approve by :
.....
.....

No	Revision	Date	Signed

Architect Consultant :
.....


Structure Consultant :
.....

Mechanical Consultant :
.....

Drawing Tittle :

Ceiling Plan

Scale	Drawn	Guntur Kusuma
1 : 100	Check	Abdi
	Approved	Mr. Philippe
Issued for :	Code	Draw no
Design Development	139	020
Date	10.11.2022	

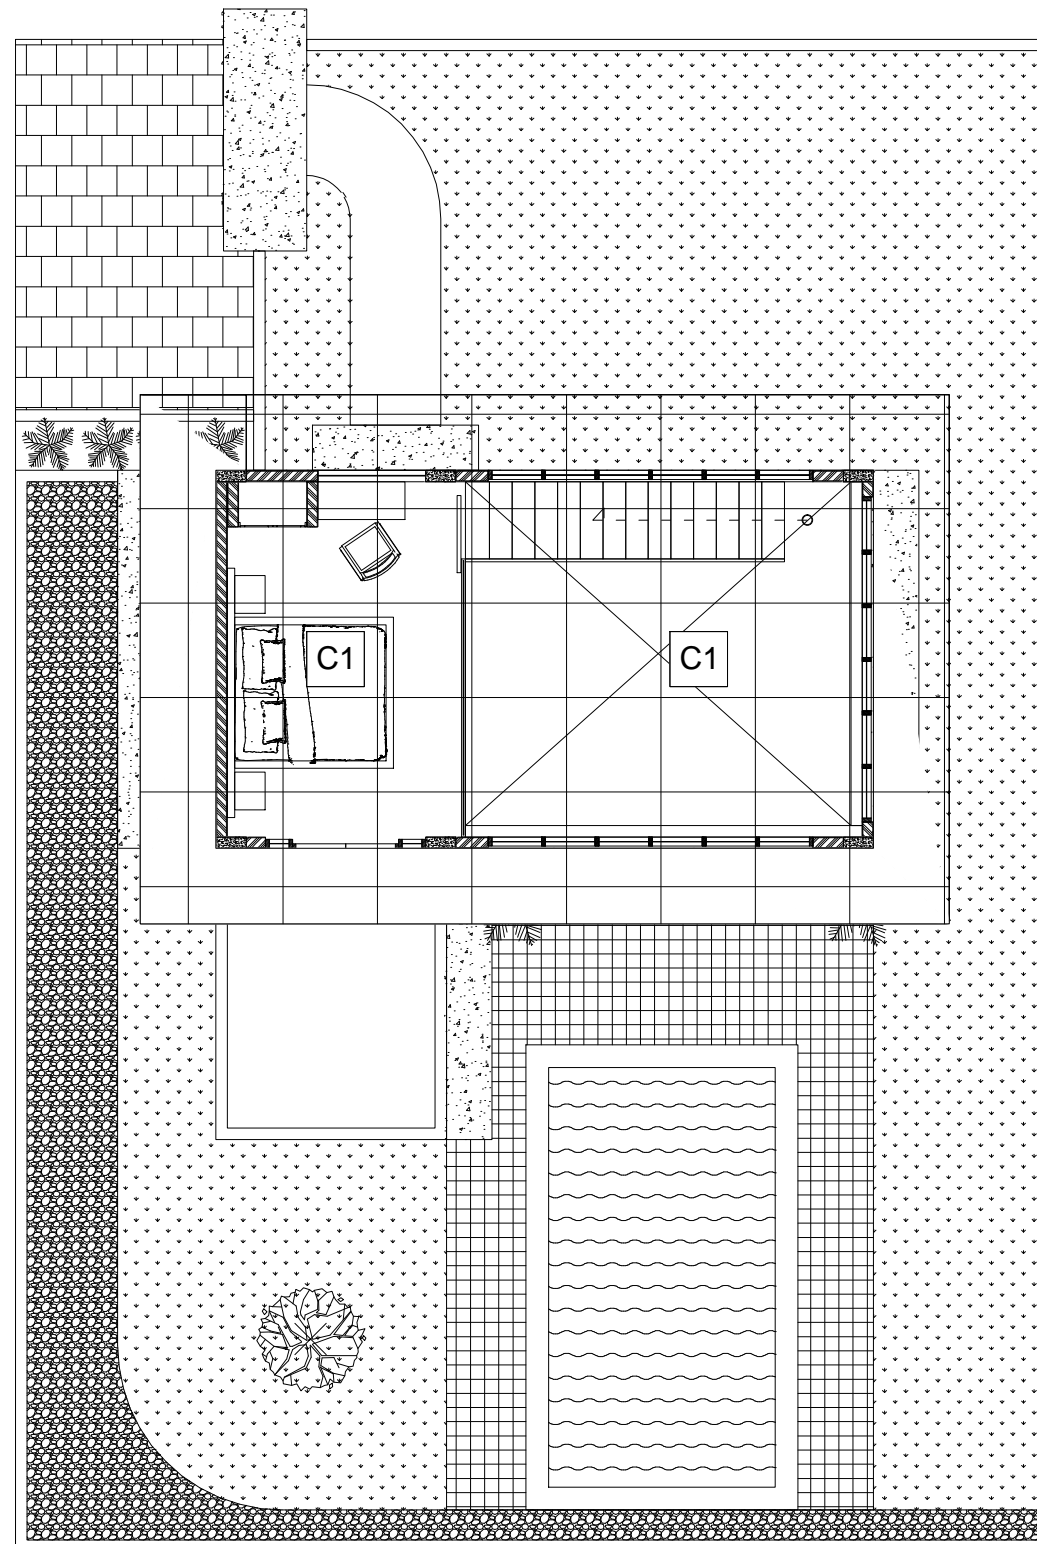

Ceiling Finished

C1 Gypsum Board



SHOP DRAWING

Project :
Damien Villa

Owner :
Mr. Philippe

Approve by :
.....
.....

Costruction Management :
PT/CV.

Check by :
.....
.....

Costruction Contractor :
PT/CV

Approve by :
.....
.....

No	Revision	Date	Signed

Architect Consultant :
.....

Structure Consultant :
.....

Mechanical Consultant :
.....

Drawing Tittle :


Wall Finished

Scale	Drawn	Guntur Kusuma
1 : 100	Check	Abdi
	Approved	Mr. Philippe

Issued for : Code Draw no

Design Development 139 019

Date 10.11.2022

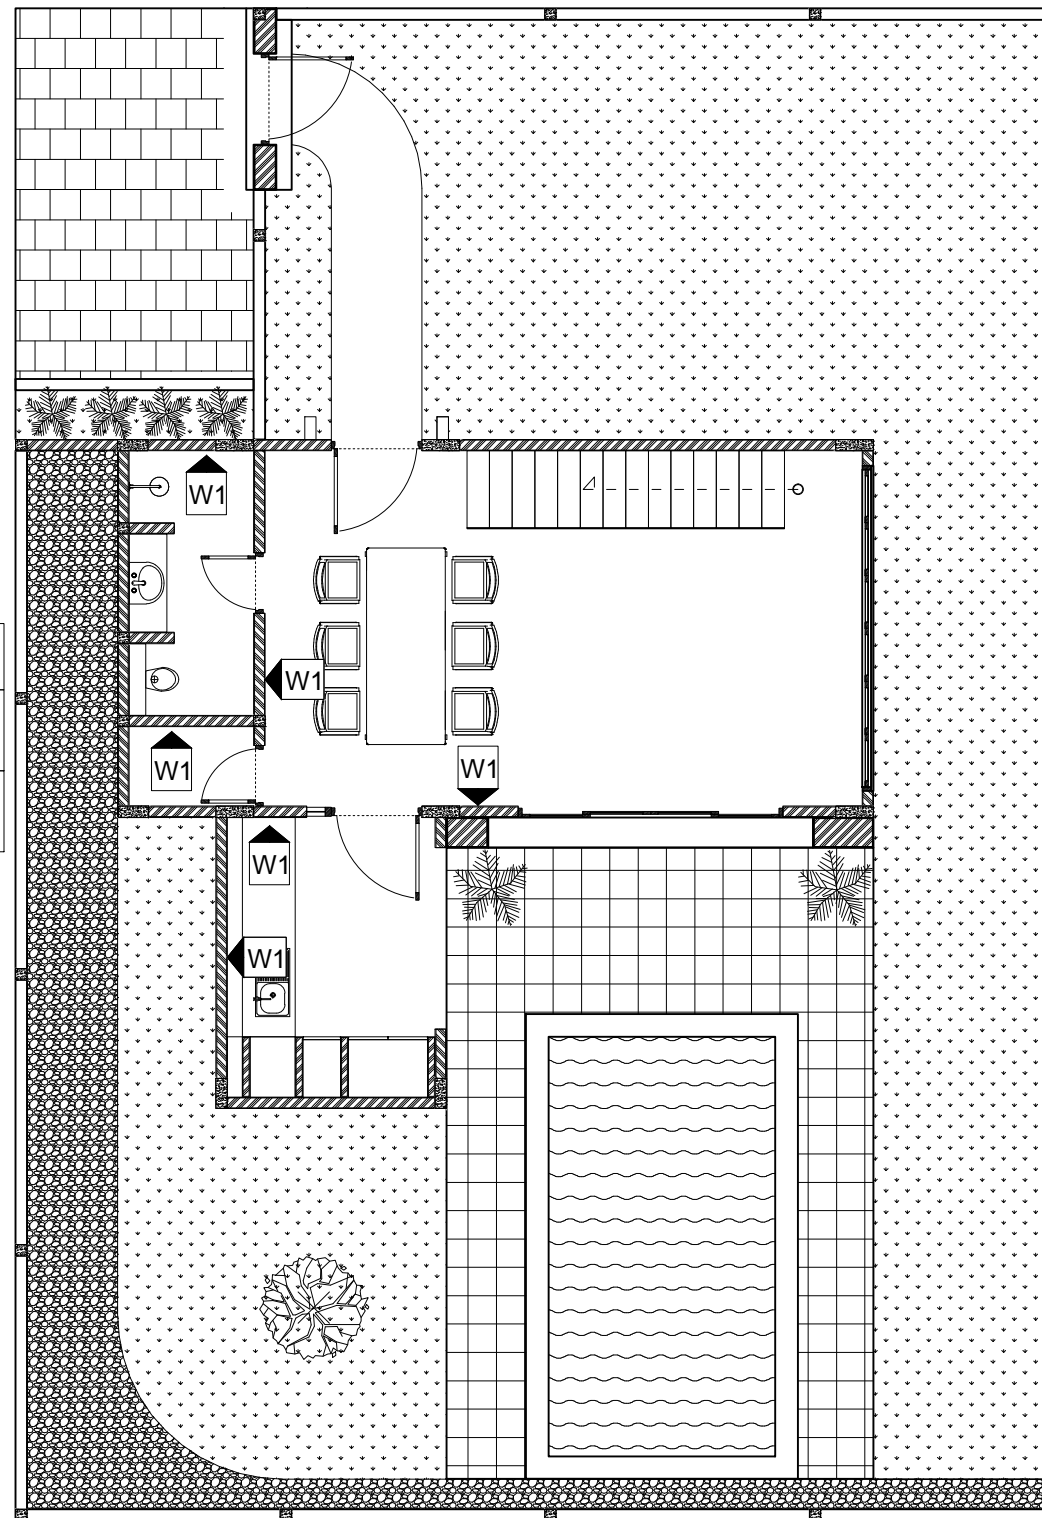

Wall Finished

W1 Painted Wall

W2 Teraso Wall



SHOP DRAWING

Project :
Damien Villa

Owner : 004
Mr. Philippe

Approve by :
.....
.....

Costruction Management :
PT/CV.

Check by :
.....
.....

Costruction Contractor :
PT/CV

Approve by :
.....
.....

No	Revision	Date	Signed

Architect Consultant :
.....

Structure Consultant :
.....

Mechanical Consultant :
.....

Drawing Tittle :


Wall Finished

Scale	Drawn	Guntur Kusuma
1 : 100	Check	Abdi
	Approved	Mr. Philippe

Issued for : Code Draw no

Design Development 139 020

Date 10.11.2022

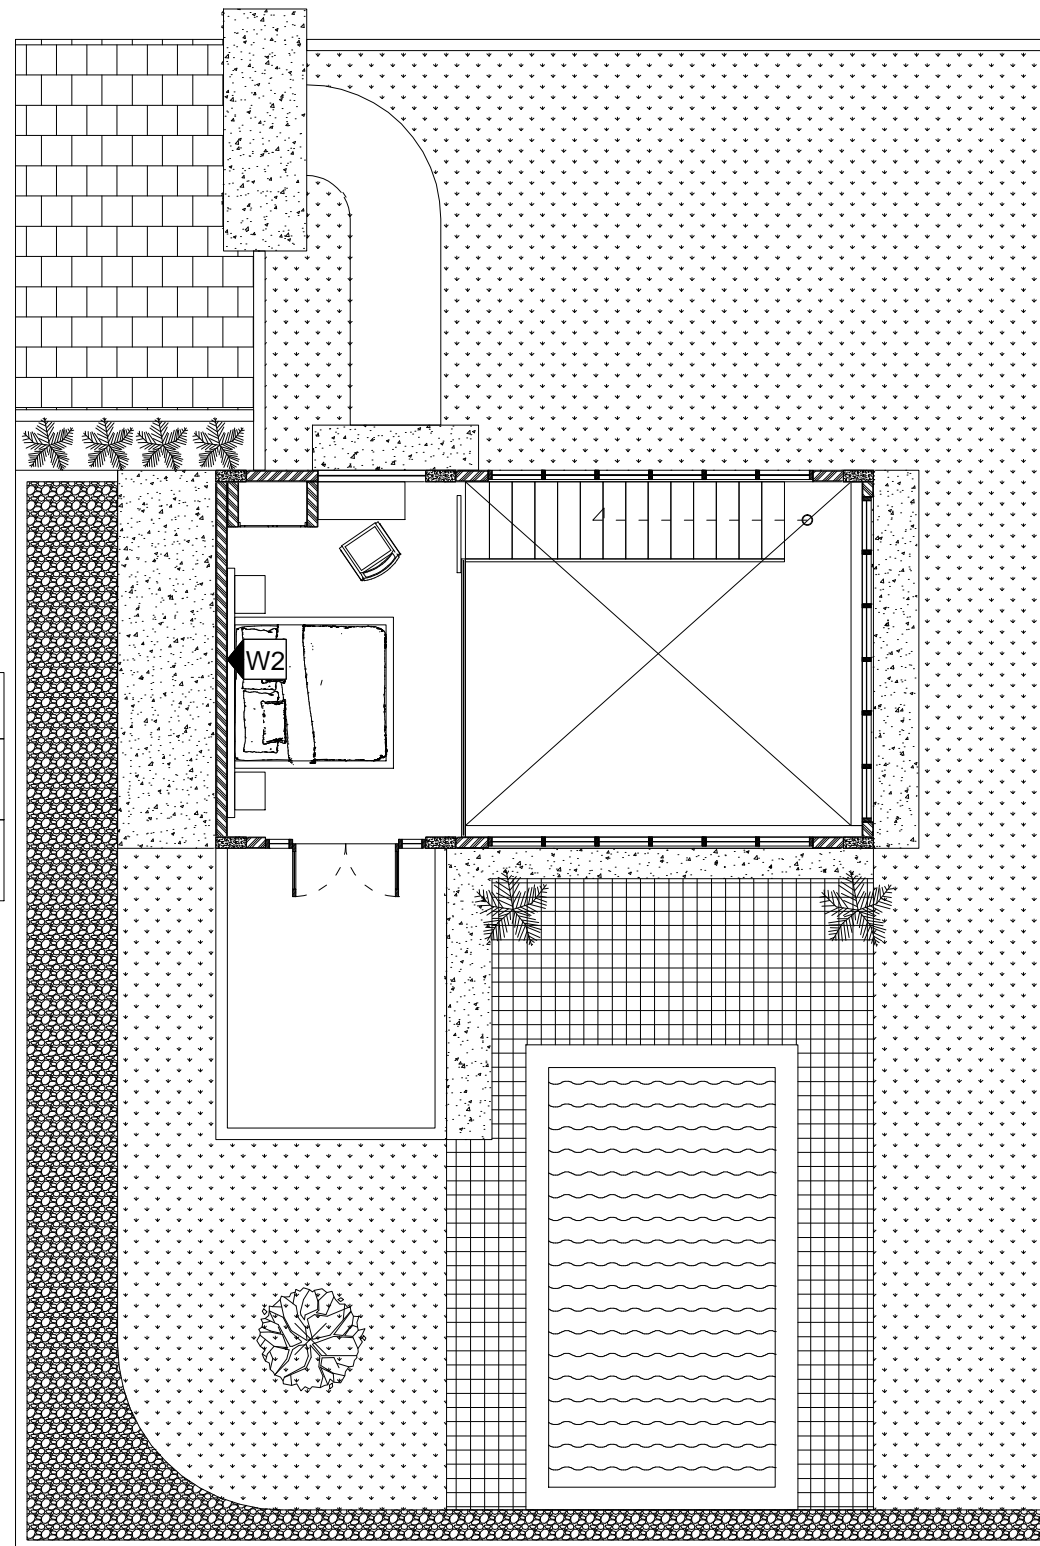

Wall Finished

W1 Painted Wall

W2 Teraso Wall



STRUCTURE DRAWING
DAMIEN VILLA

FOR CONSTRUCTION

OWNER :
PHILIPPE



SHOP DRAWING

Project :
Damien Villa

Owner :
Mr. Philippe

Approve by :
.....
.....

Costruction Management :
PT/CV.

Check by :
.....
.....

Costruction Contractor :
PT/CV

Approve by :
.....
.....

No	Revision	Date	Signed

Architect Consultant :
.....


Structure Consultant :
.....

Mechanical Consultant :
.....

Drawing Tittle :


Foundation Plan

Scale	Drawn	Guntur Kusuma
1 : 125	Check	Abdi
	Approved	Mr. Philippe
Issued for :	Code	Draw no
Design Development	139	001
Date	10.11.2022	

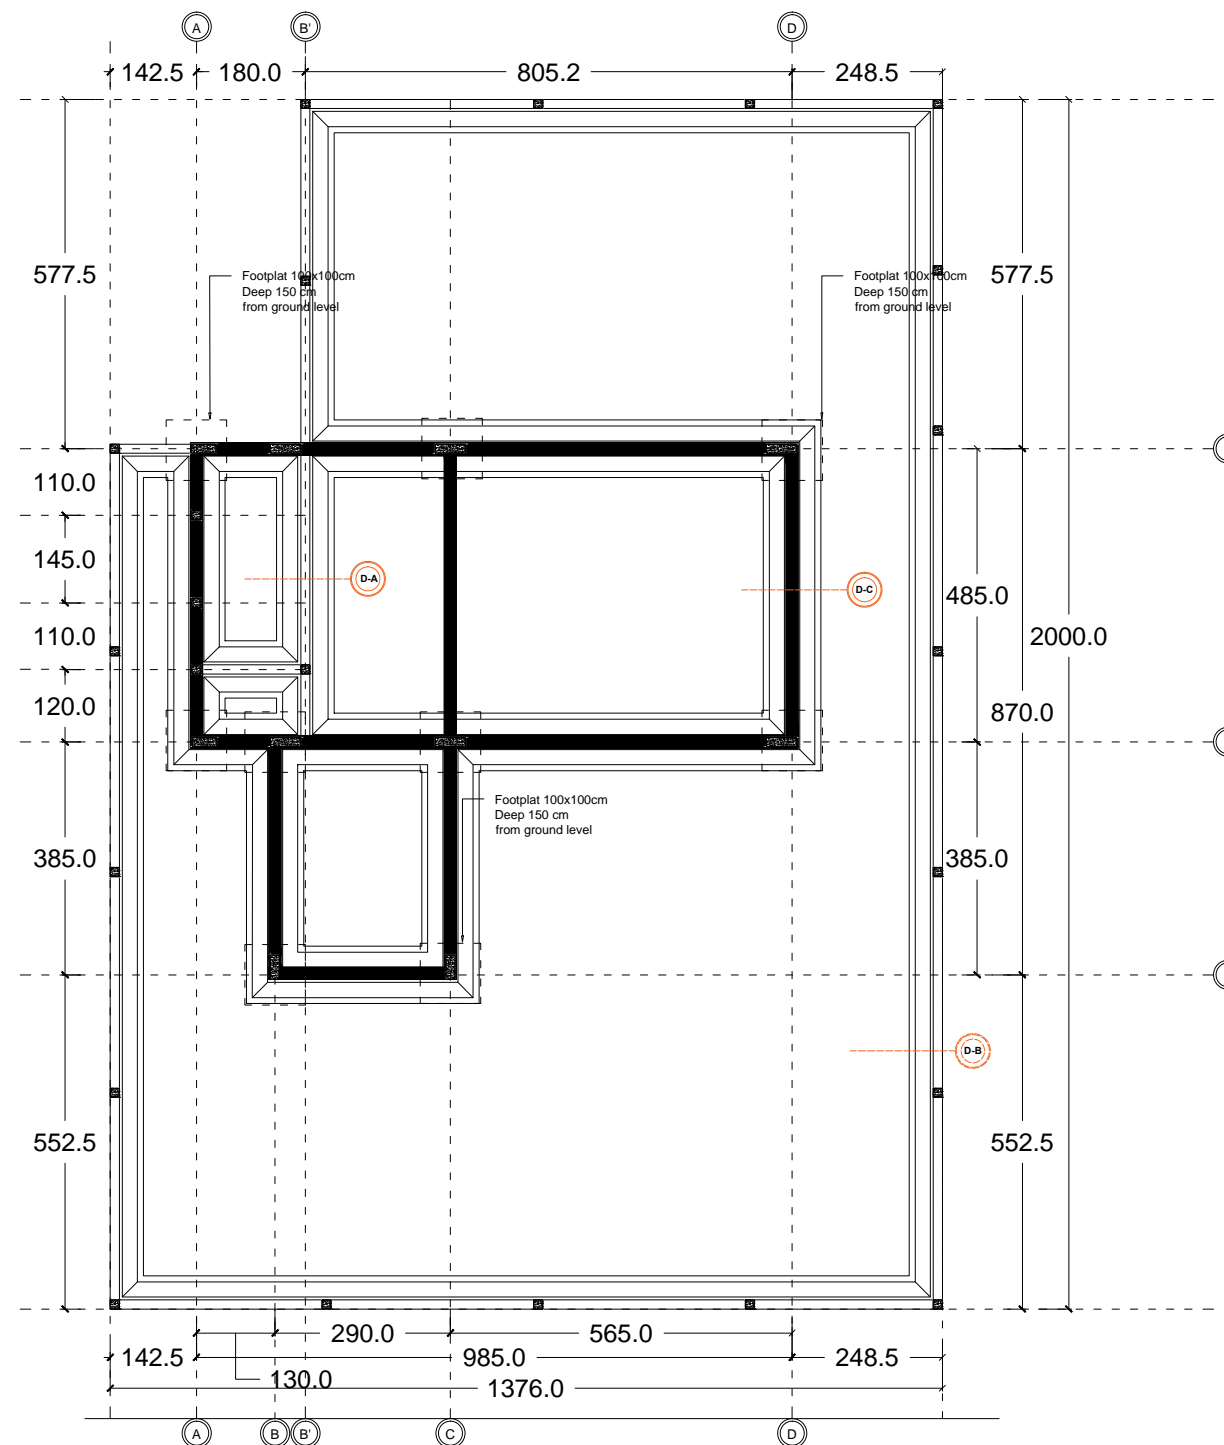

	S1 Sloof 20X30cm		FP1 100X100 cm
	SP Praktis 15x20cm		
	C1 Coloumn 15x20cm		
	Practice Column 15x15cm		



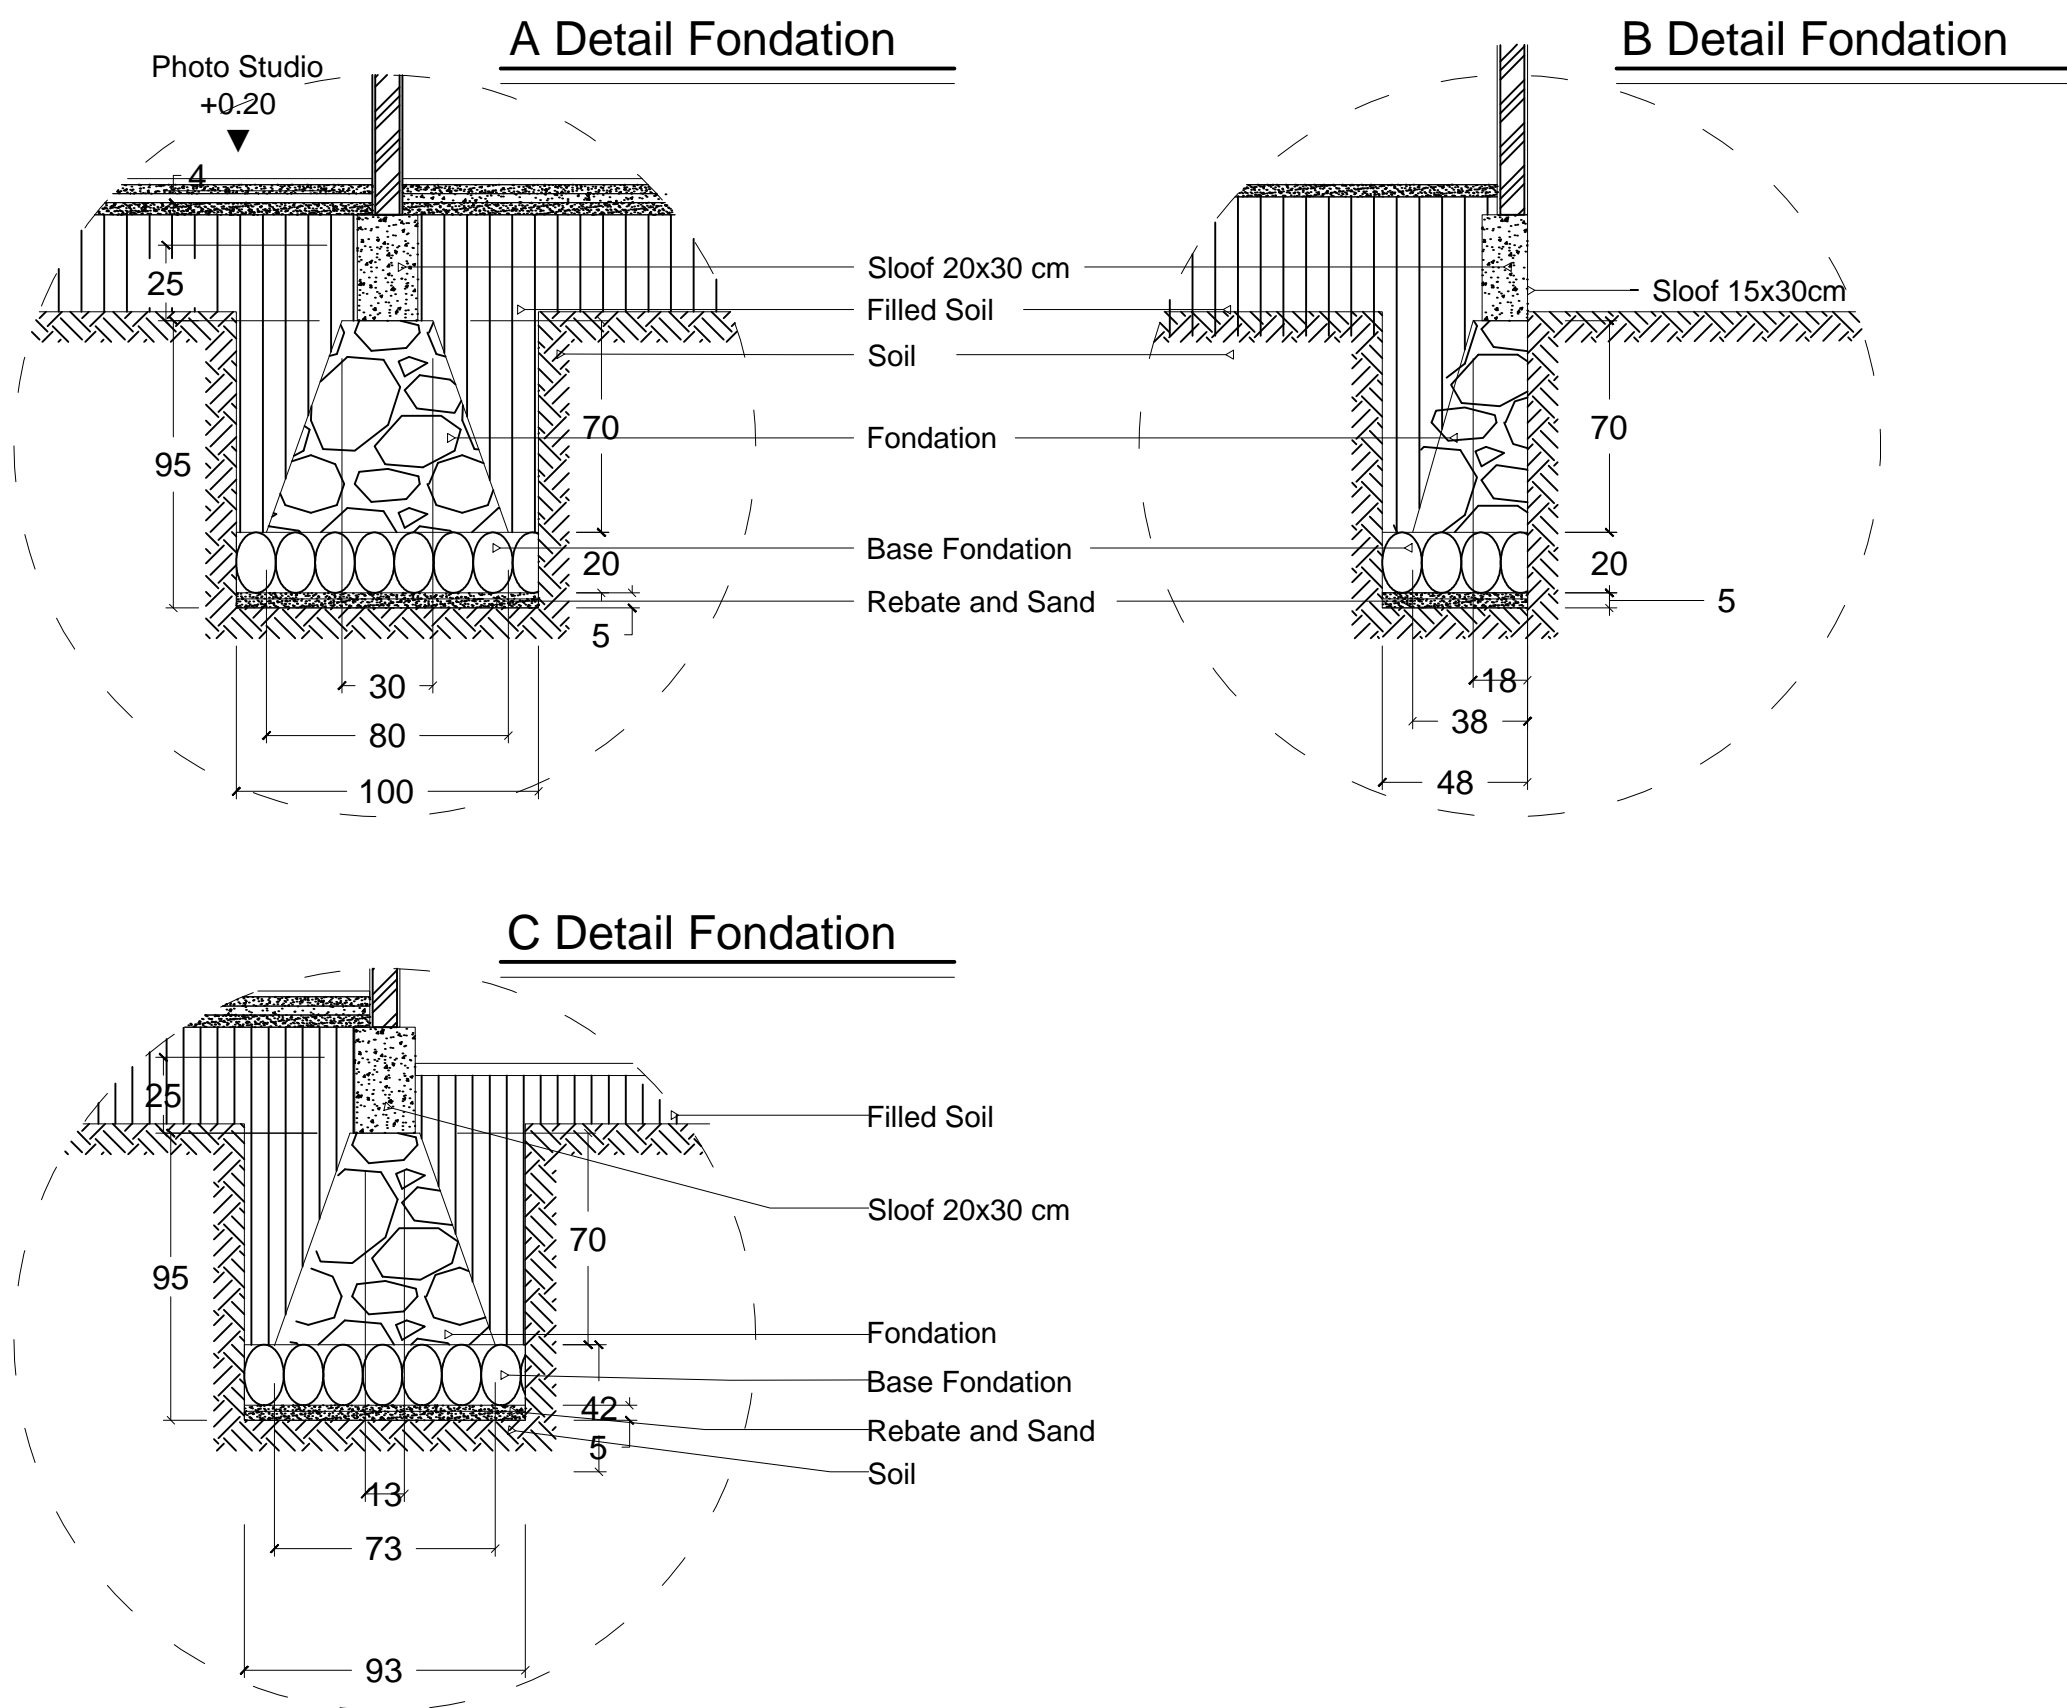

Detail Foundation

Scale 1:25



SHOP DRAWING

Project :
Damien Villa

Owner :
Mr. Philippe

Approve by :

.....
.....

Costruction Management :
PT/CV.

Check by :

.....
.....

Costruction Contractor :
PT/CV

Approve by :

.....
.....

No	Revision	Date	Signed

Architect Consultant :

.....

Structure Consultant :

.....

Mechanical Consultant :

.....

Drawing Tittle :

Detail Foundation

Scale	Drawn	Guntur Kusuma
1 : 100	Check	Abdi
	Approved	Mr. Philippe
Issued for :		Code Draw no
Design Development		139 002
Date	10.11.2022	

SHOP DRAWING

Project :
Damien Villa

Owner :
Mr. Philippe

Approve by :

.....
.....

Costruction Management :
PT/CV.

Check by :

.....
.....

Costruction Contractor :
PT/CV

Approve by :

.....
.....

No	Revision	Date	Signed

Architect Consultant :

.....

Structure Consultant :

.....


Mechanical Consultant :

.....

Drawing Tittle :

Sloof Plan

Scale	Drawn	Guntur Kusuma
1 : 125	Check	Abdi
	Approved	Mr. Philippe
Issued for :		Code Draw no
Design Development		139 003
Date	10.11.2022	

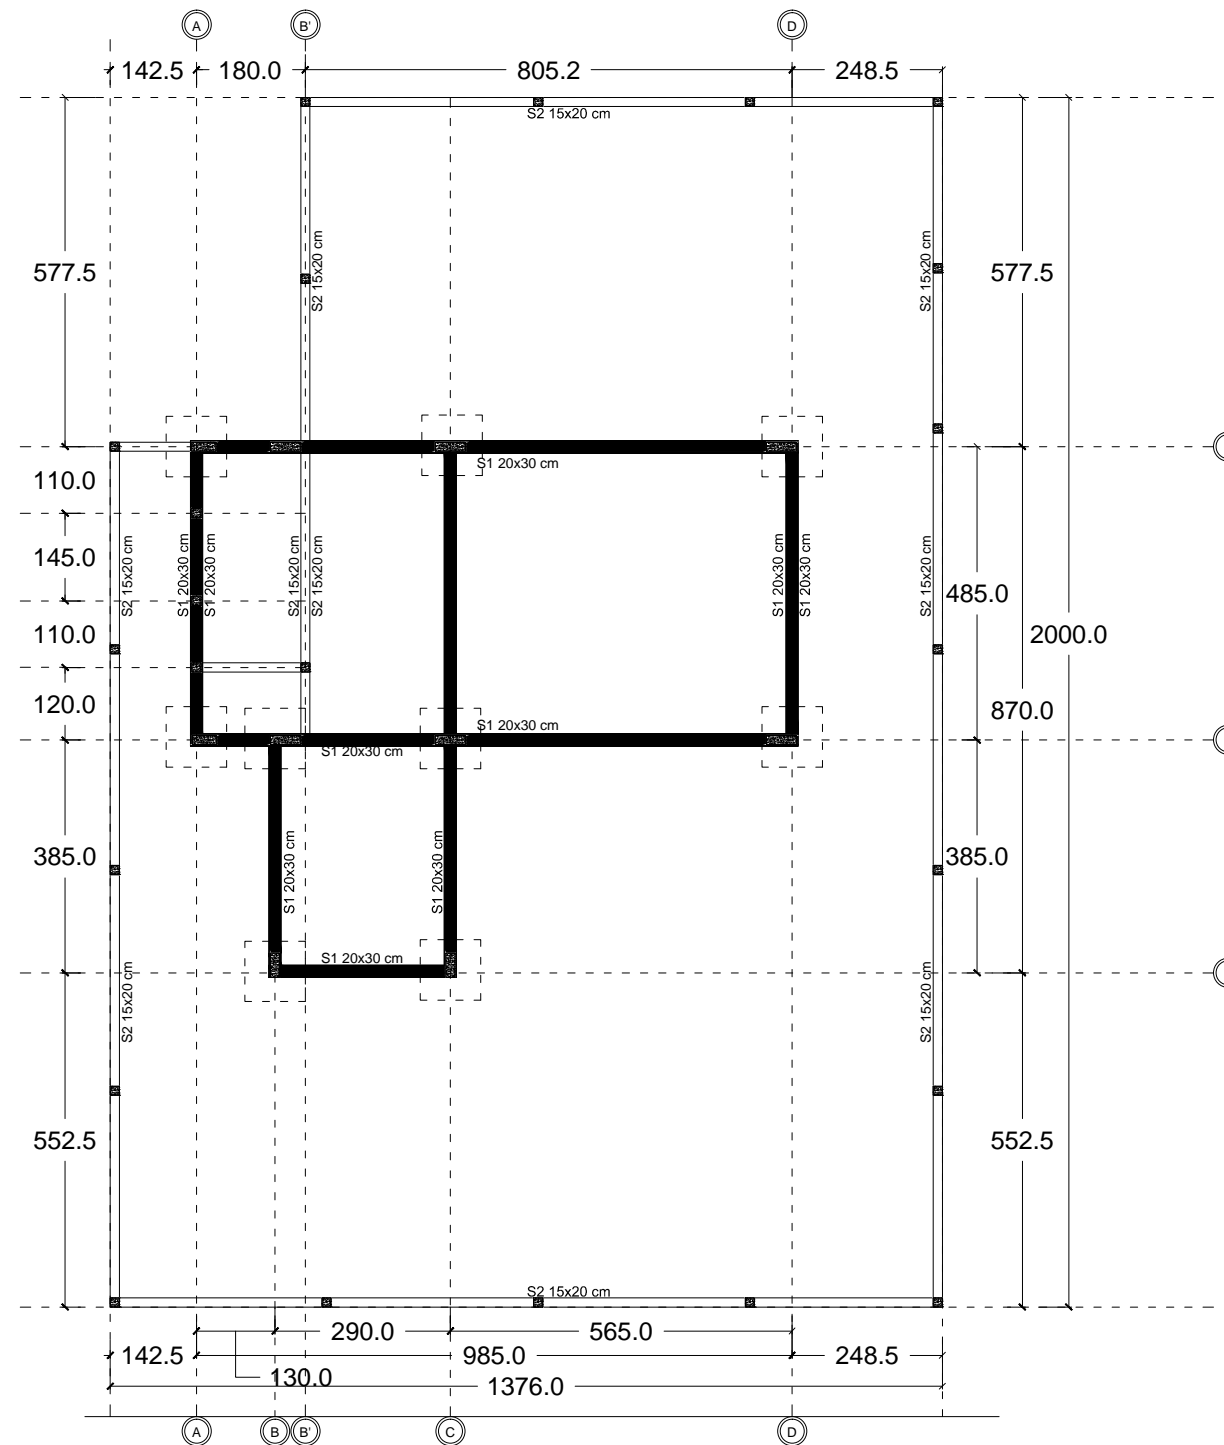

	S1 Sloof 20X30cm		FP1 100X100 cm
	SP Praktis 15x20cm		
	C1 Coloumn 15x20cm		
	Practice Column 15x15cm		



SHOP DRAWING

Project :
Damien Villa

Owner :
Mr. Philippe

Approve by :

.....
.....

Costruction Management :
PT/CV.

Check by :

.....
.....

Costruction Contractor :
PT/CV

Approve by :

.....
.....

No	Revision	Date	Signed

Architect Consultant :

.....

Structure Consultant :

.....


Mechanical Consultant :


 
.....

Drawing Tittle :

Beam Plan

Scale	Drawn	Guntur Kusuma
1 : 100	Check	Abdi
	Approved	Mr. Philippe
Issued for :		Code Draw no
Design Development		139 004
Date	10.11.2022	

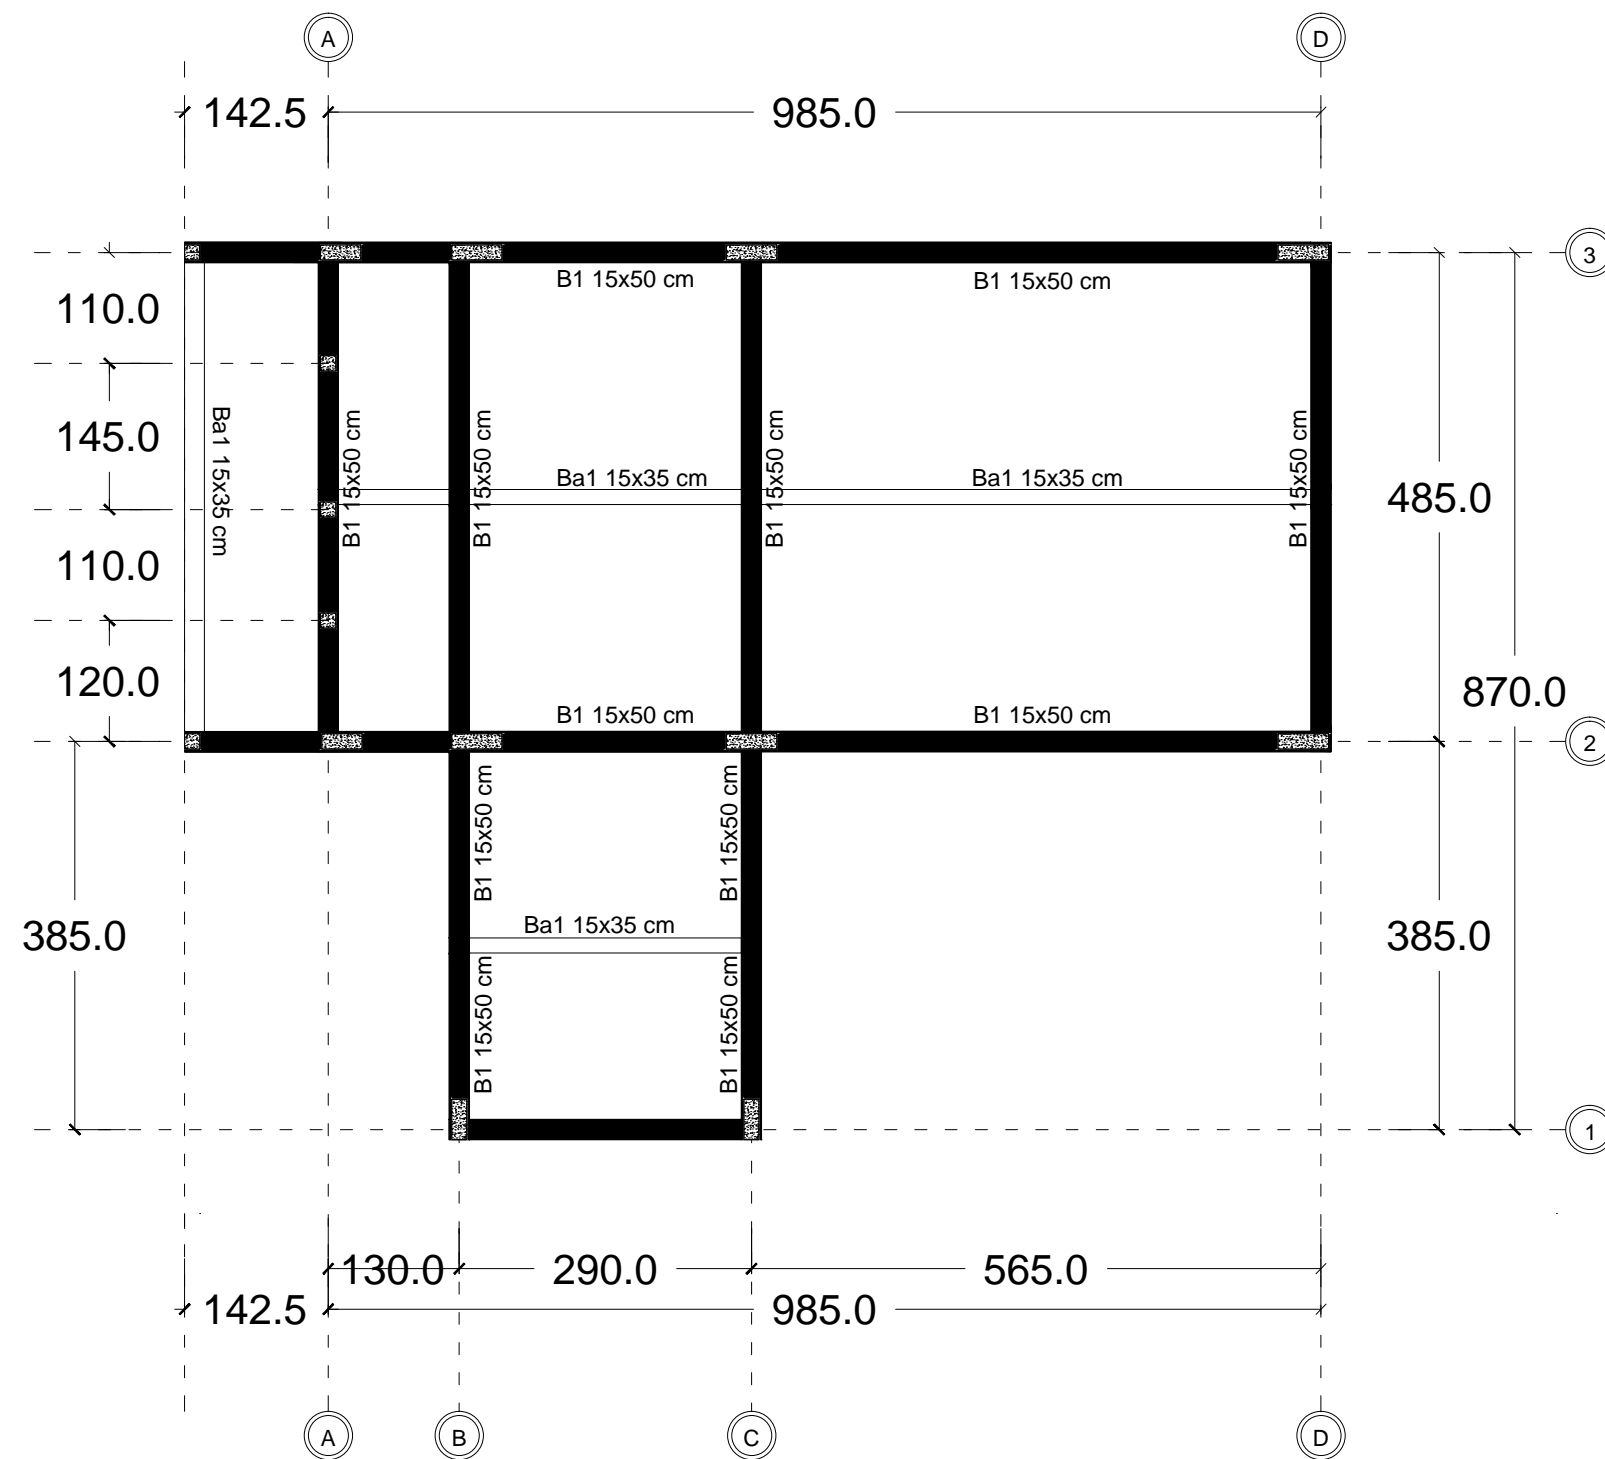

	B1 15X50 cm
	Ba1 15X35 cm



SHOP DRAWING

Project :
Damien Villa

Owner :
Mr. Philippe

Approve by :

.....
.....

Costruction Management :
PT/CV.

Check by :

.....
.....

Costruction Contractor :
PT/CV

Approve by :

.....
.....

No	Revision	Date	Signed

Architect Consultant :

.....

Structure Consultant :

.....


Mechanical Consultant :




.....

Drawing Tittle :

Beam Plan

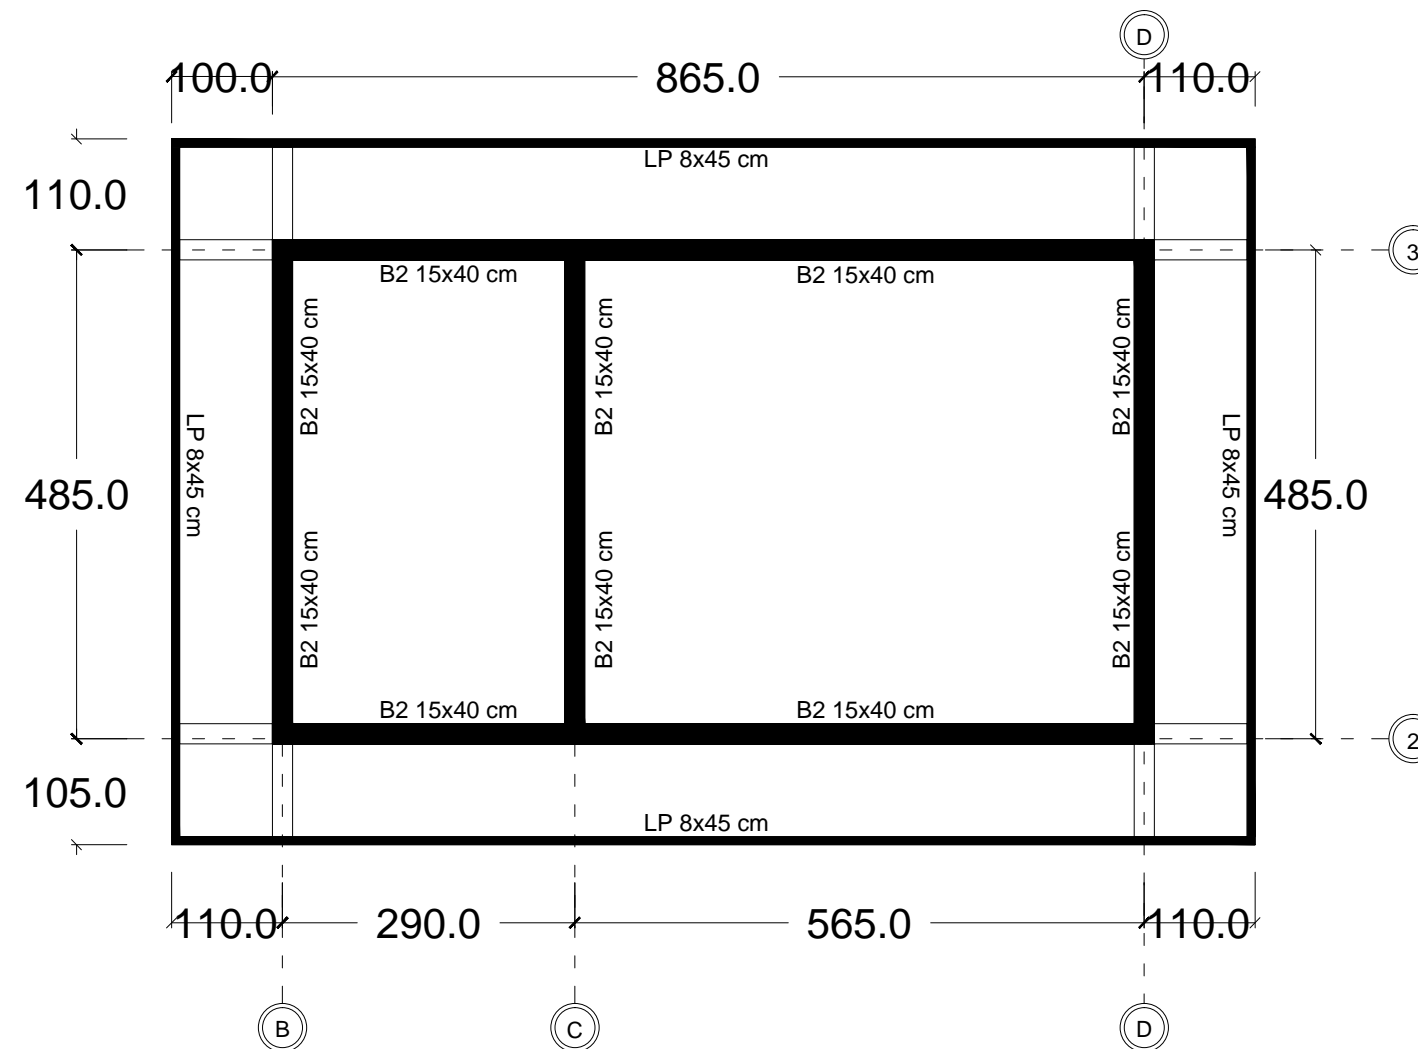Scale	Drawn	Guntur Kusuma
1 : 100	Check	Abdi
	Approved	Mr. Philippe
Issued for :	Code	Draw no
Design Development	139	005
Date	10.11.2022	



	B1 15X50 cm
	Ba1 15X35 cm
	LP 8X45 cm



SHOP DRAWING

Project :
Damien Villa

Owner :
Mr. Philippe

Approve by :

Costruction Management :
PT/CV.

Check by :

Costruction Contractor :
PT/CV

Approve by :

No	Revision	Date	Signed

Architect Consultant :

.....

Structure Consultant :

.....


Mechanical Consultant :

.....

Drawing Tittle :

Beam Plan

Scale	Drawn	Guntur Kusuma
1 : 100	Check	Abdi
	Approved	Mr. Philippe
Issued for :	Code	Draw no
Design Development	139	006
Date	10.11.2022	

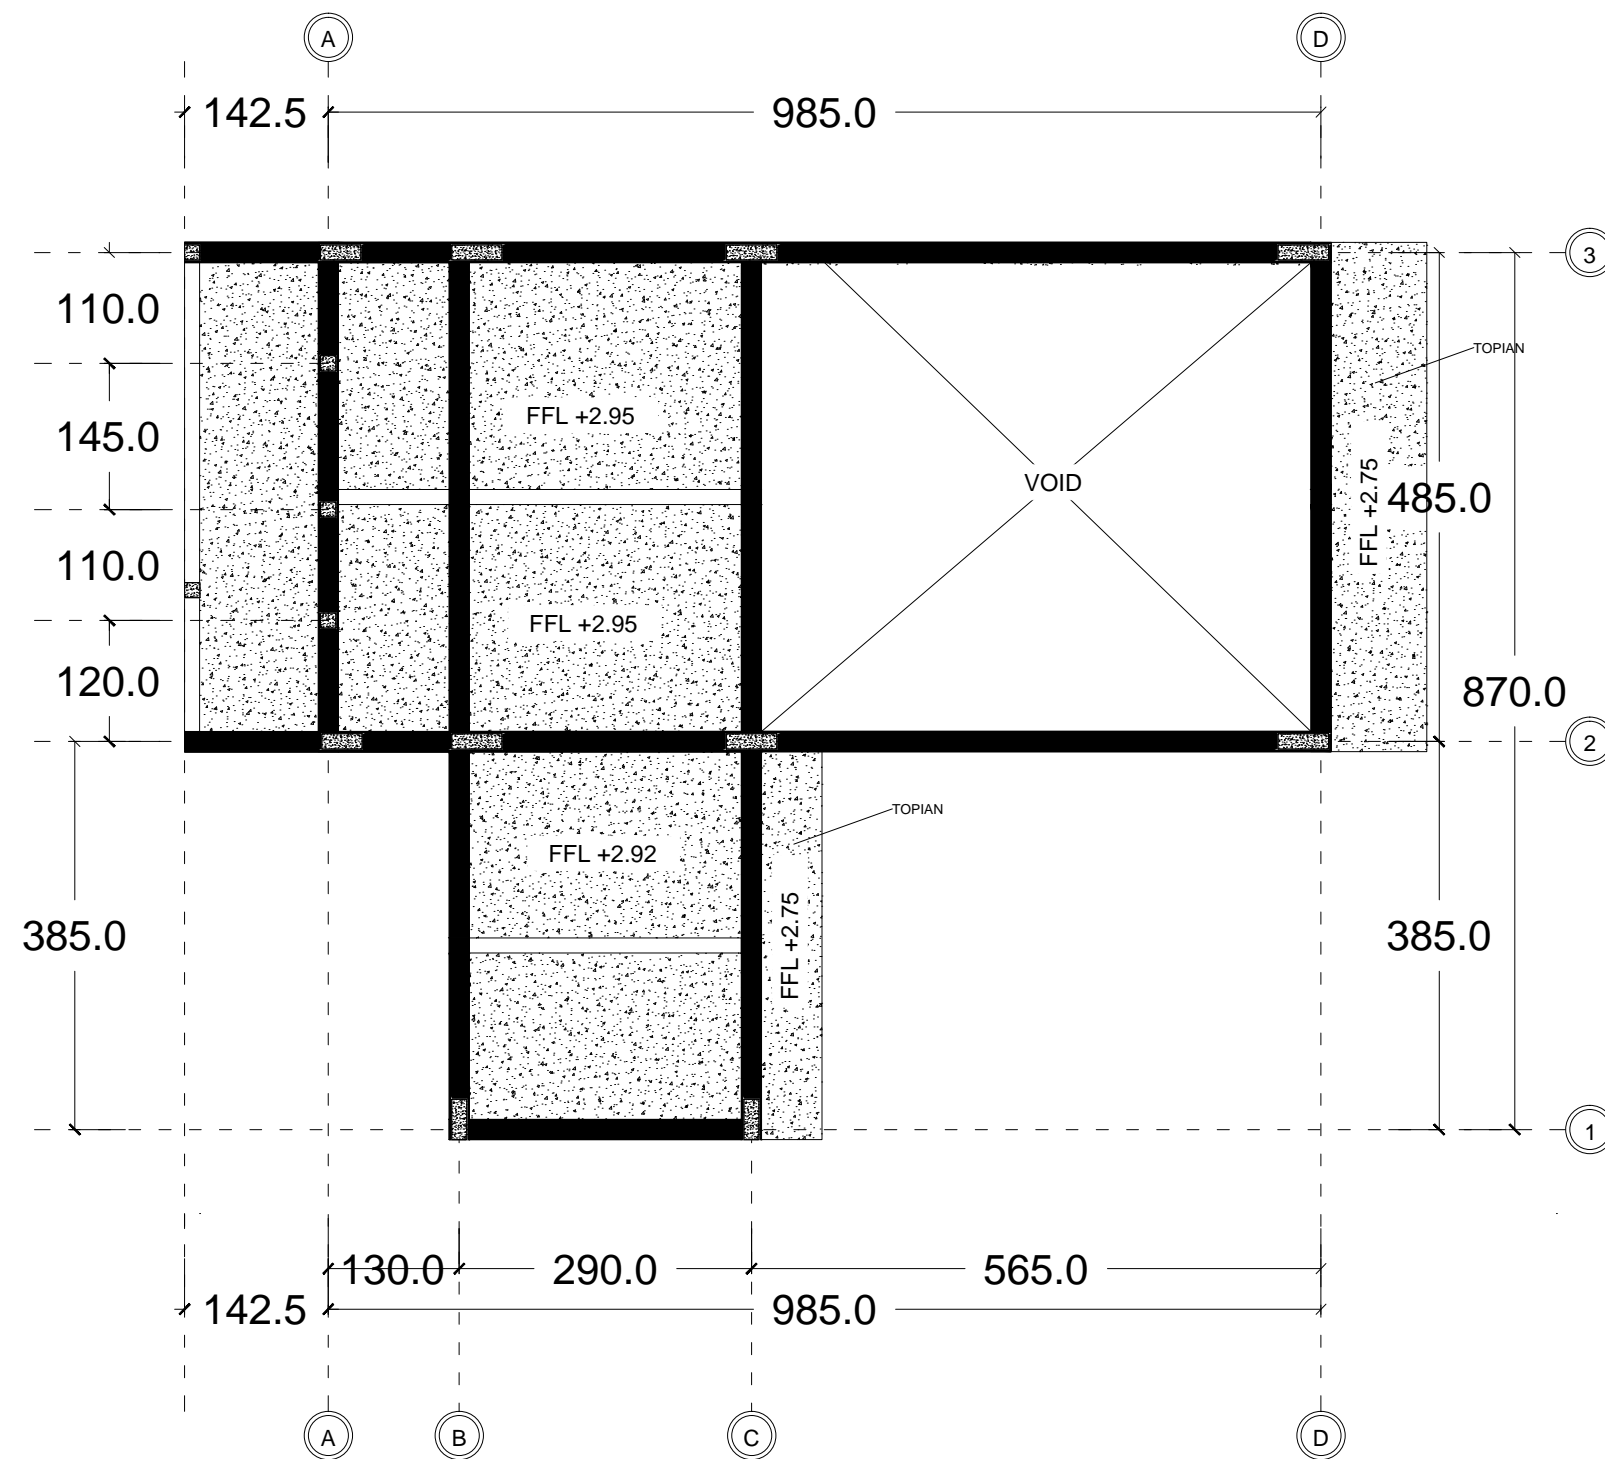

SHOP DRAWING

Project :
Damien Villa

Owner :
Mr. Philippe

Approve by :
.....
.....

Costruction Management :
PT/CV.

Check by :
.....
.....

Costruction Contractor :
PT/CV

Approve by :
.....
.....

No	Revision	Date	Signed

Architect Consultant :
.....


Structure Consultant :
.....

Mechanical Consultant :
.....

Drawing Tittle :

Beam Plan

Scale	Drawn	Guntur Kusuma
1 : 100	Check	Abdi
	Approved	Mr. Philippe
Issued for :	Code	Draw no
Design Development	139	007
Date	10.11.2022	

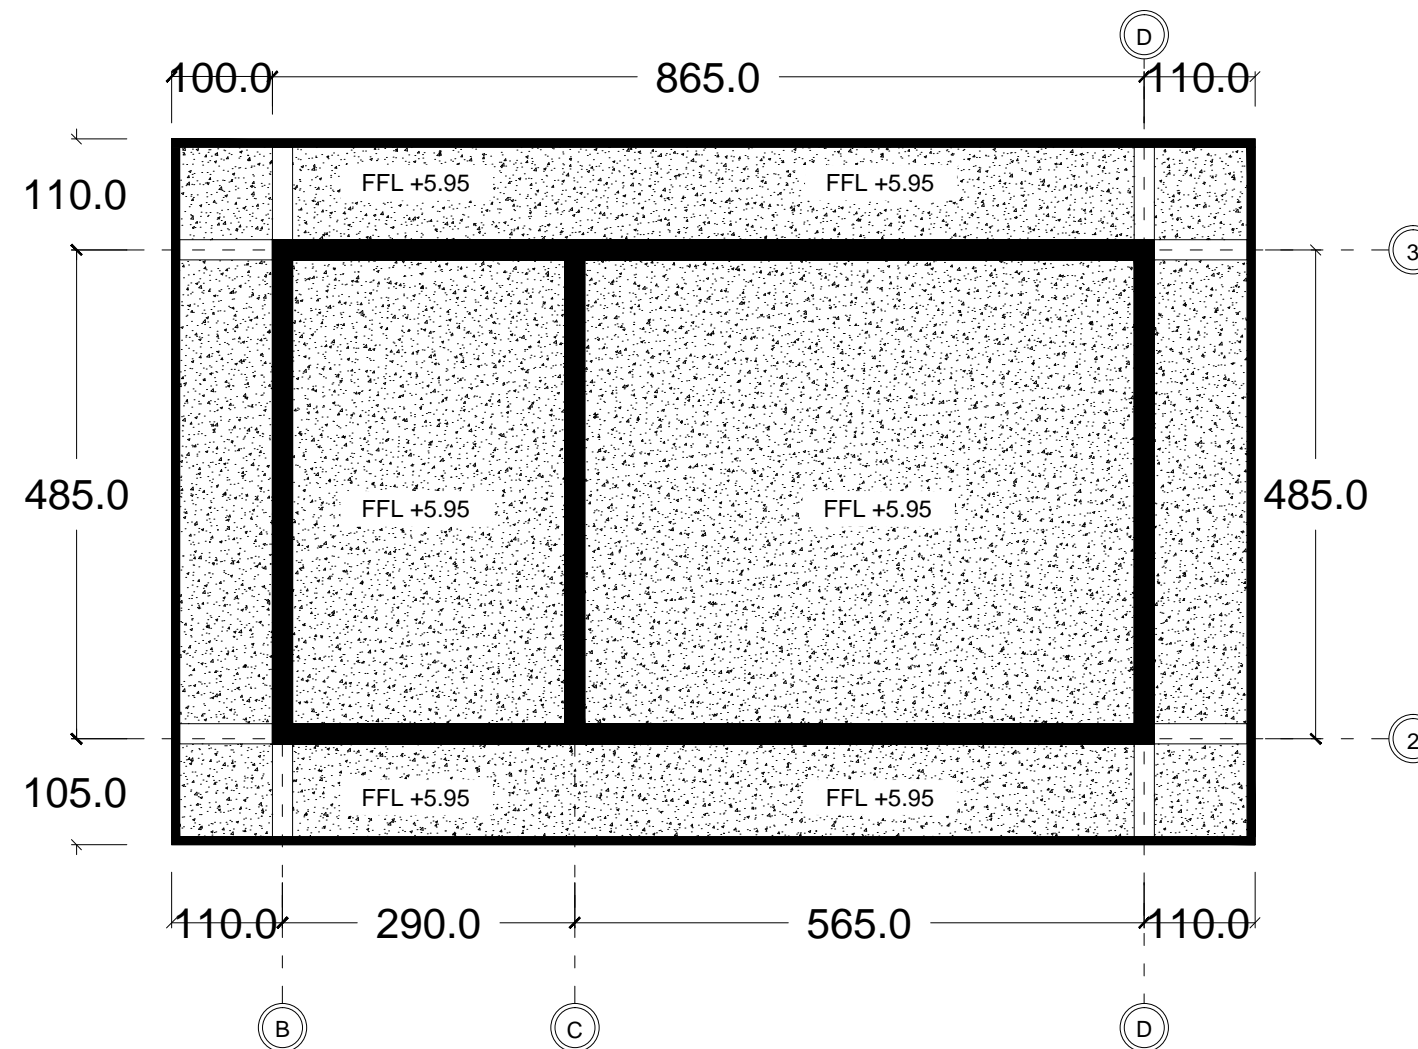

SHOP DRAWING

Project :
Damien Villa

Owner :
Mr. Philippe

Approve by :

Costruction Management :
PT/CV.

Check by :

Costruction Contractor :
PT/CV

Approve by :

No	Revision	Date	Signed

Architect Consultant :

.....

Structure Consultant :

.....


Mechanical Consultant :

.....

Drawing Tittle :

Portal 2 - A,B,C,D

Scale	Drawn	Guntur Kusuma
1 : 100	Check	Abdi
	Approved	Mr. Philippe
Issued for :	Code	Draw no
Design Development	139	008
Date	10.11.2022	

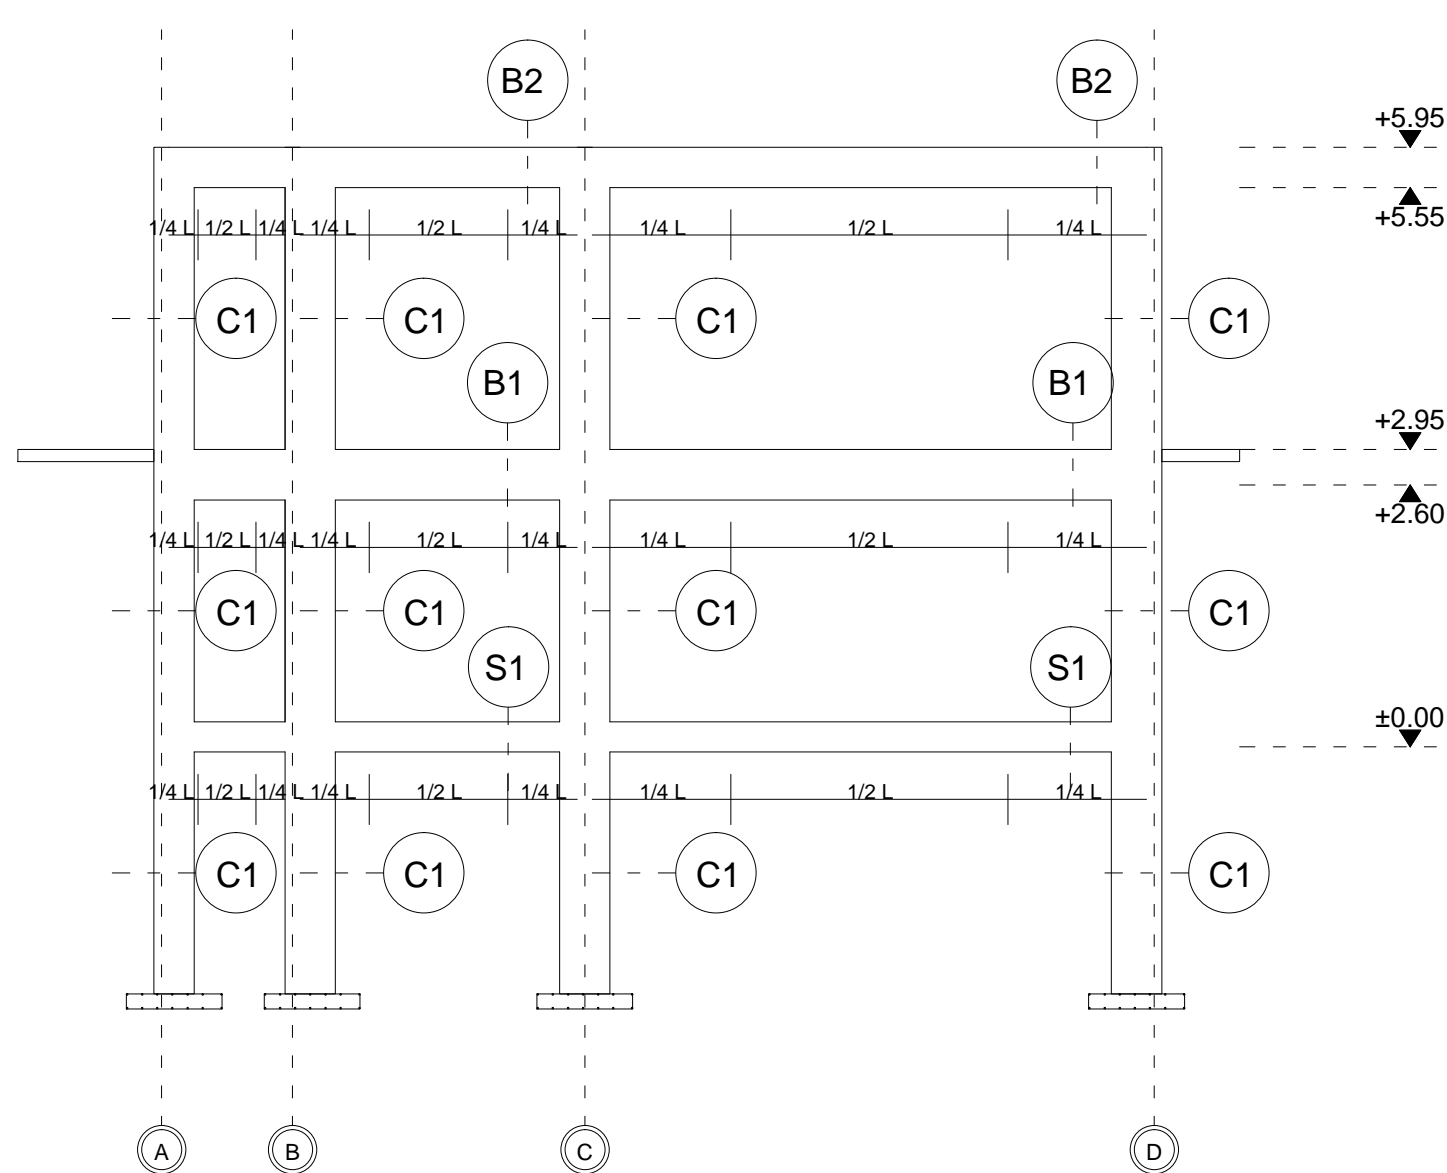

Portal 2-A,B,C,D



SHOP DRAWING

Project :
Damien Villa

Owner :
Mr. Philippe

Approve by :
.....
.....

Costruction Management :
PT/CV.

Check by :
.....
.....

Costruction Contractor :
PT/CV

Approve by :
.....
.....

No	Revision	Date	Signed

Architect Consultant :
.....


Structure Consultant :
.....

Mechanical Consultant :
.....

Drawing Tittle :

Portal B - 1,2,3

Scale	Drawn	Guntur Kusuma	
1 : 100	Check	Abdi	
	Approved	Mr. Philippe	
Issued for :		Code	Draw no
Design Development		139	009
Date	10.11.2022		

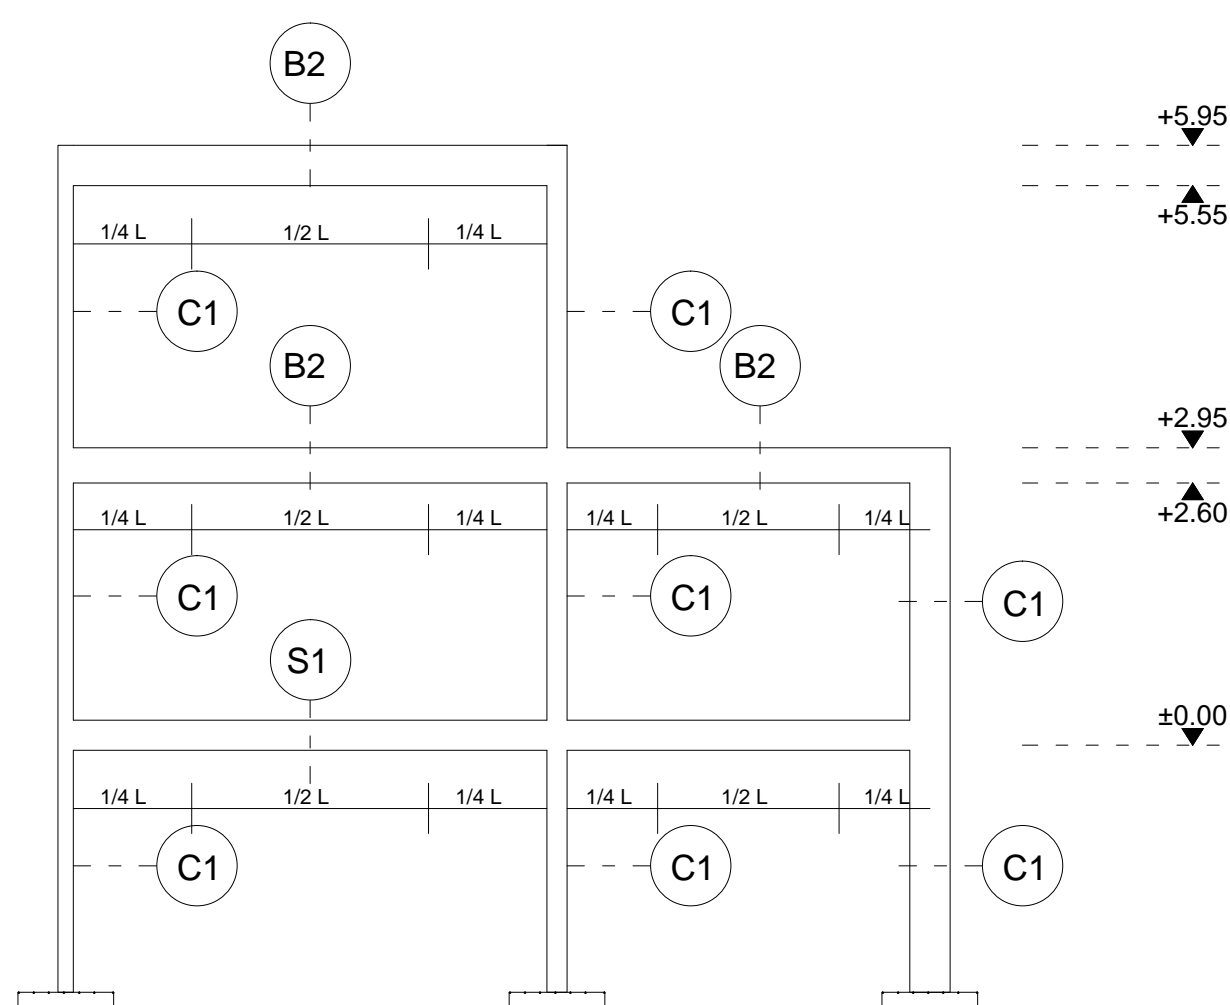

Portal B-1,2,3



SHOP DRAWING

Project :
Damien Villa

Owner :
Mr. Philippe

Approve by :
.....
.....

Costruction Management :
PT/CV.

Check by :
.....
.....

Costruction Contractor :
PT/CV

Approve by :
.....
.....

No	Revision	Date	Signed

Architect Consultant :
.....

Structure Consultant :
.....

Mechanical Consultant :
.....

Drawing Tittle :

Detail Sloof & Beam

Scale	Drawn	Guntur Kusuma
1 : 10	Check	Abdi
	Approved	Mr. Philippe
Issued for :		Code Draw no
Design Development		139 010
Date	10.11.2022	

Sloof

Type	S1 20 x 30 cm		S2 15 x 20 cm	
Position	1/4	1/2	1/4	1/2
Section				
Top Rein.	2D13	4D13	2D10	2D10
Middle Rein.	4D13	4D13	-	-
Bottom Rein.	4D13	2D13	2D10	2D10
Ring	Ø8 - 100	Ø8 - 150	Ø8 - 100	Ø8 - 150

Beam

Type	B1 15 x 50 cm		B2 15 x 40 cm		Ba1 15 x 35 cm	
Position	1/4	1/2	1/4	1/2	1/4	1/2
Section						
Top Rein.	5D13	2D13	4D13	2D13	4D13	2D13
Middle Rein.	4D13	4D13	4D13	4D13	2D13	2D13
Bottom Rein.	2D13	5D13	2D13	4D13	2D13	4D13
Ring	Ø8 - 100	Ø8 - 150	Ø8 - 100	Ø8 - 150	Ø8 - 100	Ø8 - 150



SHOP DRAWING

Project :
Damien Villa

Owner :
Mr. Philippe

Approve by :

.....
.....

Costruction Management :
PT/CV.

Check by :

.....
.....

Costruction Contractor :
PT/CV

Approve by :

.....
.....

No	Revision	Date	Signed

Architect Consultant :

.....

Structure Consultant :

.....

Mechanical Consultant :

.....

Drawing Tittle :

Detail Coloumn

Scale	Drawn	Guntur Kusuma
1 : 10	Check	Abdi
	Approved	Mr. Philippe
Issued for :		Code Draw no
Design Development		139 011
Date	10.11.2022	

Column

Type	C1 15 x 50		Practice Column	Practice Column	C2 15 x 40 cm	
Position	1/4	1/2	15 x 15 cm	10 x 10 cm	1/4	1/2
Section						
Corner Rein.	4D13	4D13	4D10	4D10	Ø8 - 125	Ø8 - 125
Middle Rein.	8D13	8D13	-	-		
Ring	Ø8 - 125	Ø8 - 125	Ø8 - 125	Ø8 - 125		



Listplank

Type	LP1 8 x 60 cm
Position	
Section	
x Rein.	Ø8 - 200
y Rein.	Ø8 - 200

Slab

Type	S1 12cm
Position	Slab 1st Floor
Section	
x Rein.	Ø8 - 200
y Rein.	Ø8 - 200

SHOP DRAWING

Project :
Damien Villa

Owner :
Mr. Philippe

Approve by :

.....

.....

Costruction Management :
PT/CV.

Check by :

.....

.....

Costruction Contractor :
PT/CV

Approve by :

.....

.....

No	Revision	Date	Signed

Architect Consultant :

.....

Structure Consultant :

.....

Mechanical Consultant :

.....

Drawing Tittle :

Detail Lisplank & Slab

Scale	Drawn	Guntur Kusuma
1 : 10	Check	Abdi
	Approved	Mr. Philippe
Issued for :		Code Draw no
Design Development		139 012
Date	10.11.2022	



MEP DRAWING
DAMIEN VILLA

FOR CONSTRUCTION

OWNER :
PHILIPPE



SHOP DRAWING

Project :
Damien Villa

Owner :
Mr. Philippe

Approve by :

.....
.....

Costruction Management :
PT/CV.

Check by :

.....
.....

Costruction Contractor :
PT/CV

Approve by :

.....
.....

No	Revision	Date	Signed

Architect Consultant :

.....

Structure Consultant :

.....




 







 
Mechanical Consultant :


.....

Drawing Tittle :

Ground Floor Lighting

Scale	Drawn	Guntur Kusuma
1 : 100	Check	Abdi
	Approved	Mr. Philippe
Issued for :	Code	Draw no
Design Development	139	001
Date	10.11.2022	

	Single Switch	-
	Double Switch	3
	Triple Switch	1
	Hotel Switch	-
	Line Cable NYM 2 x 1.5 mm2	-
	Downlight	6
	Hanging Lamp	3
	Garden Light	16
	Niche Downlight	-
	Pool Lamp	6
	LED Strip Light	-
	Decorative lights	-

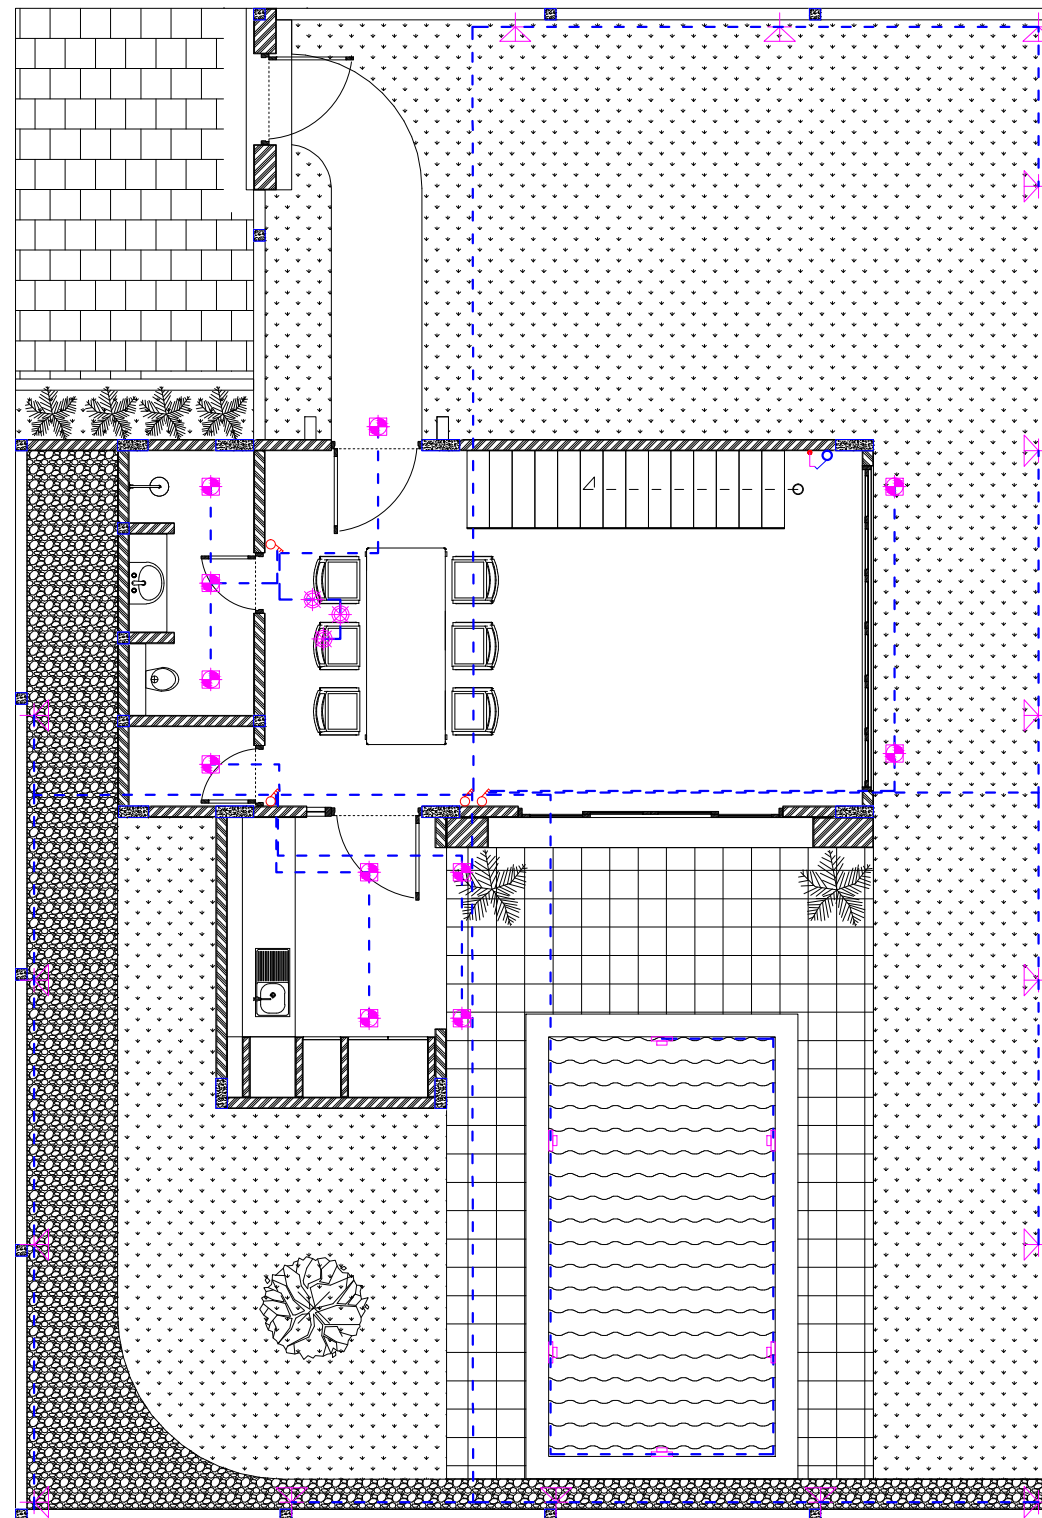

SHOP DRAWING

Project :
Damien Villa

Owner :
Mr. Philippe

Approve by :

.....
.....

Costruction Management :
PT/CV.

Check by :

.....
.....

Costruction Contractor :
PT/CV

Approve by :

.....
.....

No	Revision	Date	Signed

Architect Consultant :

.....

Structure Consultant :

.....


Mechanical Consultant :

.....

Drawing Tittle :

First Floor Lighting

Scale	Drawn	Guntur Kusuma
1 : 100	Check	Abdi
	Approved	Mr. Philippe
Issued for :	Code	Draw no
Design Development	139	002
Date	10.11.2022	

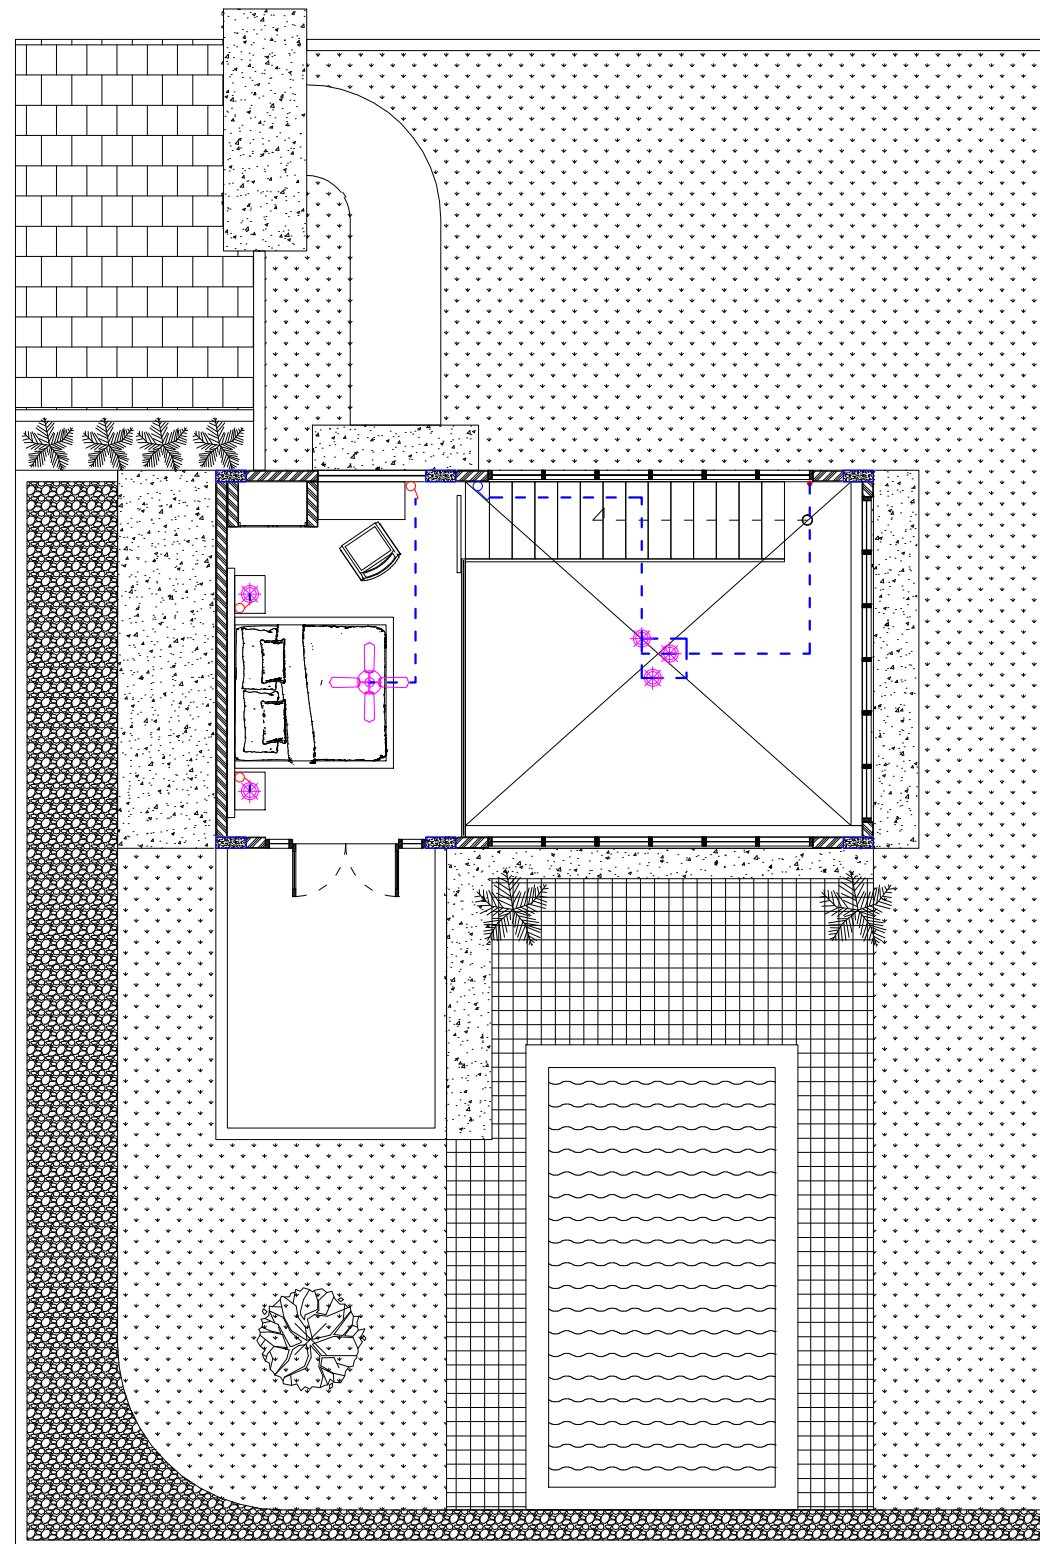

	Single Switch	-
	Double Switch	3
	Triple Switch	1
	Hotel Switch	-
	Line Cable NYM 2 x 1.5 mm2	-
	Downlight	6
	Hanging Lamp	3
	Garden Light	16
	Niche Downlight	-
	Pool Lamp	6
	LED Strip Light	-
	Decorative lights	-
	Ceiling Fan	1



SHOP DRAWING

Project :
Damien Villa

Owner :
Mr. Philippe

Approve by :

.....
.....

Costruction Management :
PT/CV.

Check by :

.....
.....

Costruction Contractor :
PT/CV

Approve by :

.....
.....

No	Revision	Date	Signed

Architect Consultant :

.....

Structure Consultant :

.....


Mechanical Consultant :


.....

Drawing Tittle :

**Ground Floor
Switch and Socket Plan**

Scale	Drawn	Guntur Kusuma
1 : 100	Check	Abdi
	Approved	Mr. Philippe
Issued for :	Code	Draw no
Design Development	139	003
Date	10.11.2022	

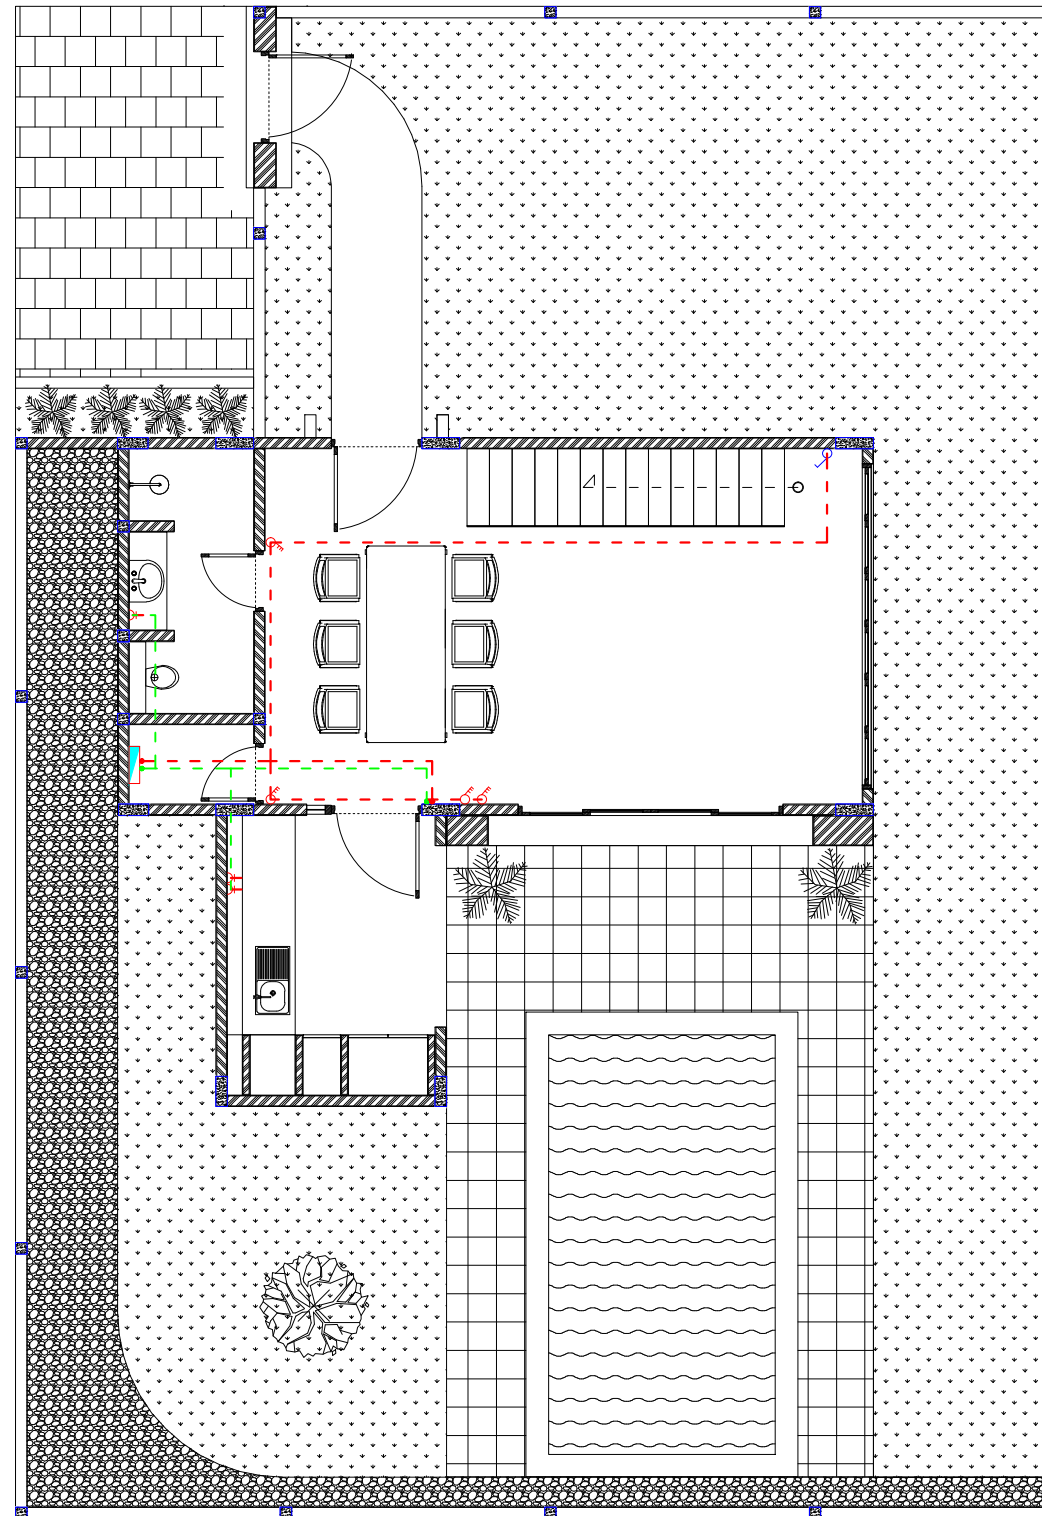

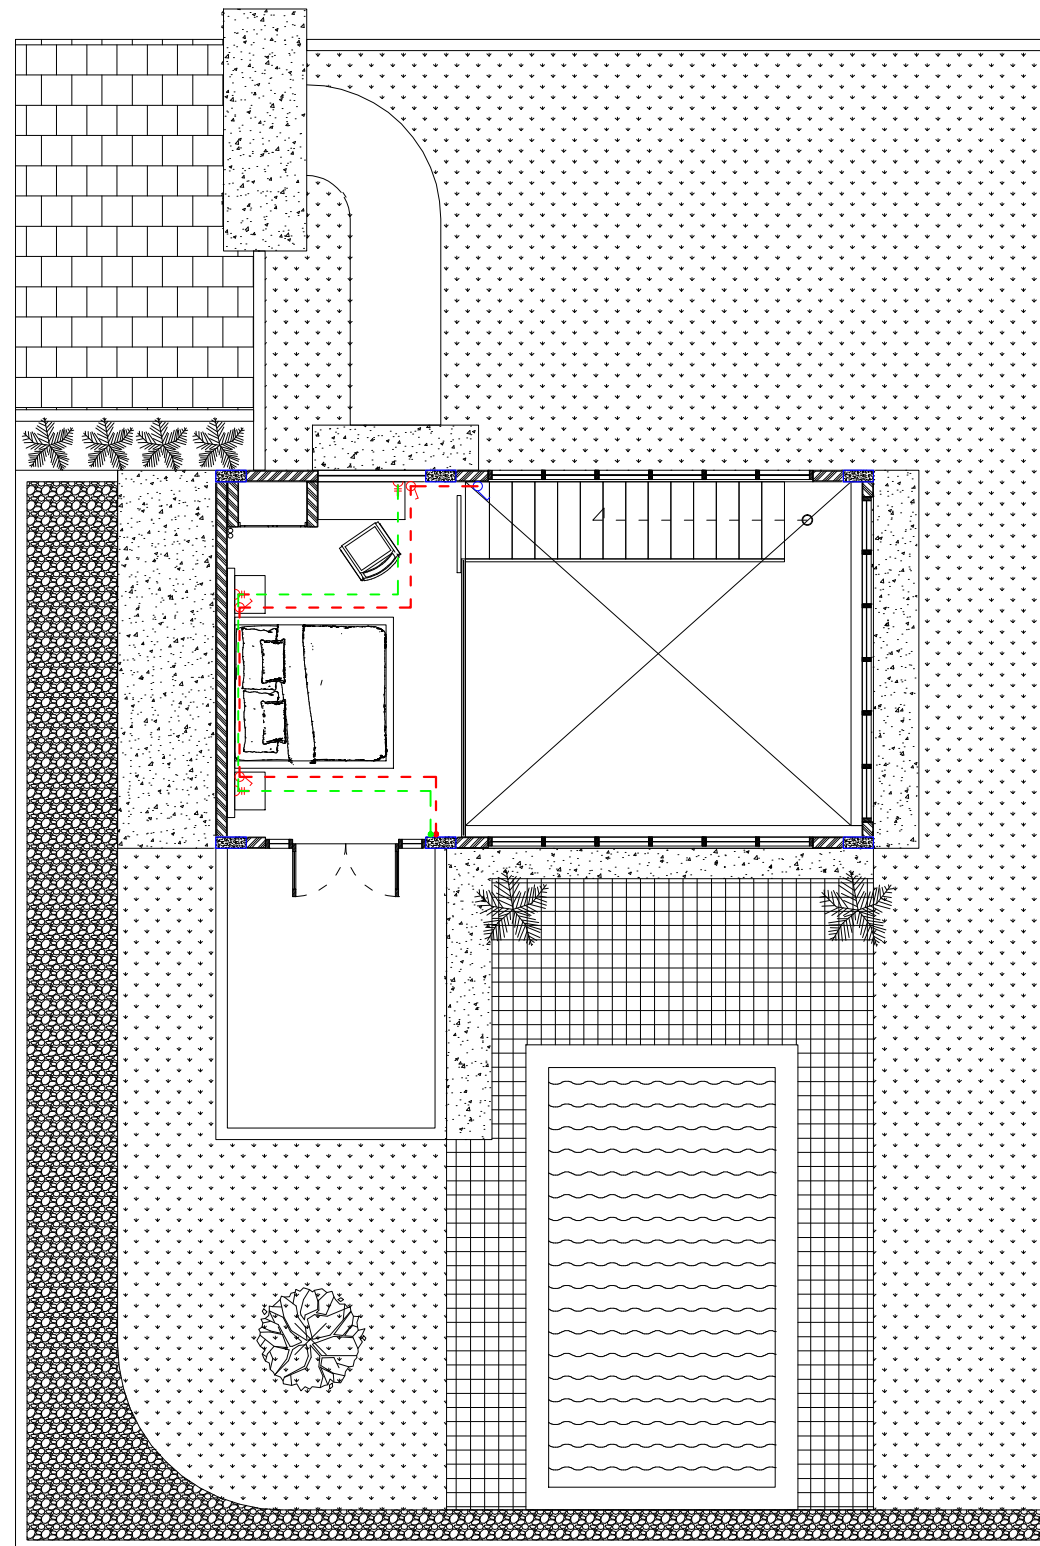

SHOP DRAWING

Project :
Damien Villa

Owner :
Mr. Philippe

Approve by :

.....
.....

Costruction Management :
PT/CV.

Check by :

.....
.....

Costruction Contractor :
PT/CV

Approve by :

.....
.....

No	Revision	Date	Signed

Architect Consultant :

.....

Structure Consultant :

.....

Mechanical Consultant :

.....

Drawing Tittle :

**First Floor
Switch and Socket Plan**

Scale	Drawn	Guntur Kusuma
1 : 100	Check	Abdi
	Approved	Mr. Philippe
Issued for :	Code	Draw no
Design Development	139	004
Date	10.11.2022	



SHOP DRAWING

Project :
Damien Villa

Owner :
Mr. Philippe

Approve by :

.....
.....

Costruction Management :
PT/CV.

Check by :

.....
.....

Costruction Contractor :
PT/CV

Approve by :

.....
.....

No	Revision	Date	Signed

Architect Consultant :

.....

Structure Consultant :

.....


Mechanical Consultant :

.....

Drawing Tittle :

**Ground Floor
Plumbing Plan**

Scale	Drawn	Guntur Kusuma
1 : 100	Check	Abdi
	Approved	Mr. Philippe
Issued for :		Code Draw no
Design Development		139 005
Date	10.11.2022	

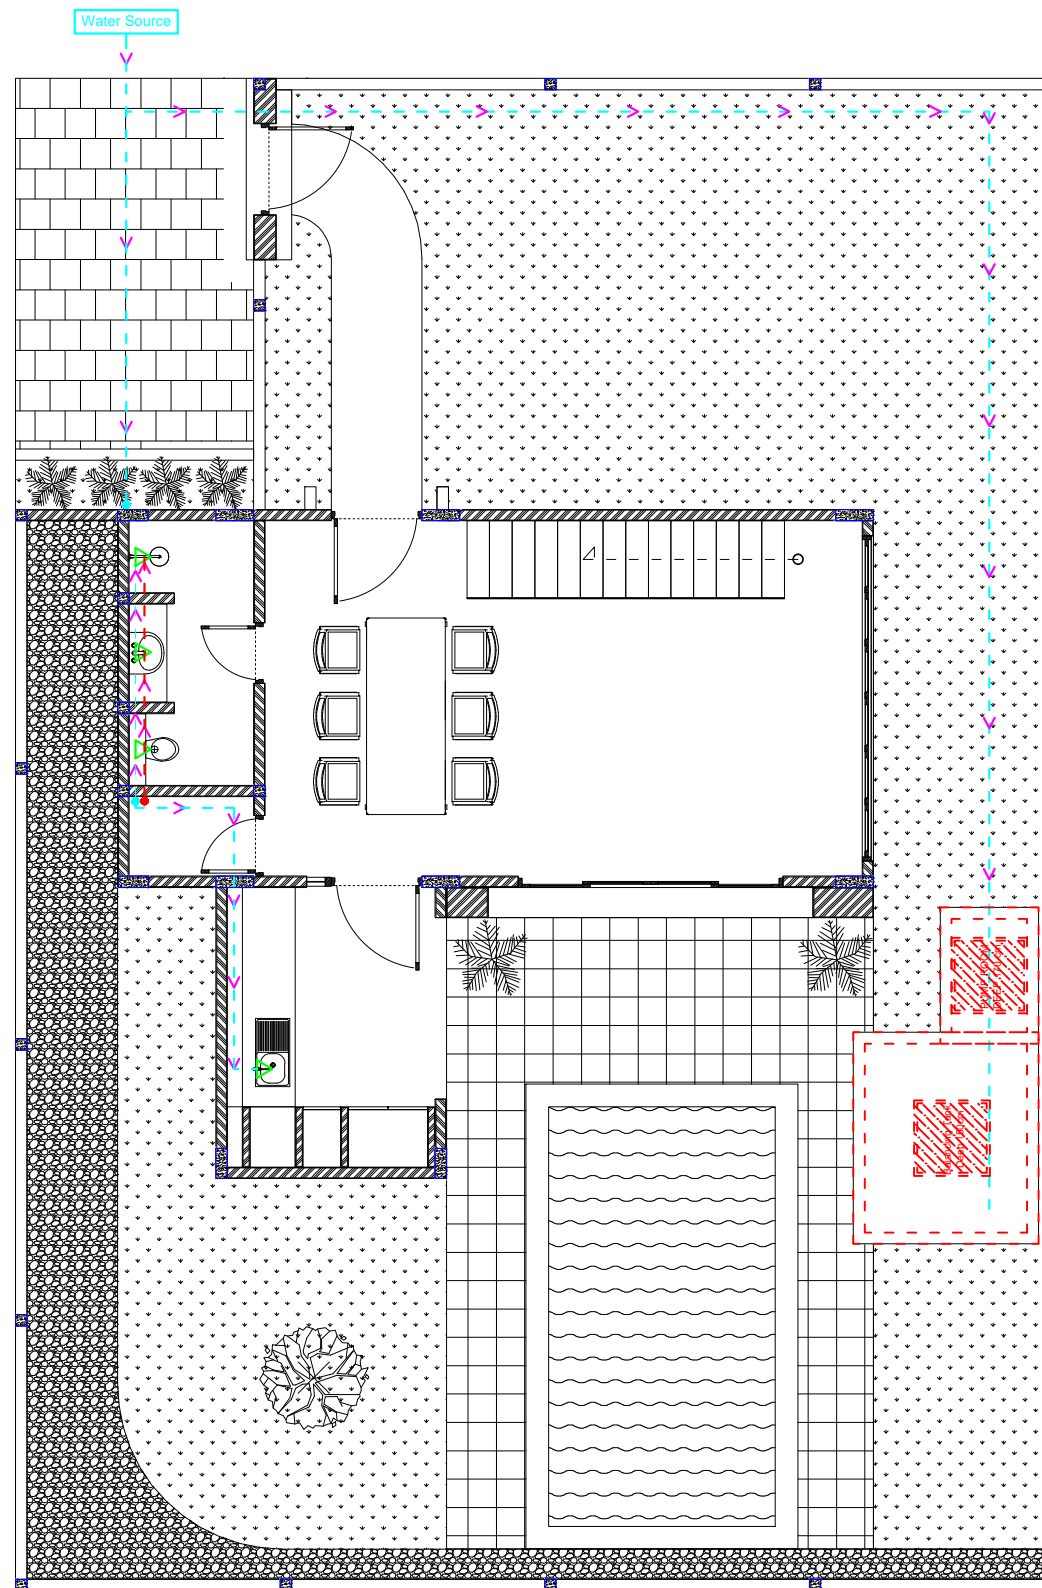

SHOP DRAWING

Project :
Damien Villa

Owner :
Mr. Philippe

Approve by :

.....
.....

Costruction Management :
PT/CV.

Check by :

.....
.....

Costruction Contractor :
PT/CV

Approve by :

.....
.....

No	Revision	Date	Signed

Architect Consultant :

.....

Structure Consultant :

.....


Mechanical Consultant :

.....

Drawing Tittle :

**First Floor
Plumbing Plan**

Scale	Drawn	Guntur Kusuma
1 : 100	Check	Abdi
	Approved	Mr. Philippe
Issued for :	Code	Draw no
Design Development	139	006
Date	10.11.2022	

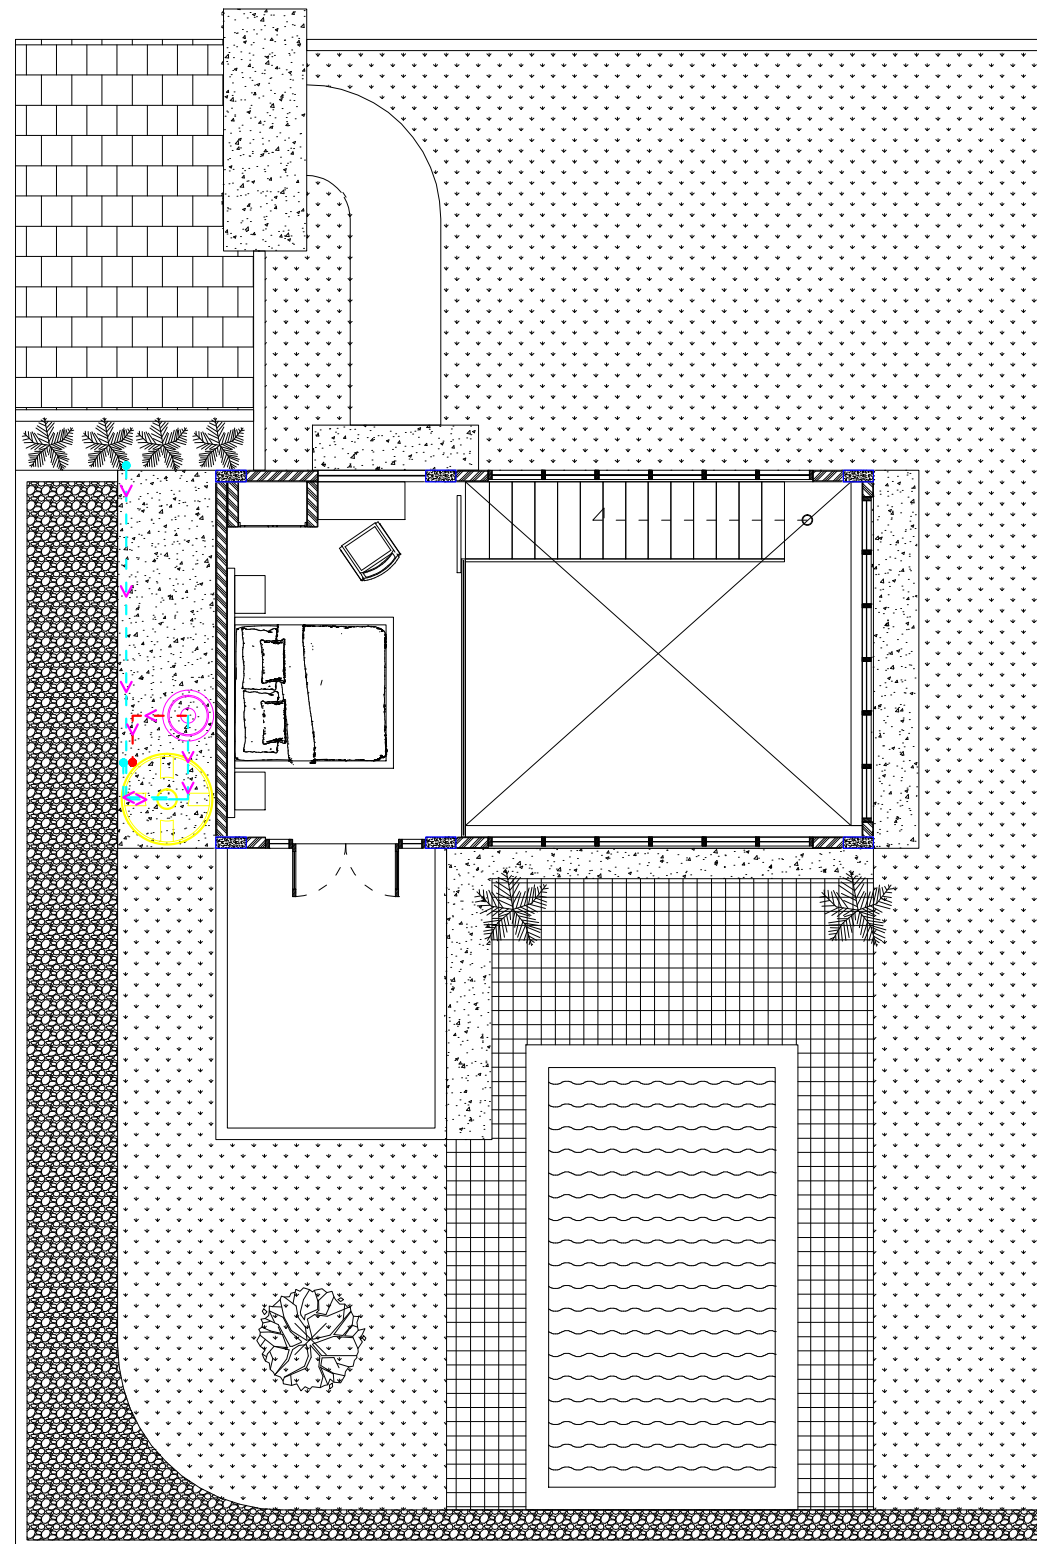

SHOP DRAWING

Project :
Damien Villa

Owner :
Mr. Philippe

Approve by :
.....
.....

Costruction Management :
PT/CV.

Check by :
.....
.....

Costruction Contractor :
PT/CV

Approve by :
.....
.....

No	Revision	Date	Signed

Architect Consultant :
.....


Structure Consultant :
.....

Mechanical Consultant :
.....

Drawing Tittle :

**Ground Floor
Dirty Water Plan**

Scale	Drawn	Guntur Kusuma
1 : 100	Check	Abdi
	Approved	Mr. Philippe
Issued for :		Code Draw no
Design Development		139 007
Date	10.11.2022	

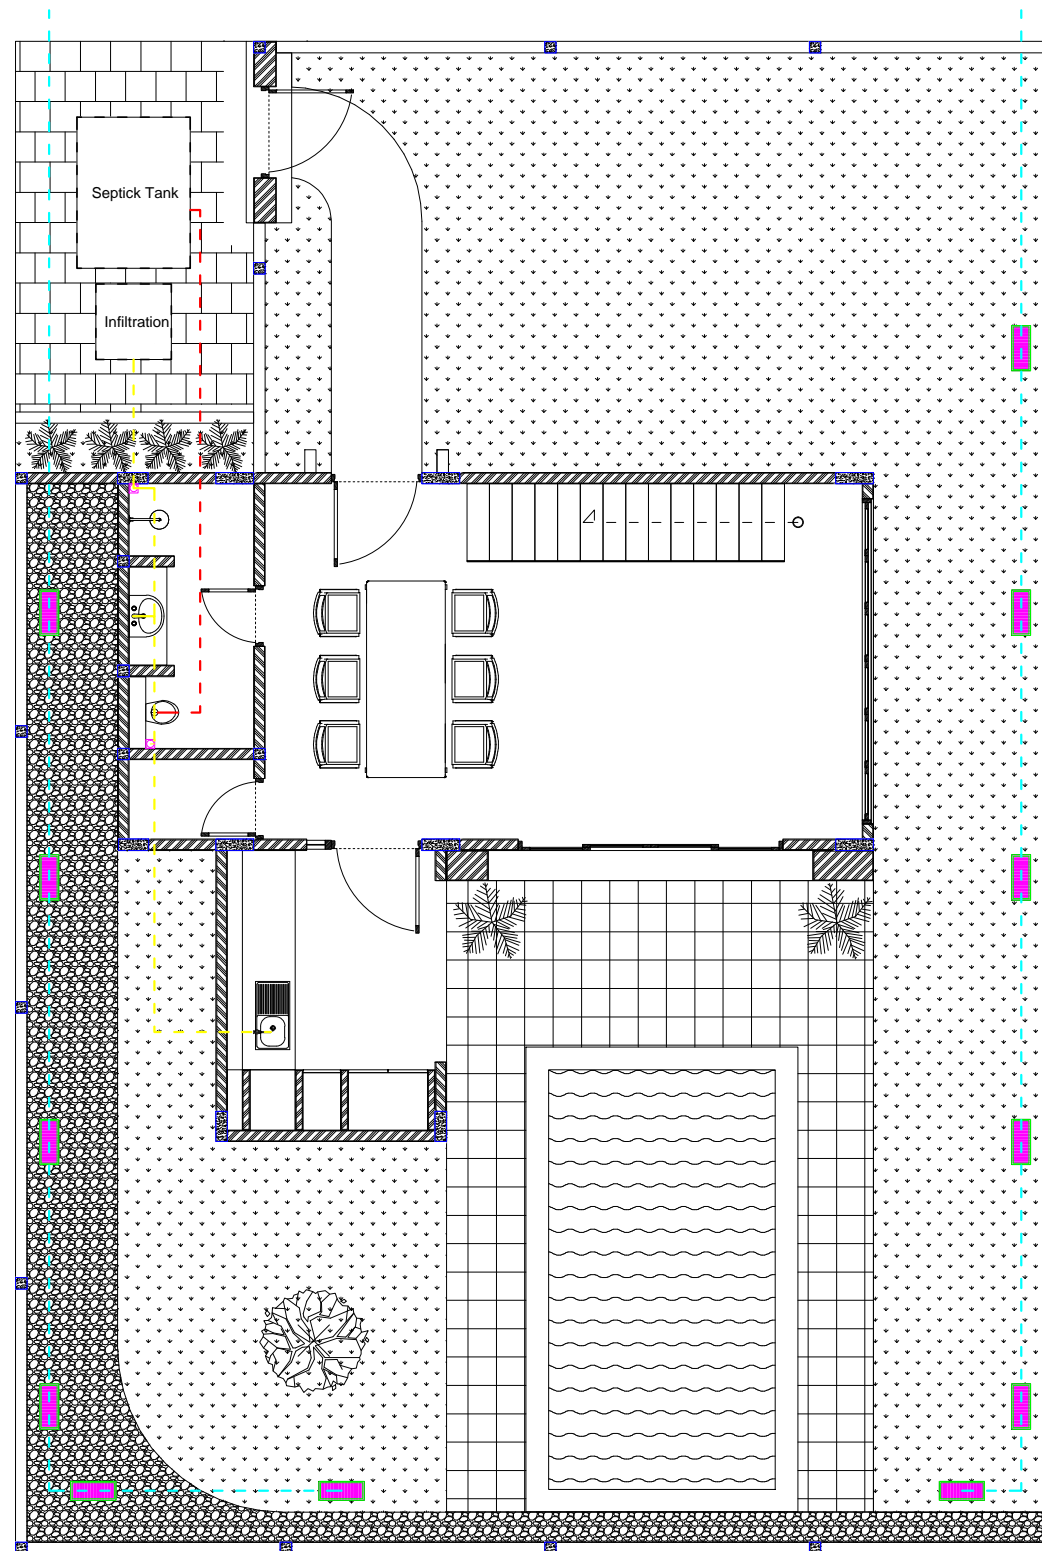

SHOP DRAWING

Project :
Damien Villa

Owner :
Mr. Philippe

Approve by :

.....
.....

Costruction Management :
PT/CV.

Check by :

.....
.....

Costruction Contractor :
PT/CV

Approve by :

.....
.....

No	Revision	Date	Signed

Architect Consultant :

.....

Structure Consultant :

.....


Mechanical Consultant :

.....

Drawing Tittle :

**First Floor
Rain Water Plan**

Scale	Drawn	Guntur Kusuma
1 : 100	Check	Abdi
	Approved	Mr. Philippe
Issued for :	Code	Draw no
Design Development	139	008
Date	10.11.2022	

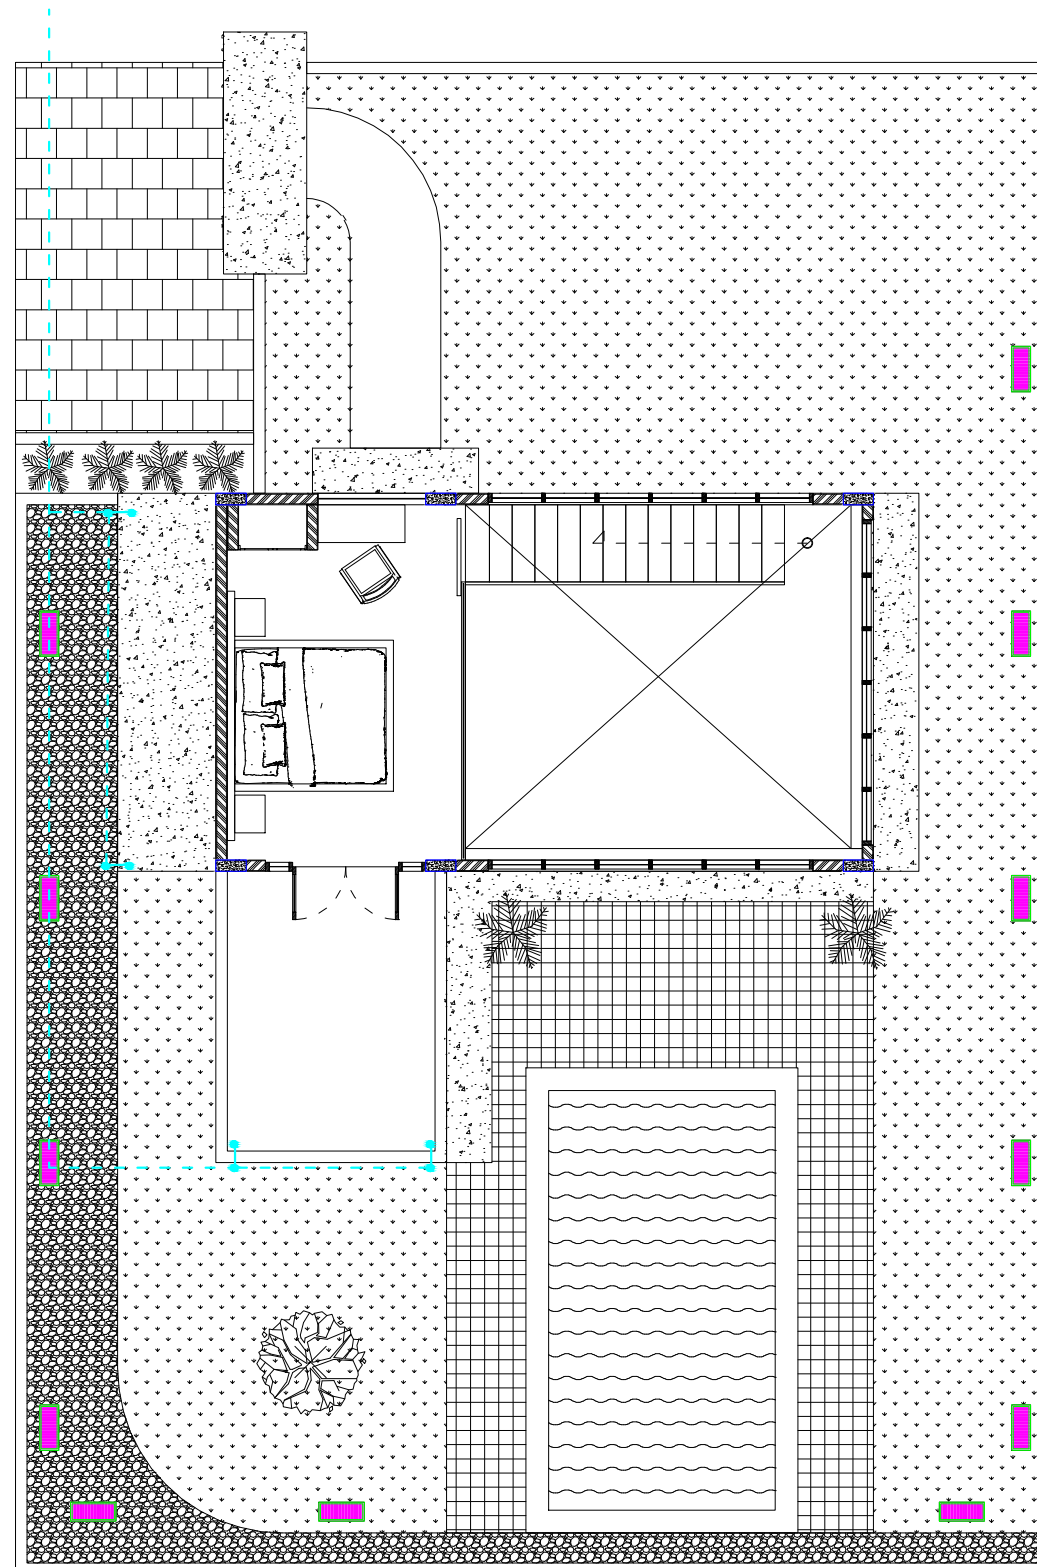

SHOP DRAWING

Project :
Damien Villa

Owner :
Mr. Philippe

Approve by :

.....
.....

Costruction Management :
PT/CV.

Check by :

.....
.....

Costruction Contractor :
PT/CV

Approve by :

.....
.....

No	Revision	Date	Signed

Architect Consultant :

.....

Structure Consultant :

.....


Mechanical Consultant :

.....

Drawing Tittle :

**Roof
Rain Water Plan**

Scale	Drawn	Guntur Kusuma
1 : 100	Check	Abdi
	Approved	Mr. Philippe
Issued for :	Code	Draw no
Design Development	139	009
Date	10.11.2022	

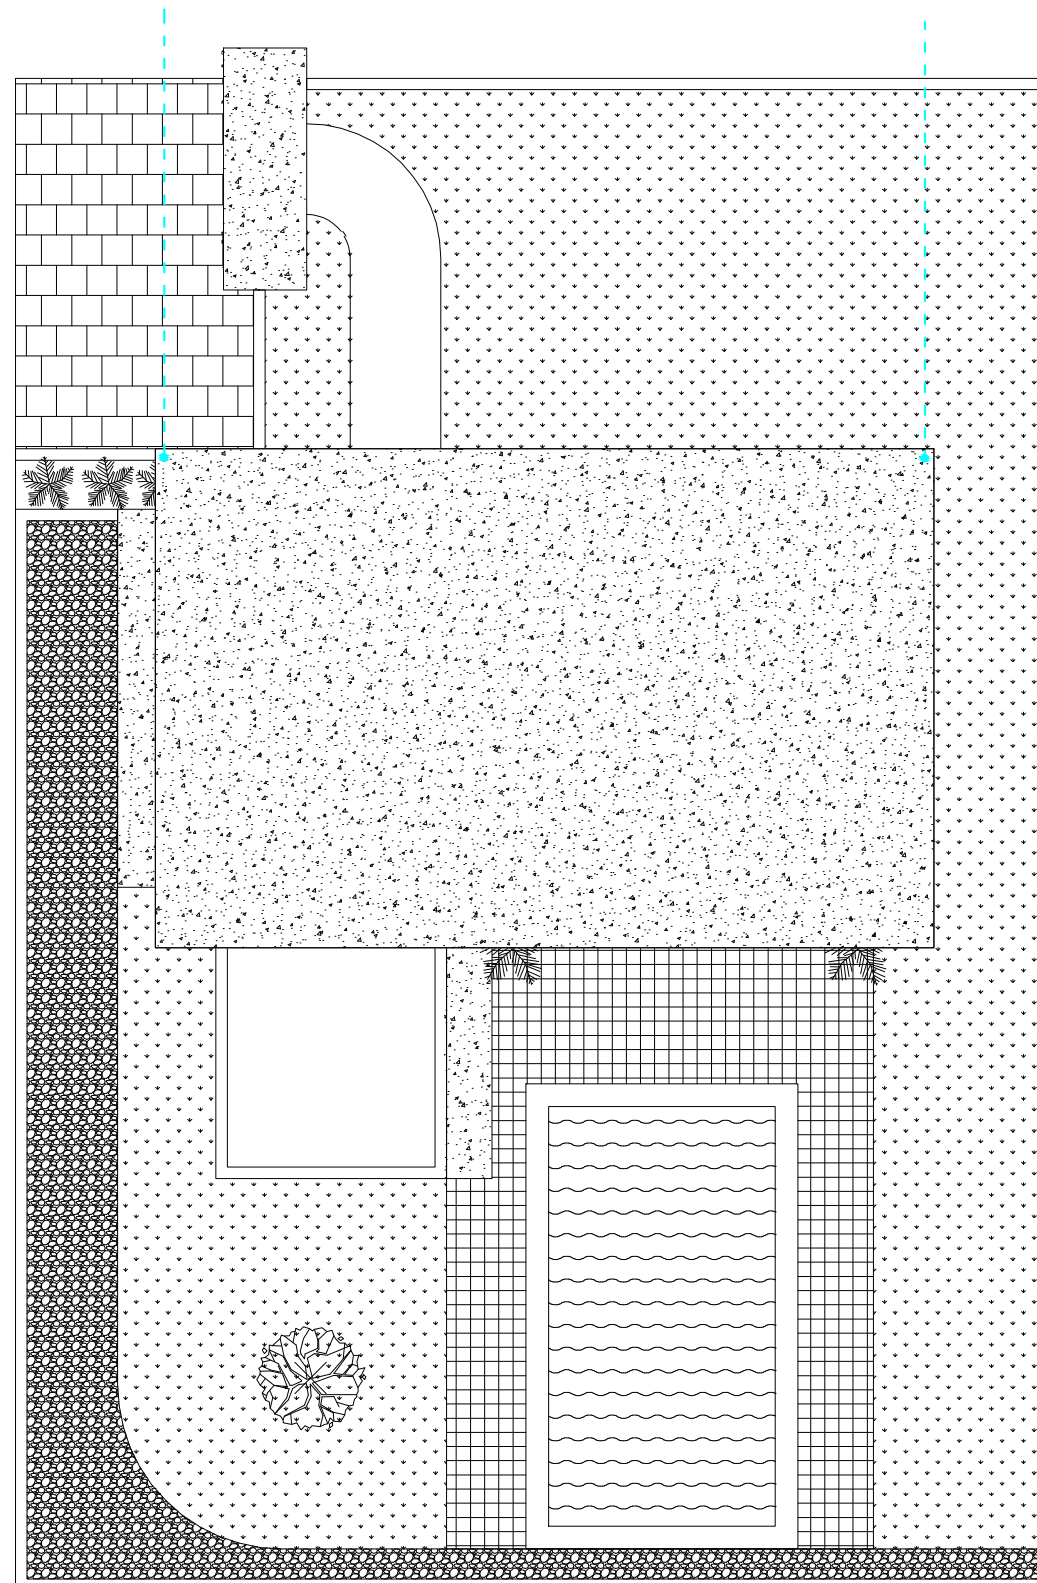

SHOP DRAWING

Project :
Damien Villa

Owner :
Mr. Philippe

Approve by :
.....
.....

Costruction Management :
PT/CV.

Check by :
.....
.....

Costruction Contractor :
PT/CV

Approve by :
.....
.....

No	Revision	Date	Signed

Architect Consultant :
.....


Structure Consultant :
.....

Mechanical Consultant :
.....

Drawing Tittle :

Air Conditioner Plan

Scale	Drawn	Guntur Kusuma
1 : 100	Check	Abdi
	Approved	Mr. Philippe
Issued for :	Code	Draw no
Design Development	139	010
Date	10.11.2022	

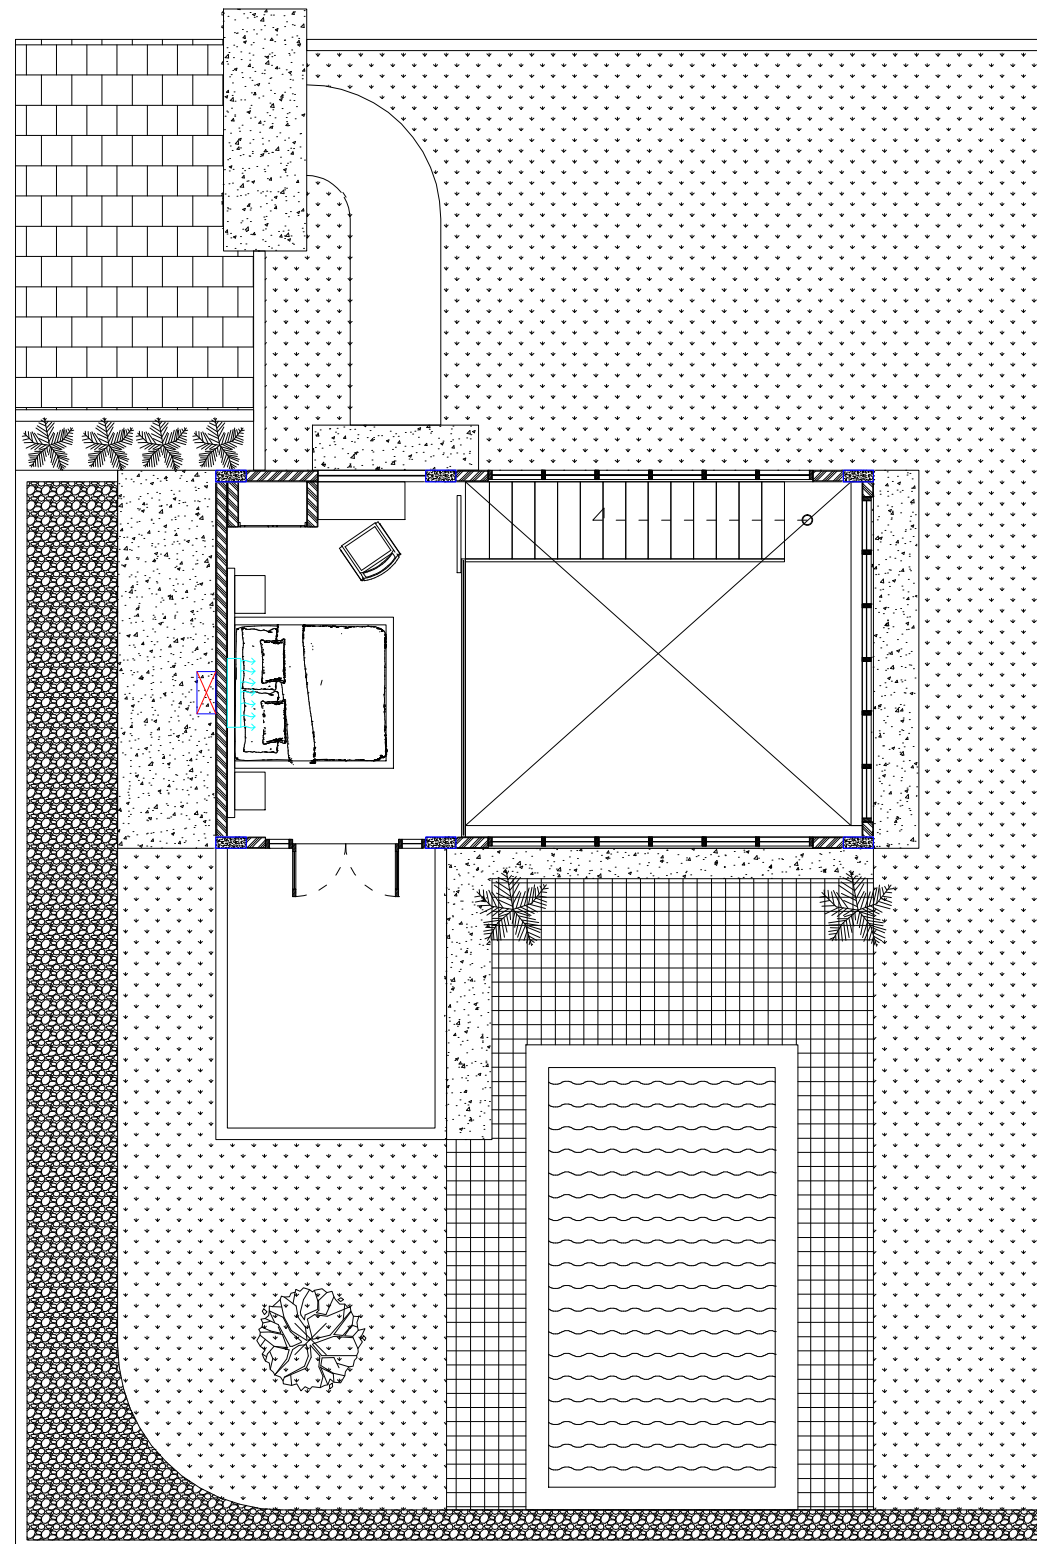

	Air Conditioner
	Outdoor AC



**POOL DRAWING
DAMIEN VILLA**


FOR CONSTRUCTION

**OWNER :
PHILIPPE**



S-B

S-A

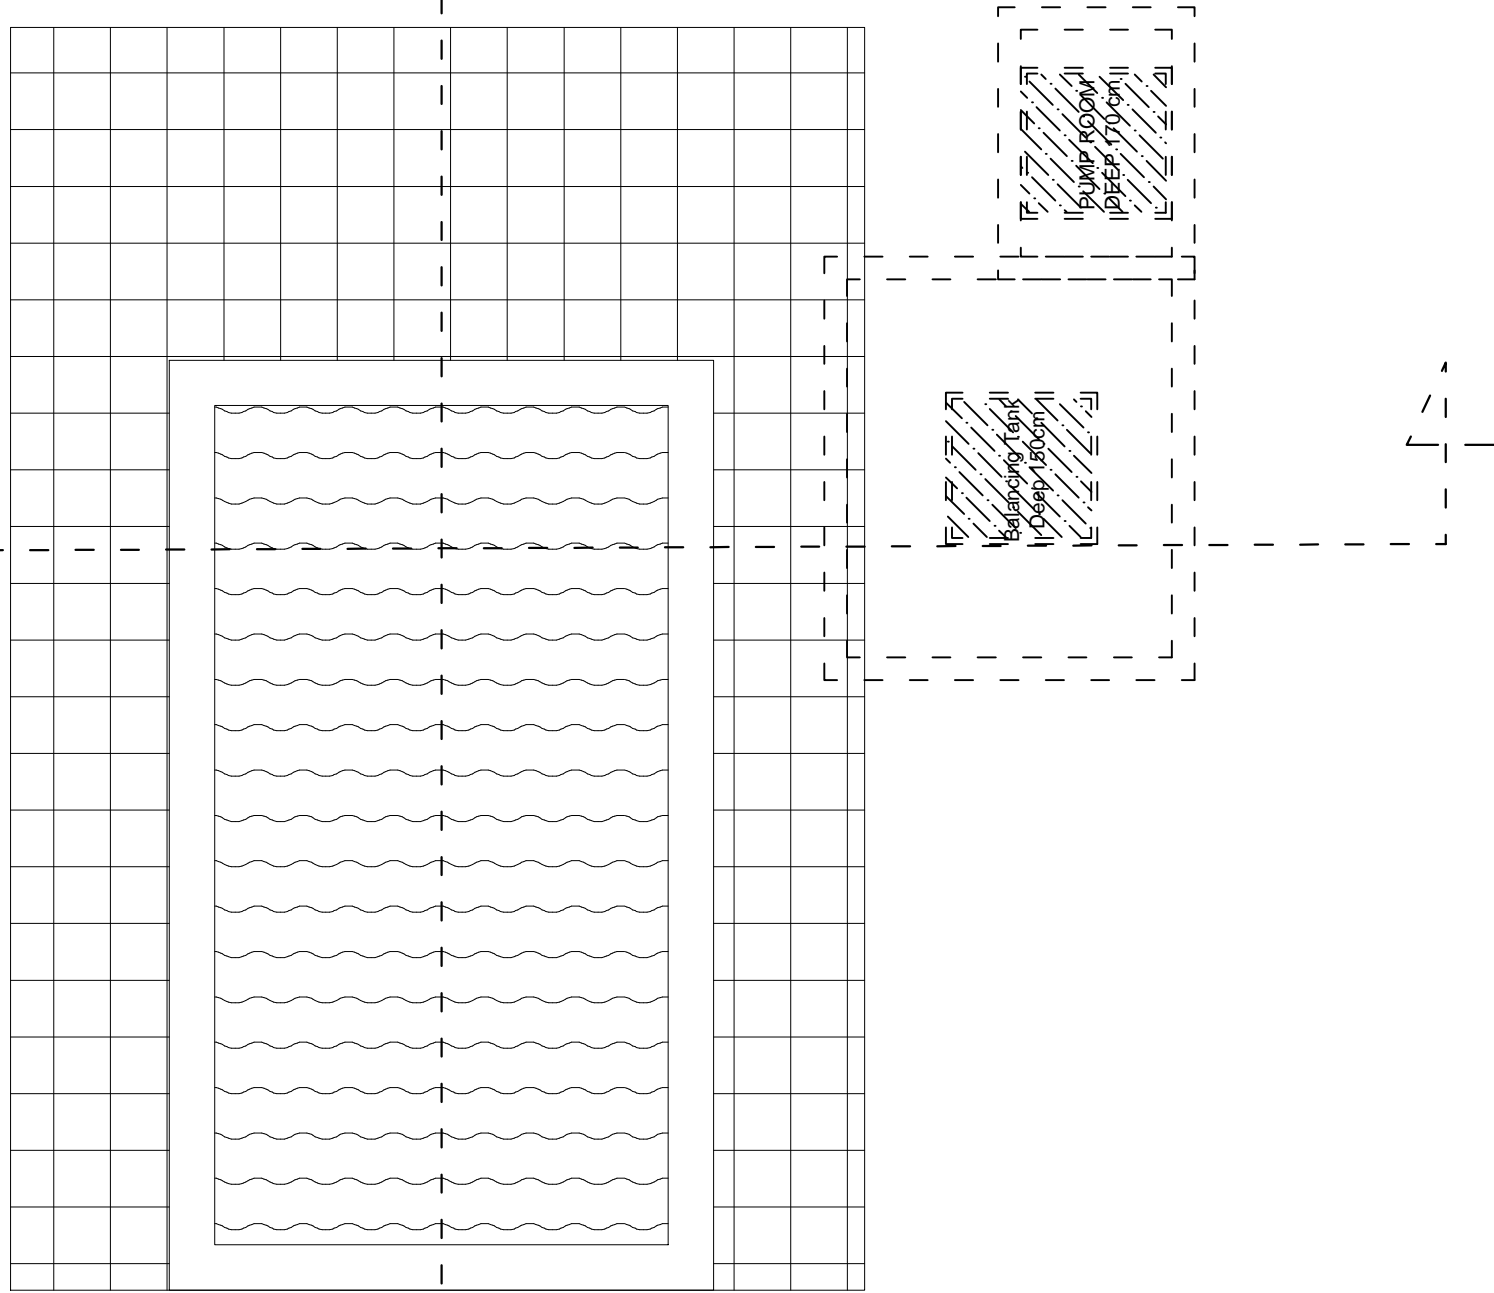

SHOP DRAWING

Project :
Wendy's Villa

Owner :
Mr. Philippe

Approve by :
.....
.....

Costruction Management :
PT/CV.

Check by :
.....
.....

Costruction Contractor :
PT/CV

Approve by :
.....
.....

No	Revision	Date	Signed

Architect Consultant :
.....

Structure Consultant :
.....

Mechanical Consultant :
.....

Drawing Tittle :
Pool Plan

Scale	Drawn	Guntur Kusuma
1 : 50	Check	Abdi
	Approved	Mr. Philippe
Issued for :	Code	Draw no
Design Development	129	001
Date	14.09.2022	

SHOP DRAWING

Project :
Wendy's Villa

Owner :
Mr. Philippe

Approve by :
.....
.....

Costruction Management :
PT/CV.

Check by :
.....
.....

Costruction Contractor :
PT/CV

Approve by :
.....
.....

No	Revision	Date	Signed

Architect Consultant :
.....


Structure Consultant :
.....

Mechanical Consultant :
.....


Drawing Tittle :

Detail Pool
Section

Scale	Drawn	Guntur Kusuma
1 : 50	Check	Abdi
	Approved	Mr. Philippe
Issued for :	Code	Draw no
Design Development	129	002
Date	14.09.2022	

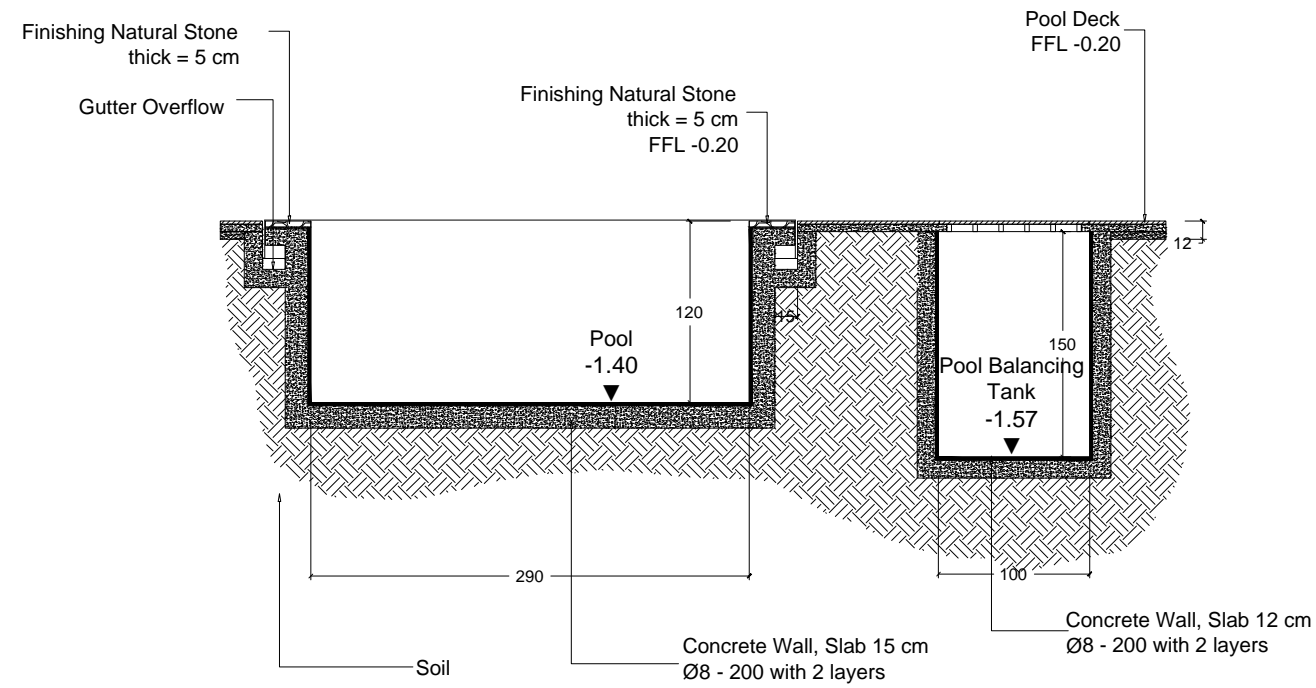

Section A

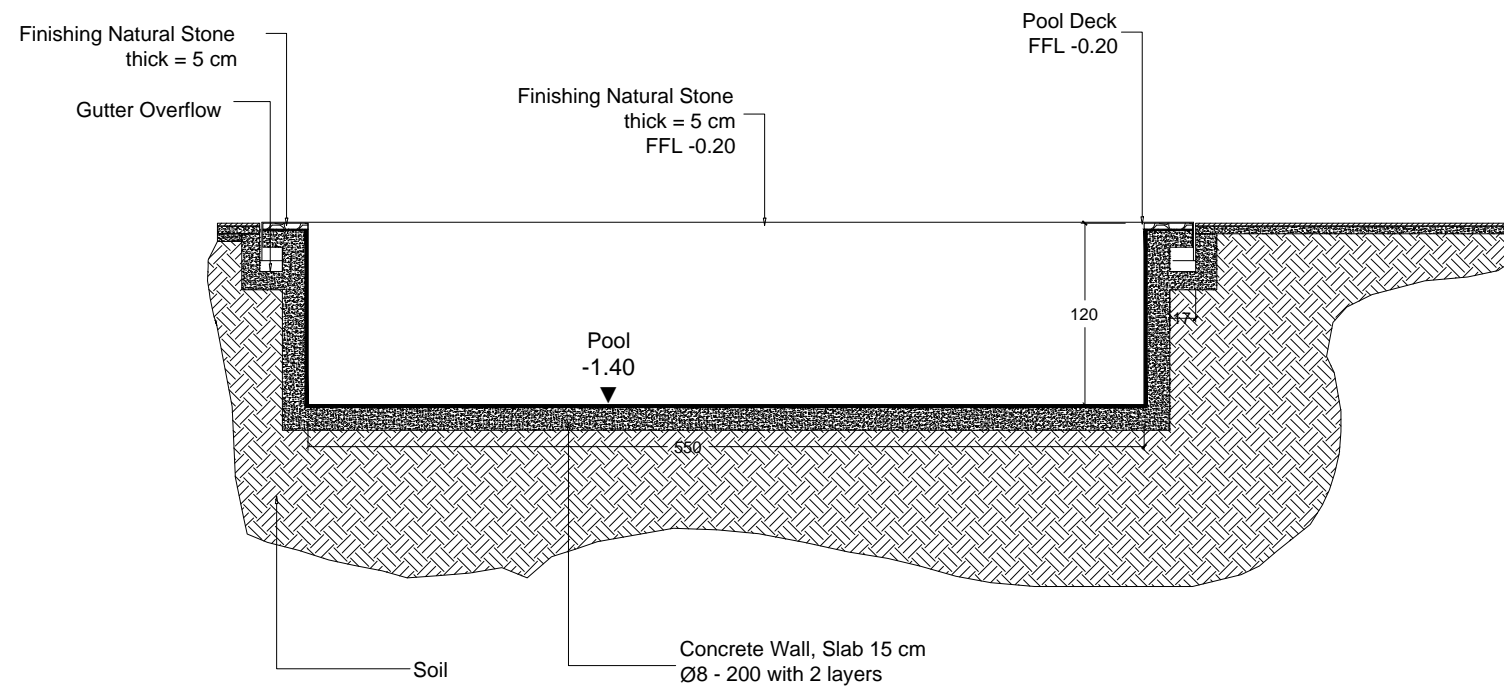

Section B



SHOP DRAWING

Project :
Wendy's Villa

Owner :
Mr. Philippe

Approve by :

.....
.....

Costruction Management :
PT/CV.

Check by :

.....
.....

Costruction Contractor :
PT/CV

Approve by :

.....
.....

No	Revision	Date	Signed

Architect Consultant :

.....

Structure Consultant :

.....


Mechanical Consultant :

.....


Drawing Title :

Elevation Pool


Scale	Drawn	Guntur Kusuma
1 : 50	Check	Abdi
	Approved	Mr. Philippe
Issued for :	Code	Draw no
Design Development	129	003
Date	14.09.2022	

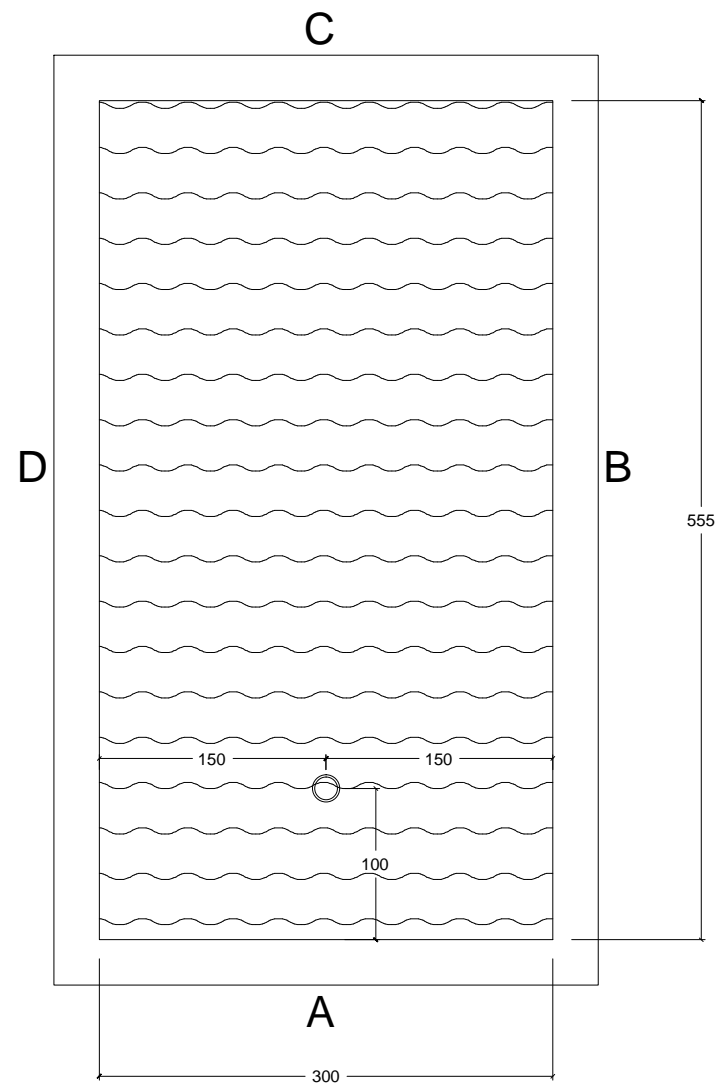

Plan

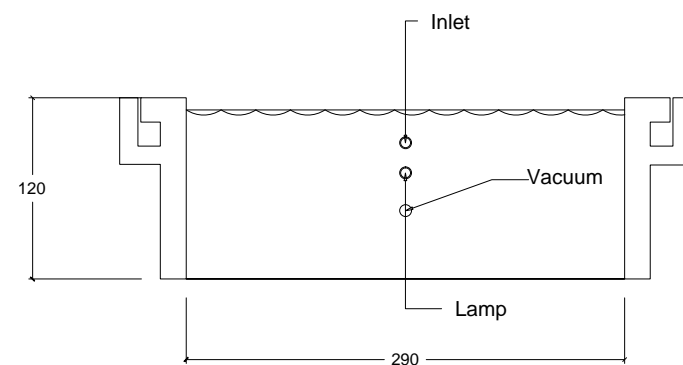

Elevation A

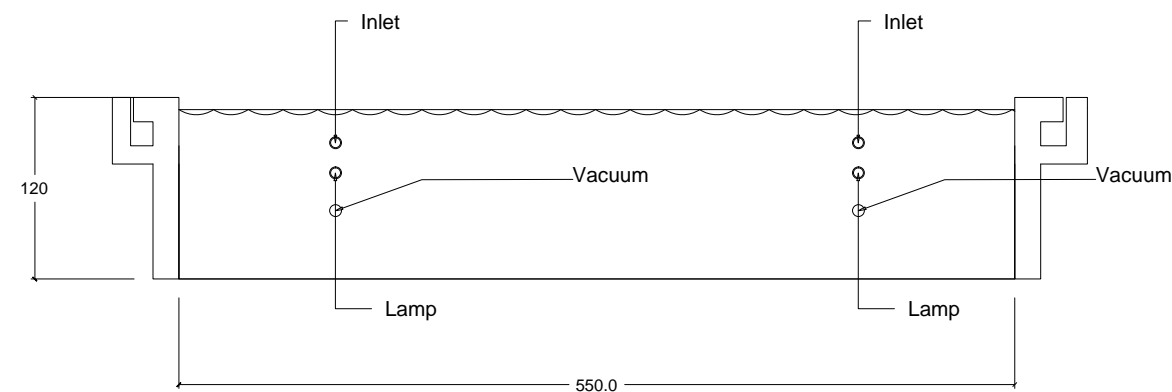

Elevation B

